

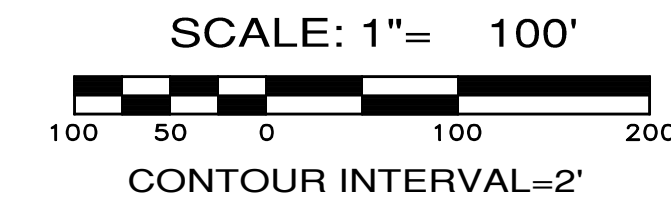
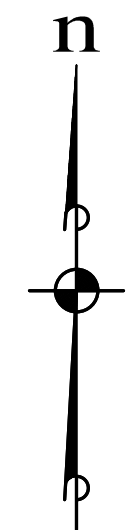
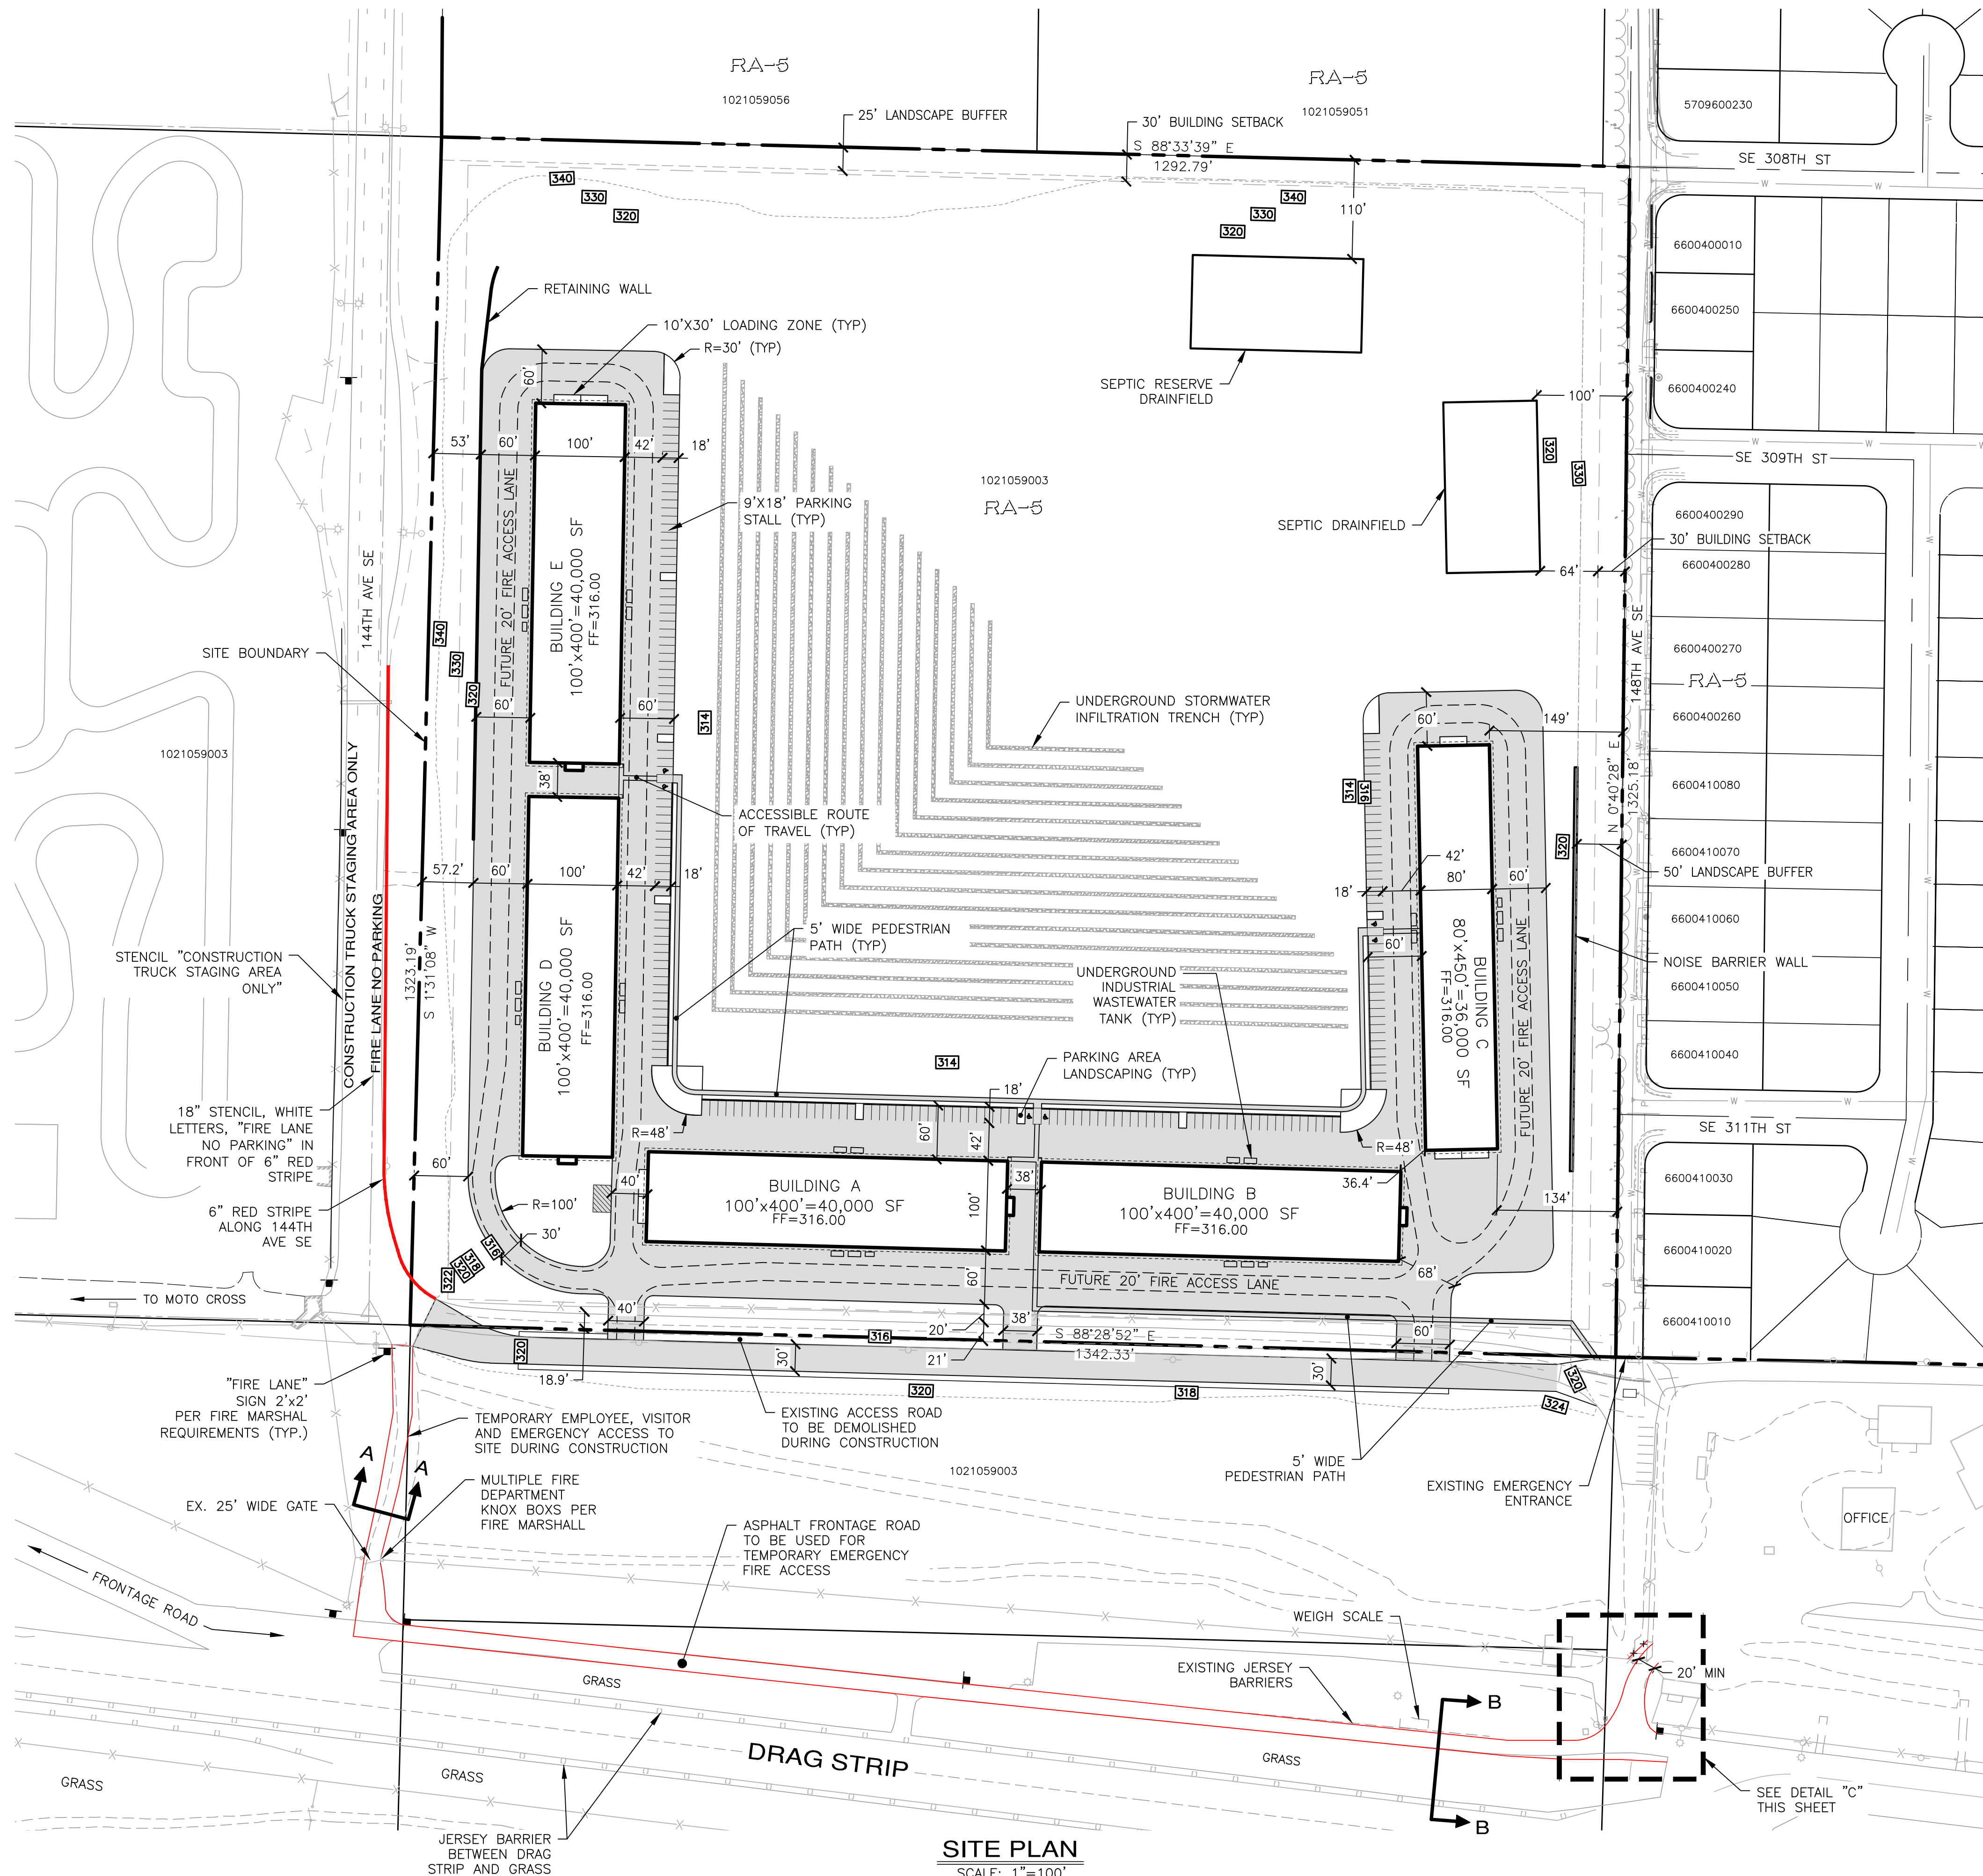
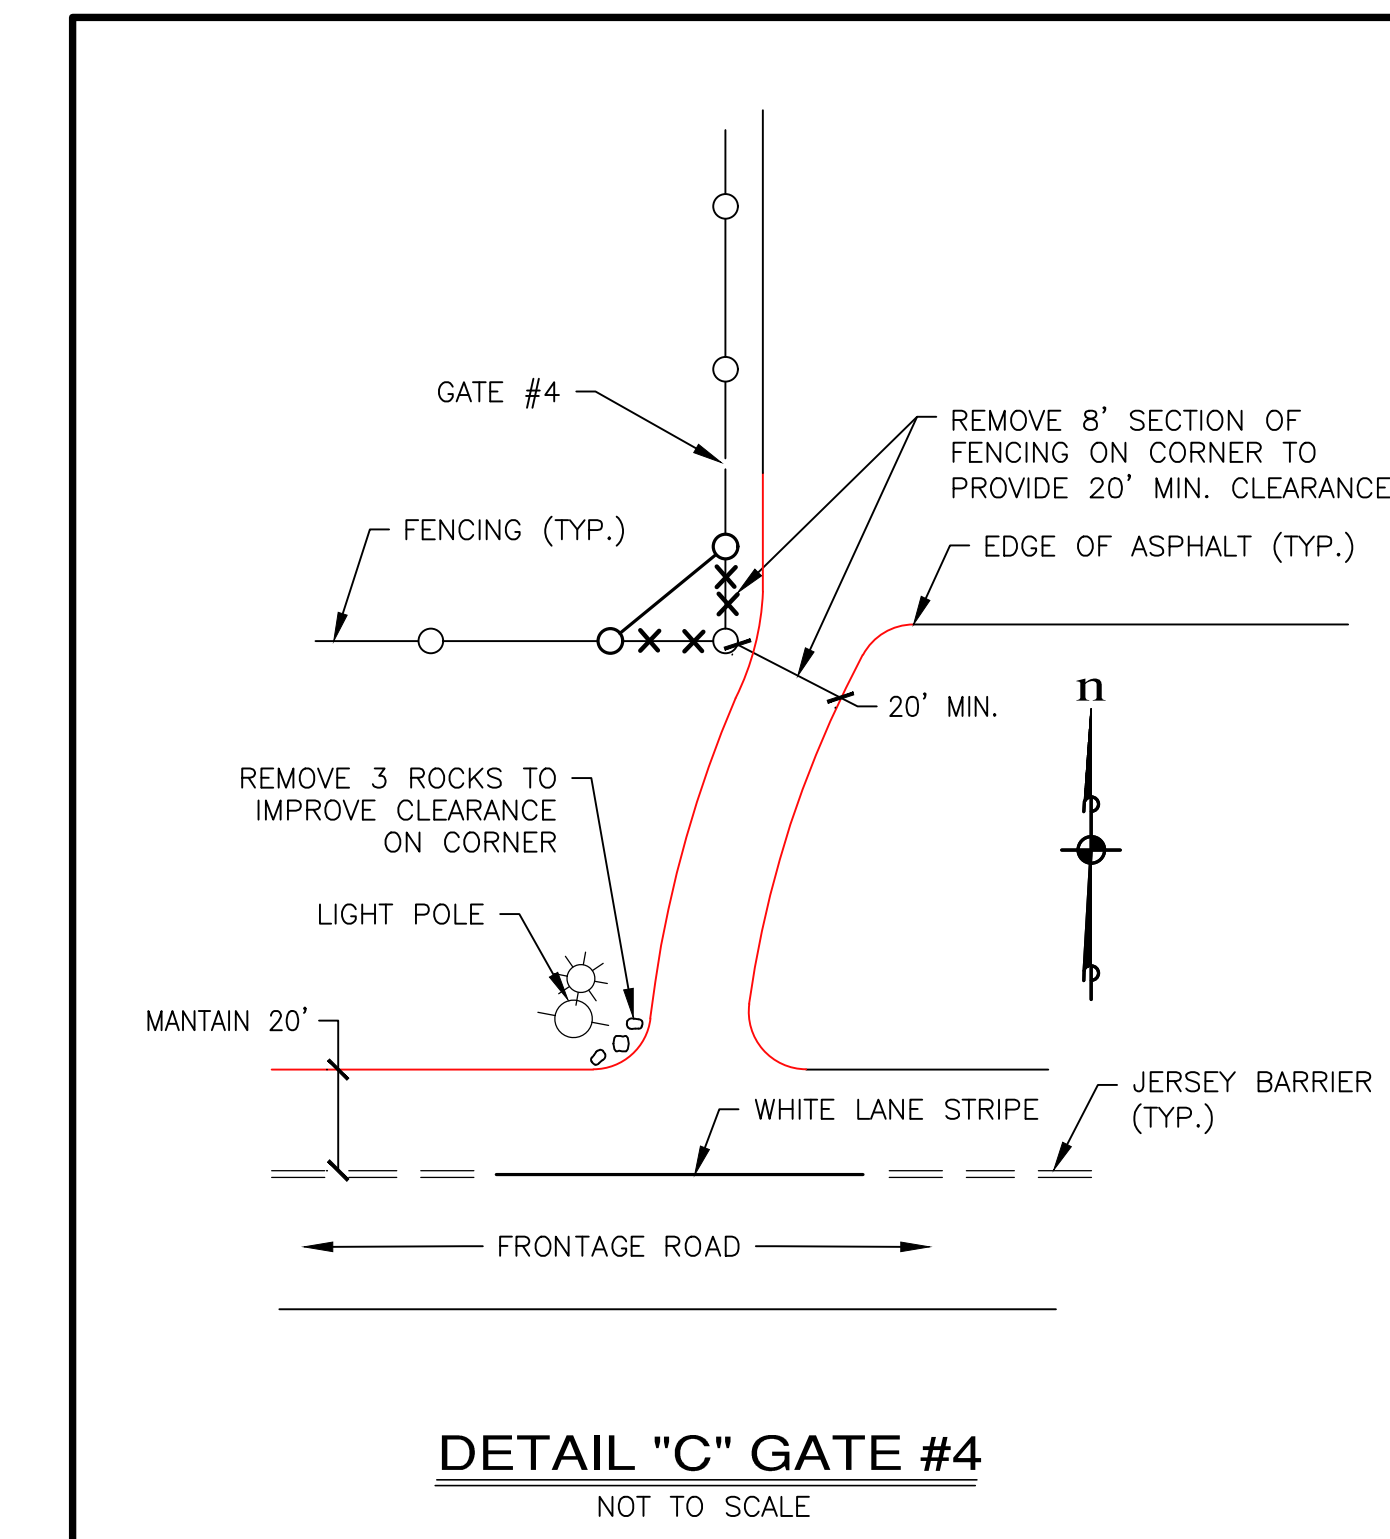


# PACIFIC RACEWAY BUSINESS PARK TEMPORARY EMERGENCY FIRE ACCESS LANE PLAN

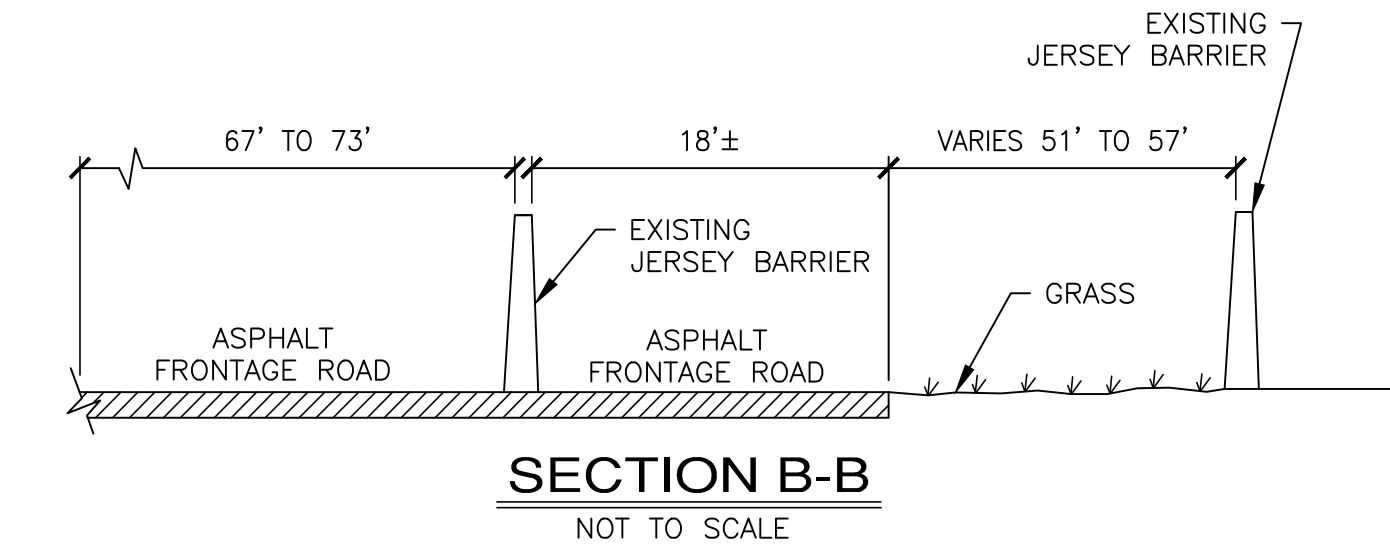


### LEGEND

- DAYLIGHT LINE
- - - 812 --- EXISTING CONTOUR
- - - 812 --- PROPOSED CONTOUR

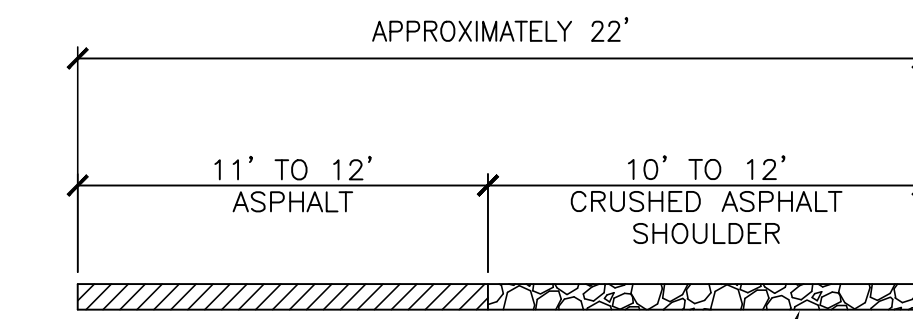

**SITE PLAN**  
SCALE: 1"=100'

REVISIONS		
NO.	DESCRIPTION/DATE	BY
2	12/10/2016	ESM
3	COUNTY COMMENTS 01/22/19	ESM

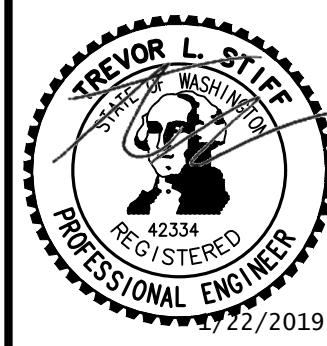

**ESM CONSULTING ENGINEERS LLC**  
 33400 8th Ave S, Suite 205  
 Federal Way, WA 98003  
 (206) 838-6113  
 (206) 837-9900  
 www.esmcivil.com  
 Lead, Supervising Engineer  
 Project Management  
 Land Planning  
 Landscape Architecture

**PACIFIC RACEWAYS**  
**BUSINESS PARK**  
 TEMPORARY EMERGENCY FIRE ACCESS LANE PLAN  
 WASHINGTON

JOB NO.: 1263-002-016  
 DWG. NAME: FP-01  
 DESIGNED BY: TLS  
 DRAWN BY: CJR  
 CHECKED BY:  
 DATE: 01/22/2019  
 DATE OF PRINT:

File: \\sands\myproj\ESM-085\1363\002\016\plans\Site Plan\FP-01\_1\_14321\_0305.wpd  
 Date: 1/22/2019 8:53 AM  
 Printed By: Brandon Gordon