

**FROM S 200TH ST TO S NORMANDY ROAD / DES MOINES MEMORIAL DRIVE INTERSECTION
KING COUNTY, WASHINGTON
CONTRACT NO. X / FEDERAL AID# X**

MIDWAY SEWER DISTRICT
BROCK POWELL
3030 S 240TH ST
KENT, WA 98032
PHONE: (206) 824-4960 / (206) 484-1475
EMAIL: brock@midwaysewer.org

SHEET NO.
1 OF 33

G1

30 % REVIEW SUBMITTAL
NOT FOR CONSTRUCTION

LAYOUT: G2 PATH: U:\PSO\Projects\Clients\1521-KingCo\554-1521-151 L2ST-SegC\99Sics\CADD\Phase 2C\Task 21200C\DWG\ PLOTTED BY: purgabul DATE: Thursday, March 09, 2017 4:48:58 PM



LEGEND

DESCRIPTION

PROPOSED

EXISTING

RIGHT OF WAY
 PROPERTY LINE
 CITY BOUNDARY
 FOUND MONUMENTS
 REBAR & CAP
 HUB & TACK
 PK NAIL
 FOUND MAG NAIL
 SET MAG NAIL
 PROPERTY CORNER
 STREAM
 EDGE OF WATER
 WETLAND FLAG
 ORDINARY HIGH WATER MARK
 DITCH
 STORM DRAIN
 CULVERT/STORM DRAIN PIPE
 UNDERDRAIN PIPE
 INFILTRATION TRENCH
 CATCH BASIN, TYPE 1
 CATCH BASIN, TYPE 2
 CATCH BASIN W/ SOLID LID
 SANITARY SEWER LINE
 SANITARY SEWER MANHOLE
 SANITARY SEWER VAULT
 CLEANOUT
 CONTOURS MAJOR
 CONTOURS MINOR
 CLEARING AND GRUBBING LIMITS
 FILL LINE
 CUT LINE
 ASPHALT EDGE
 CONCRETE LINE
 CURB AND GUTTER
 EDGE OF PATCH
 BARB WIRE CRANFEE
 SPLIT RAIL FENCE
 BOARD FENCE
 CHAIN LINK FENCE
 HOG WIRE FENCE
 WOOD GUARDRAIL
 GUY ANCHOR
 POWER POLE WITH LIGHT
 FLOOD LIGHT
 UTILITY POLE
 PP W/ UG DROP
 PP W/ UG DROP & YMER

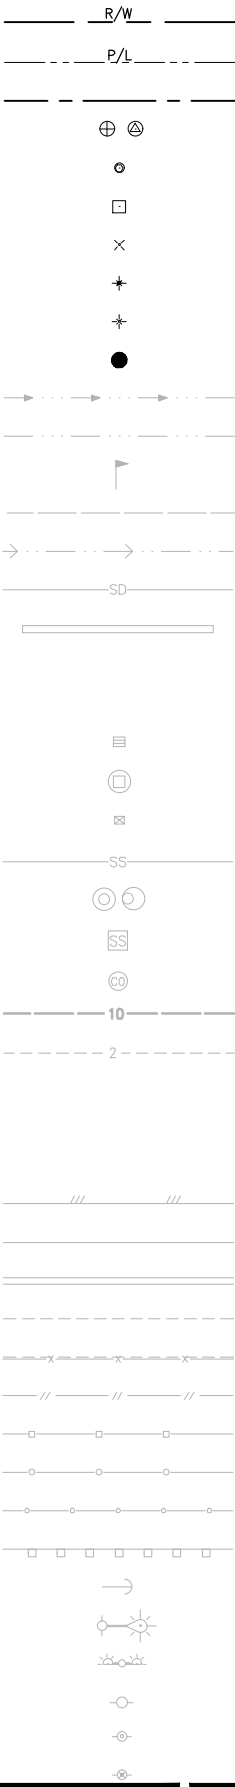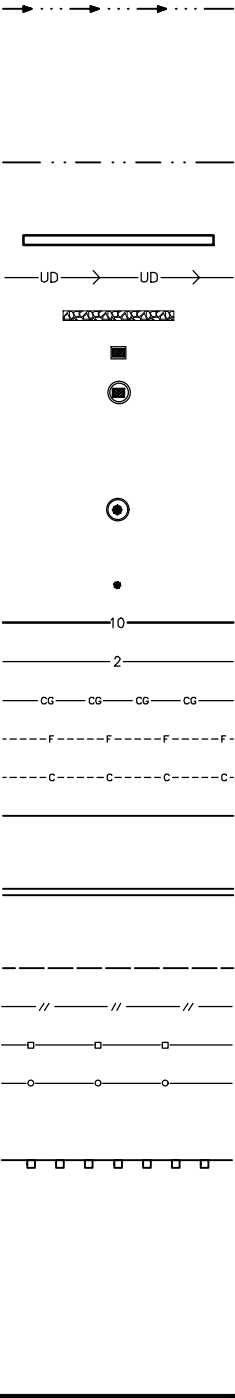


LEGEND

DESCRIPTION

PROPOSED

EXISTING

OVERHEAD POWER
 POWER
 POWER VAULT
 POWER TRANSFORMER
 POWER MANHOLE
 POWER HANDHOLE
 POWER CABINET
 POWER RISER
 POWER METER
 SOLID LID J-BOX
 LUMINAIRE
 TELEPHONE VAULT
 TELEPHONE RISER
 TELEPHONE MANHOLE
 TELEPHONE
 TV RISER
 TV
 GAS VALVE
 GAS METER
 GAS
 WATER LINE
 FIRE HYDRANT
 WATER METER
 WATER VALVE
 AREA DRAIN
 ROOF DRAIN
 WATER BLOW OFF VALVE
 WATER POST INDICATOR
 SPRINKLER HEAD ROT=90
 IRRIGATION CONTROL VALVE
 TRAFFIC SIGNAL POLE W/ LAMP
 TRAFFIC SIGNAL POLE
 TRAFFIC CONTROL LOOP (SQ)
 TRAFFIC CONTROL CABINET
 PEDESTRIAN POLE
 MONITORING WELL
 SURFACE POST
 SIGN
 SKIP LANE LINE
 SOLID LANE LINE
 FOG LINE
 LTO ARROW
 STO ARROW
 RTO ARROW
 MAILBOX
 DECIDUOUS TREE

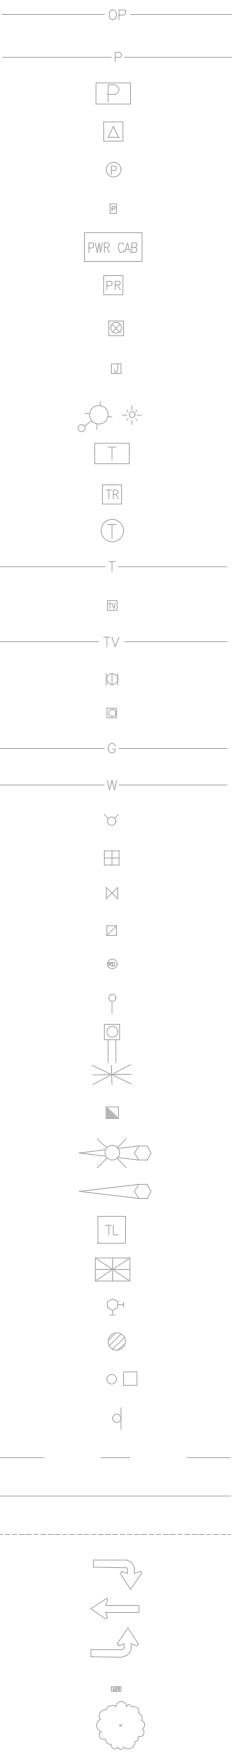


LEGEND

DESCRIPTION

PROPOSED

EXISTING


CONIFEROUS TREE
 WETLAND SYMBOL
 WETLAND BOUNDARY
 VEGETATION
 STRUCTURAL EARTH WALL
 RIP RAP
 ROCKERY
 HANDICAPPED SYMBOL
 WHEELCHAIR RAMP
 BUILDING LINE
 CONSTRUCTION CENTERLINE

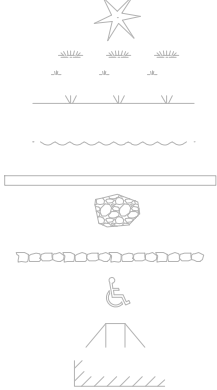

ABBREVIATIONS:

ACP	ASPHALT CONCRETE PAVEMENT	N	NORTH, NORTHING
BOC	BACK OF CURB	N.I.C.	NOT IN CONTRACT
BOW	BOTTOM OF WALL	NST	NOT STEEPER THAN
BVCE	BEGIN VERTICAL CURVE ELEVATION	PC	POINT OF CURVE
BVCS	BEGIN VERTICAL CURVE STATION	PT	POINT OF TANGENT
CB	CATCH BASIN	P/L	PROPERTY LINE
C&G	CURB AND GUTTER	PUD	PUBLIC UTILITY DISTRICT
C/L	CENTERLINE	PVI	POINT OF VERTICAL INTERSECTION
CONC	CONCRETE	REINF	REINFORCED
CONST	CONSTRUCTION	ROW or R/W	RIGHT-OF-WAY
CMP	CORRUGATED METAL PIPE	SD	STORM DRAIN
CP	CONCRETE PIPE	SDMH	STORMWATER MANHOLE
CSTC	CRUSHED SURFACING TOP COURSE	SIM	SIMILAR
DIA	DIAMETER	SS	SANITARY SEWER
DI, DIP	DUCTILE IRON PIPE	ST	STEEL
E	EAST, EASTING	STA	STATION
EOA	EDGE OF ASPHALT	TEL	TELEPHONE
EVCE	END VERTICAL CURB ELEVATION	TESC	TEMPORARY EROSION AND SEDIMENT CONTROL
EVCS	END VERTICAL CURB STATION	TOW	TOP OF WALL
EOG	EDGE OF GRAVEL	TYP	TYPICAL
EOP	EDGE OF PAVEMENT	W	WATER
EX, EXIST	EXISTING	WS	WATER SERVICE
FOC	FACE OF CURB	WSDOT	WASHINGTON STATE DEPARTMENT OF TRANSPORTATION
FL	FLANGE, FLOWLINE	WWM	WELDED WIRE MESH
G	GAS		
GB	GRADE BREAK		
HMA	HOT MIX ASPHALT		
IE	INVERT ELEVATION		
LF	LINEAR FEET		
LP	LOW POINT		
LT	LEFT		
ME	MATCH EXISTING		
MIN	MINIMUM		
MON	MONUMENT		

DETAIL AND SECTION DESIGNATION

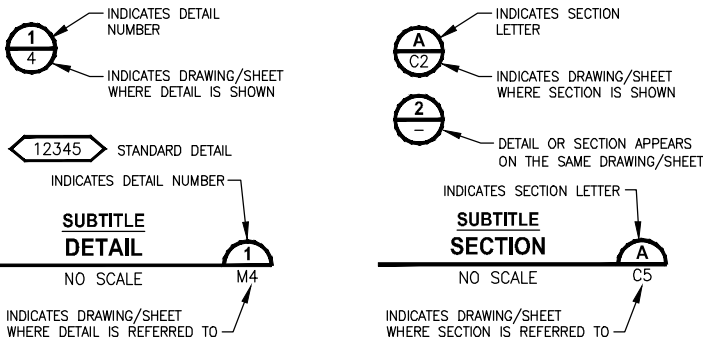

30 % REVIEW SUBMITTAL
 NOT FOR CONSTRUCTION

REVISIONS	DATE	BY	DESIGNED
			J. JUN
			B. PURGANAN
			CHECKED Y. HO
			APPROVED J. DVORAK

ONE INCH AT FULL SCALE, IF NOT, SCALE ACCORDINGLY
FILE NAME PS1521151P2CT2T2G-02
JOB No. 554-1521-151 P2C T2T200C
DATE MARCH 2017

PRELIMINARY

Parametrix

ENGINEERING · PLANNING · ENVIRONMENTAL SCIENCES

719 2ND AVENUE, SUITE 200 | SEATTLE, WA 98104
 P 206.394.3700
 WWW.PARAMETRIX.COM

PROJECT NAME

LAKE TO SOUND TRAIL
 SEGMENT C


FROM S 200TH ST TO S NORMANDY ROAD /
 DES MOINES MEMORIAL DRIVE INTERSECTION

ABBREVIATIONS AND LEGEND

SHEET NO.
 2 OF 33

G2

PATH: U:\P50\Projects\Clients\1521-KingCo\554-1521-151 L2ST-SegC\995\cadd\Phase 2C\Task 21200C.DWG PLOTTED BY: purgobut DATE: Thursday, March 09, 2017 4:49:15 PM LAYOUT: G3

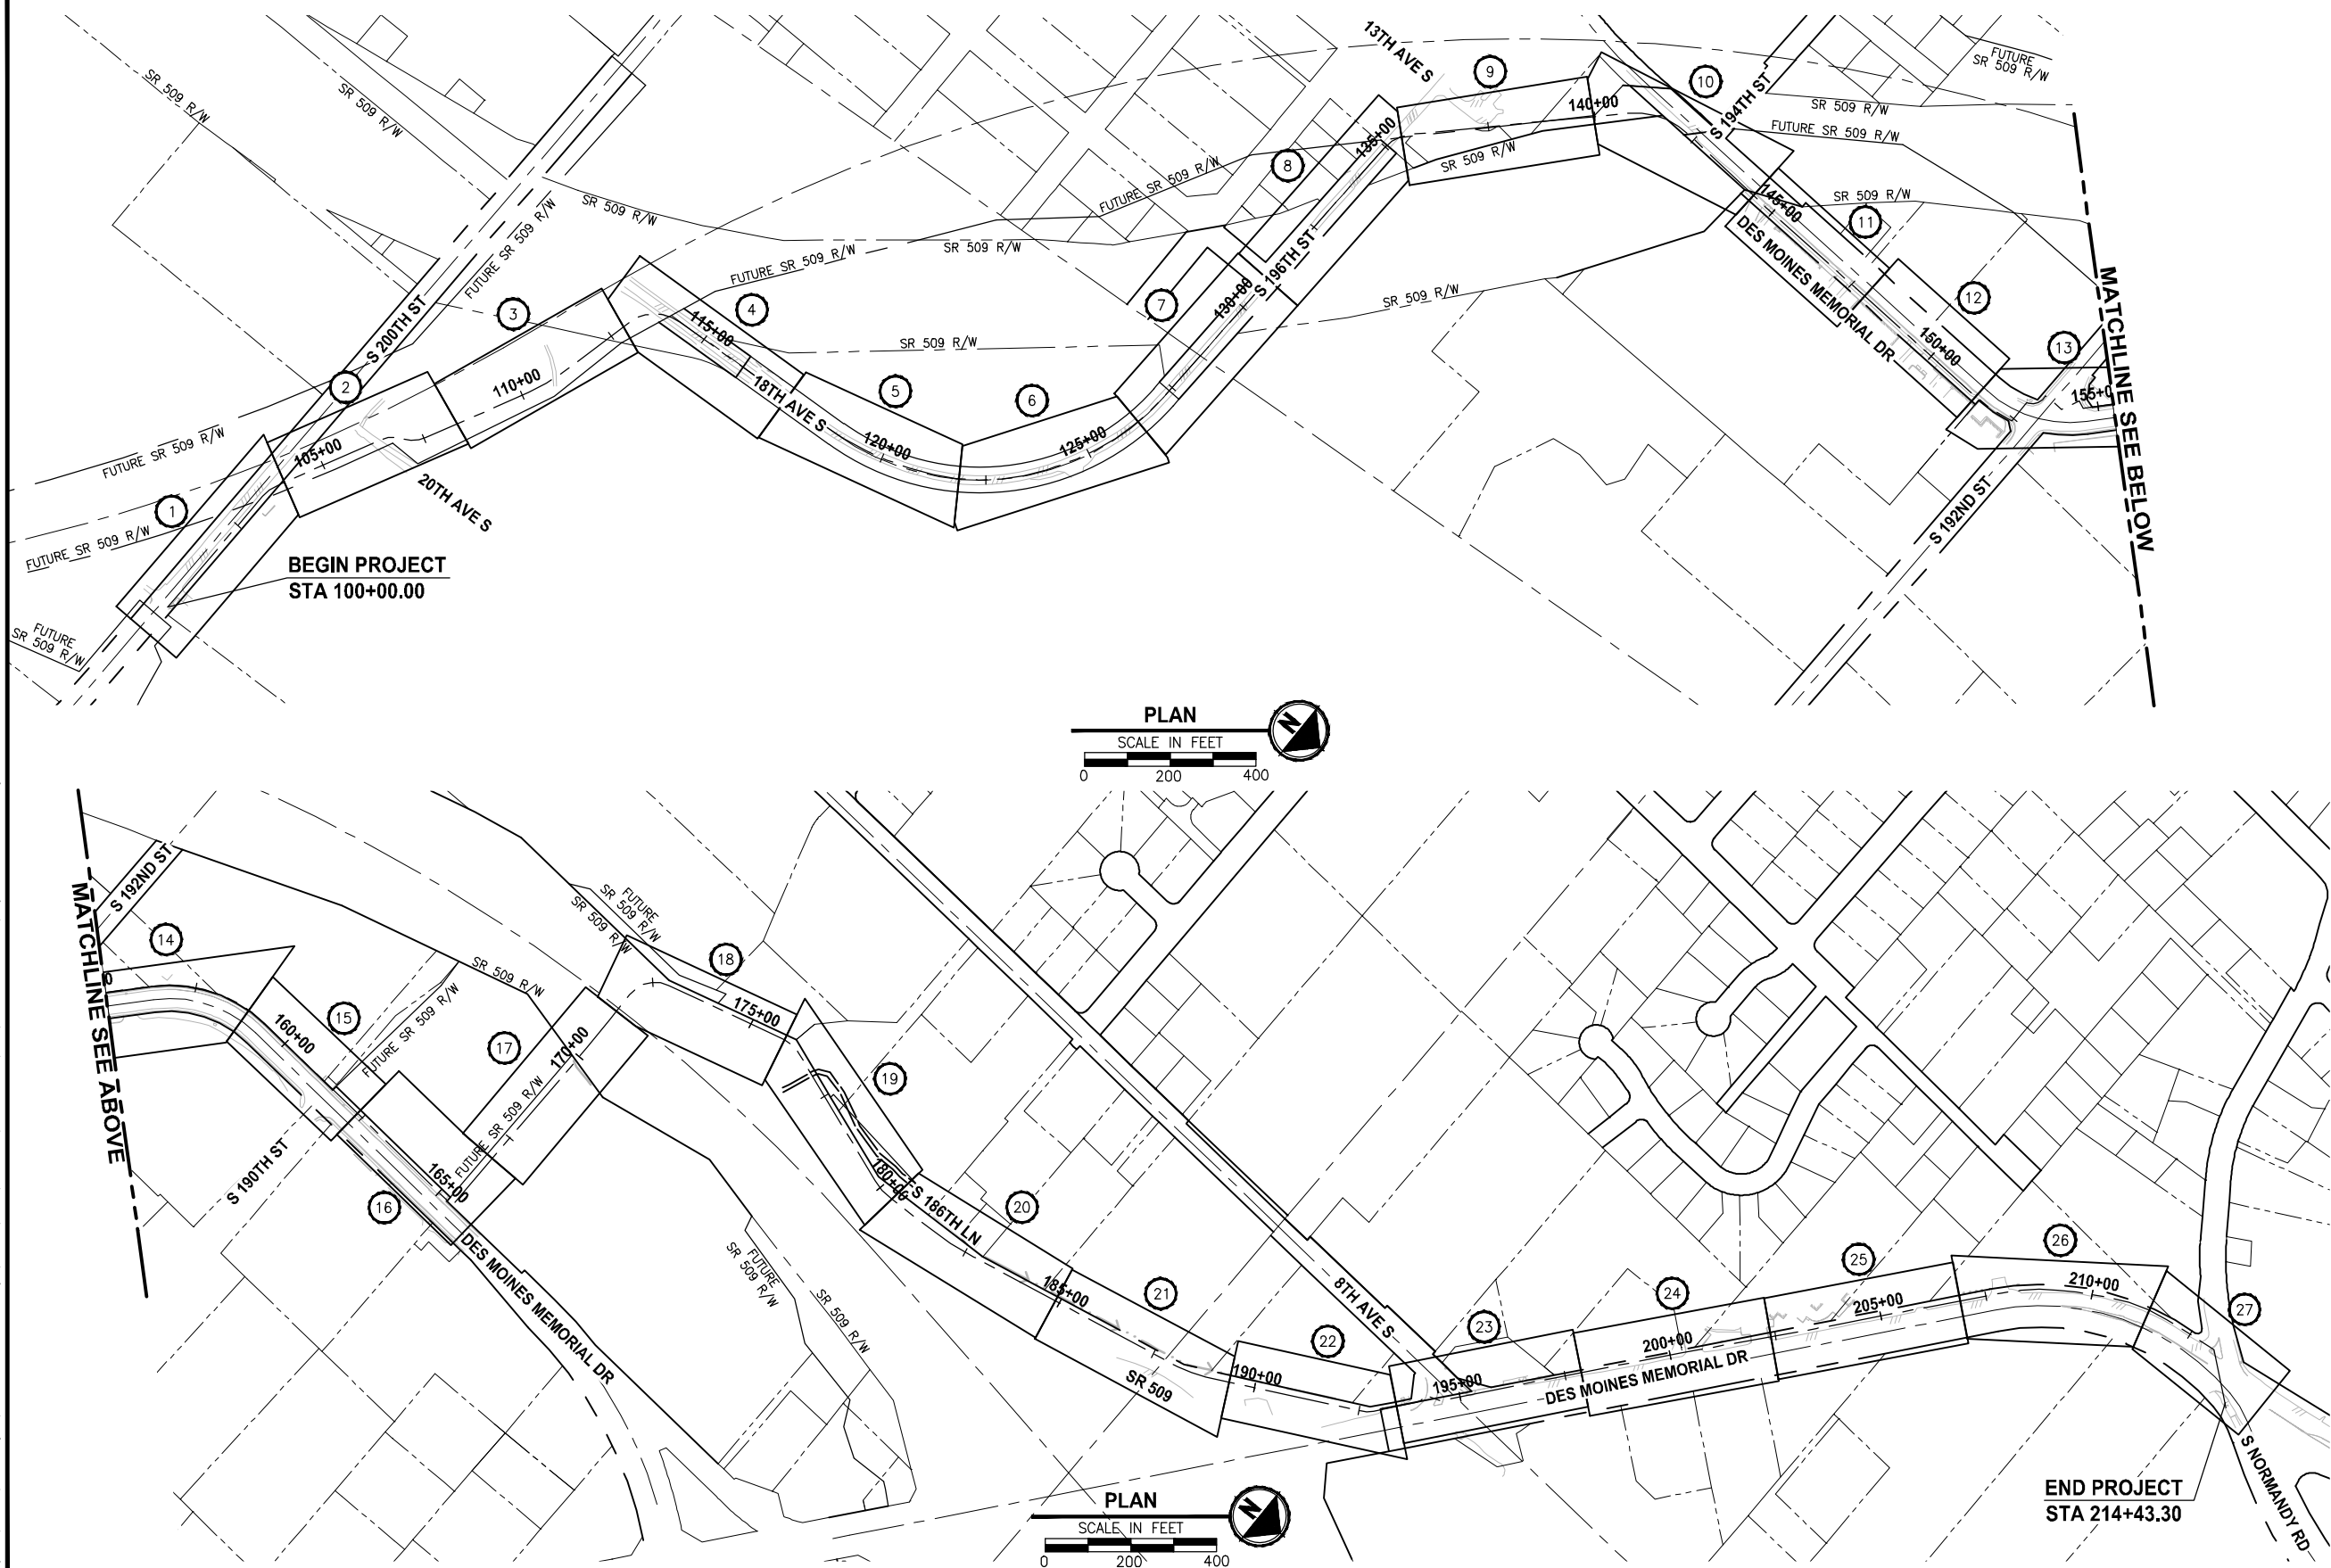

SHEET INDEX TABLE

(X)	PLAN AND PROFILE
1	AL1
2	AL2
3	AL3
4	AL4
5	AL5
6	AL6
7	AL7
8	AL8
9	AL9
10	AL10
11	AL11
12	AL12
13	AL13
14	AL14
15	AL15
16	AL16
17	AL17
18	AL18
19	AL19
20	AL20
21	AL21
22	AL22
23	AL23
24	AL24
25	AL25
26	AL26
27	AL27

REVISIONS	DATE	BY	DESIGNED
			J. JUN
			DRAWN
			B. PURGANAN
			CHECKED
			Y. HO
			APPROVED
			J. DVORAK

ONE INCH AT FULL SCALE. IF NOT, SCALE ACCORDINGLY
FILE NAME
PS1521151P2CT2T2G-03
JOB No.
554-1521-151 P2C T2T200C
DATE
MARCH 2017

PRELIMINARY

Parametrix
ENGINEERING · PLANNING · ENVIRONMENTAL SCIENCES

719 2ND AVENUE, SUITE 200 | SEATTLE, WA 98104
P 206.394.3700
WWW.PARAMETRIX.COM

PROJECT NAME

**LAKE TO SOUND TRAIL
SEGMENT C**


 
 
FROM S 200TH ST TO S NORMANDY ROAD /
DES MOINES MEMORIAL DRIVE INTERSECTION

SHEET INDEX

SHEET NO.
3 OF 33

G3

30 % REVIEW SUBMITTAL
NOT FOR CONSTRUCTION

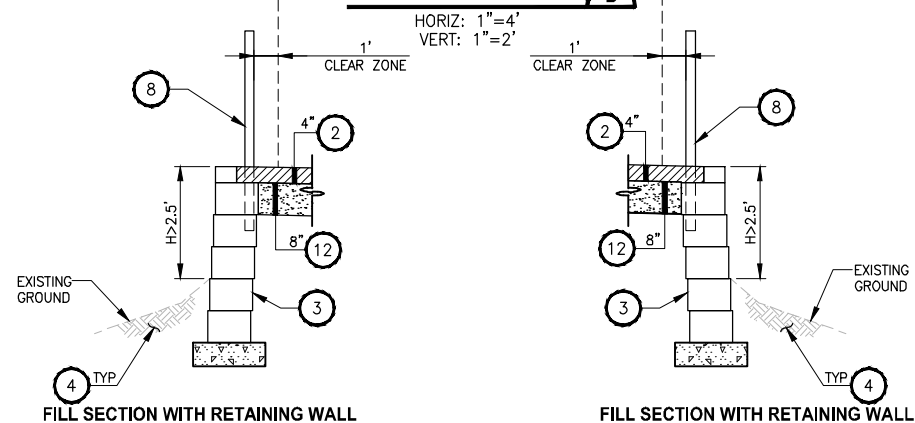

- 1 POROUS HMA CL 1/2 IN. PG 70-22.
- 2 1/2 IN. HMA AGGREGATE (MODIFIED).
- 3 RETAINING WALL. SEE AL PLANS FOR LOCATIONS. SEE X SHEETS FOR WALL PROFILES. SEE SHEET X FOR DETAILS.
- 4 SIDE SLOPES: 4" TOPSOIL TYPE A AND SEEDING AND MULCHING. PLANTER STRIP: 6" TOPSOIL TYPE A AND SEEDING FERTILIZING AND MULCHING.
- 5 SAWCUT.
- 6 SELECT BORROW INCL. HAUL.
- 7 CEMENT CONC. TRAFFIC CURB AND GUTTER PER WSDOT STD PLAN F-10.12-03.
- 8 COATED CHAIN LINK FENCE TYPE 6. SEE AL SHEETS FOR LOCATIONS.
- 9 ELEVATED STRUCTURE.
- 10 PEDESTRIAN RAILING, PER KC FIG. 5-008. SEE AL SHEETS FOR LOCATIONS.
- 11 HMA CL 1/2 IN. PG 64-22.
- 12 PERMEABLE BALLAST.
- 13 CRUSHED SURFACING TOP COURSE.
- 14 CONSTRUCTION GEOTEXTILE FOR SEPARATION MODERATE SURVIVABILITY (SIDE & BOTTOM).
- 15 GRIND AND OVERLAY WITH HMA.
- 16 HMA CL. 3/8" PG 64-22.
- 17 INFILTRATION TRENCH.

▽	REVISIONS	DATE	BY	DESIGNED J. JUN
				DRAWN B. PURGANAN
				CHECKED Y. HO
				APPROVED N. DYORAK

ONE INCH AT FULL SCALE.
IF NOT, SCALE ACCORDINGLY

FILE NAME
PS1521151P2CT2T2CS-01
JOB No.
554-1521-151 P2C T2T200C
DATE
MARCH 2017

PRELIMINARY

Parametrix
ENGINEERING . PLANNING . ENVIRONMENTAL SCIENCES

719 2ND AVENUE, SUITE 200 | SEATTLE, WA 98101
P 206.394.3700
WWW.PARAMETRIX.COM

PROJECT NAME

**LAKE TO SOUND TRAIL
SEGMENT C**

FROM S 200TH ST TO S NORMANDY ROAD /
DES MOINES MEMORIAL DRIVE INTERSECTION


TYPICAL CROSS SECTIONS

SHEET NO.
4 OF 33

CS1


30 % REVIEW SUBMITTAL
NOT FOR CONSTRUCTION

PATH: U:\PSO\Projects\Clients\1521-KingCo\554-1521-151 L2S1-SegC\99Svcs\CADD\Phase 2C\Task 21200C\DWG\ LAYOUT: CS2 PLOTTED BY: purgabut DATE: Thursday, March 09, 2017 4:49:36 PM

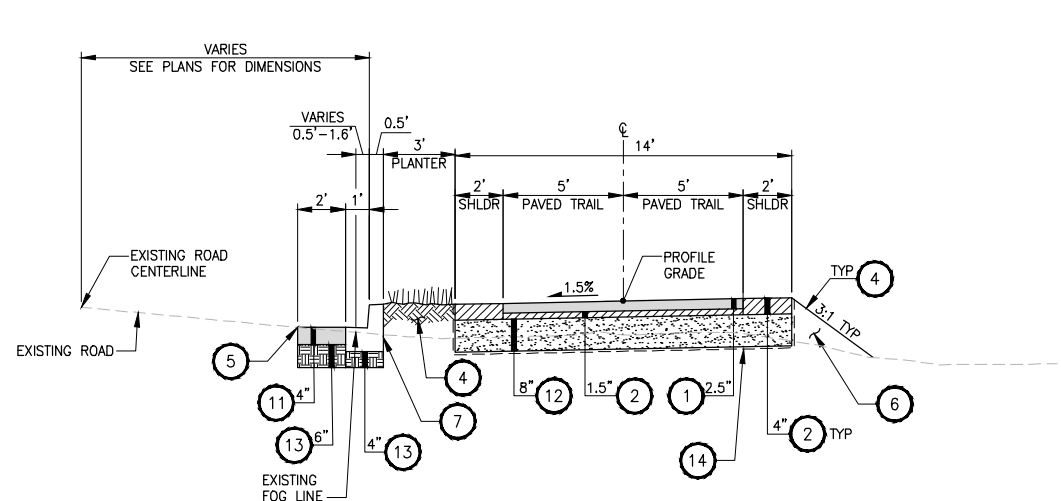


A-LINE STA 147+11 TO STA 150+49
TYPICAL SECTION E

HORIZ: 1"=4'
VERT: 1"=2'

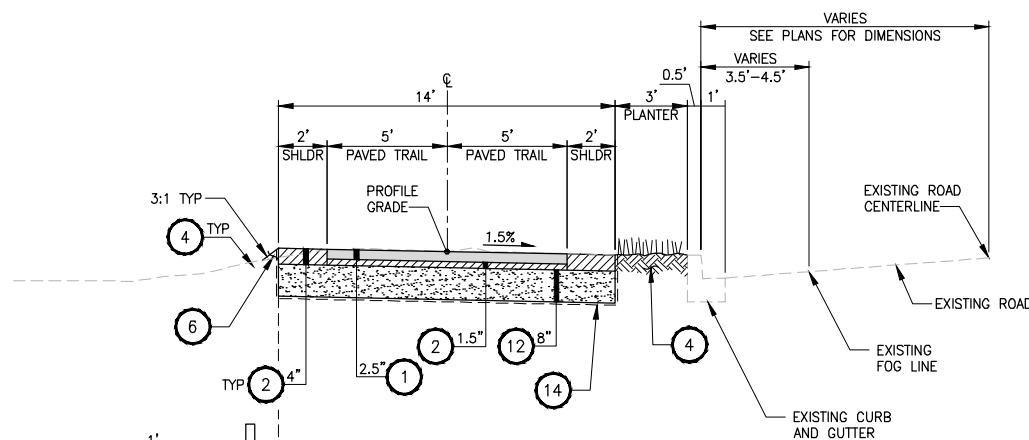


A-LINE STA 161+77 TO STA 165+22
TYPICAL SECTION G

HORIZ: 1"=4'
VERT: 1"=2'

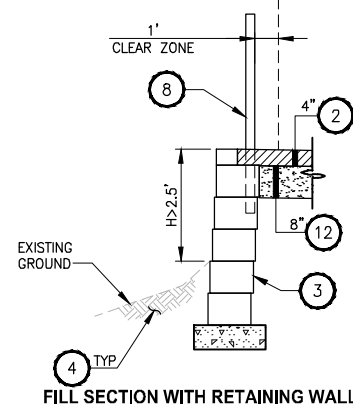


FILL SECTION WITH RETAINING WALL

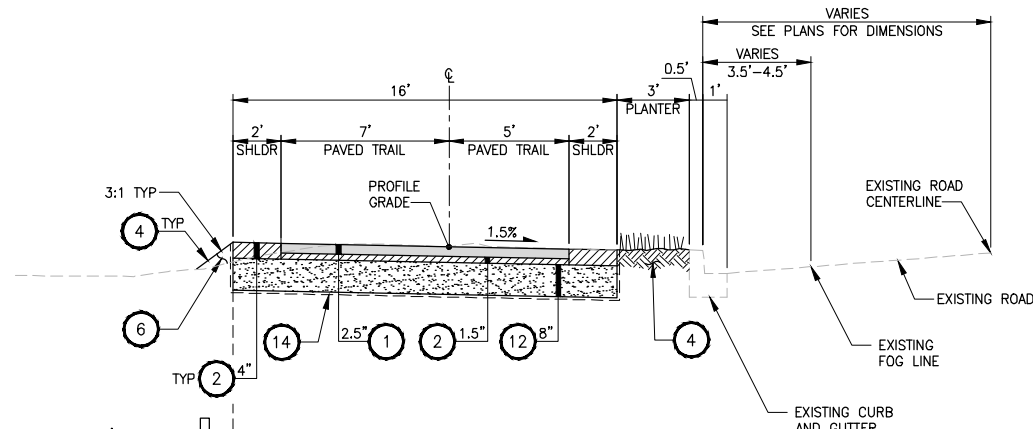


A-LINE STA 154+95 TO STA 161+77
TYPICAL SECTION F


HORIZ: 1"=4'
VERT: 1"=2'

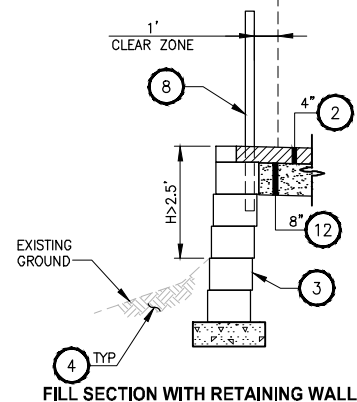

FILL SECTION WITH RETAINING WALL

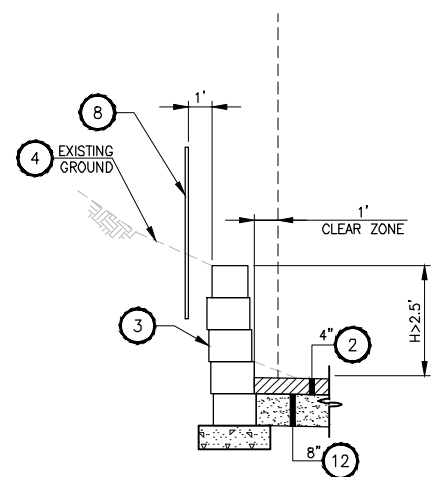

CUT SECTION WITH RETAINING WALL

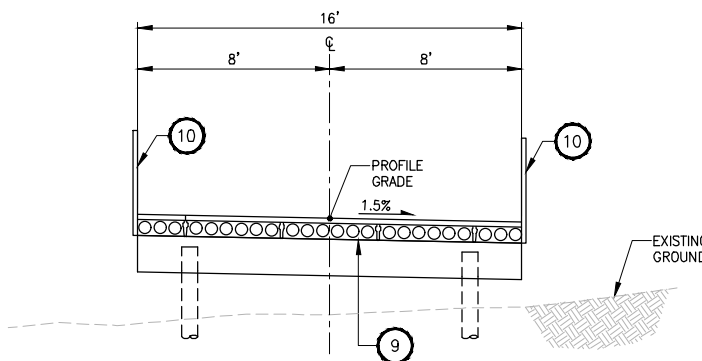

A-LINE STA 165+98 TO STA 167+86
A-LINE STA 169+50 TO STA 171+34
A-LINE STA 174+43 TO STA 178+53
TYPICAL SECTION H

HORIZ: 1"=4'
VERT: 1"=2'

CONSTRUCTION NOTES:

- 1 POROUS HMA CL 1/2 IN. PG 70-22.
- 2 1/2 IN. HMA AGGREGATE (MODIFIED).
- 3 RETAINING WALL, SEE AL PLANS FOR LOCATIONS. SEE X SHEETS FOR WALL PROFILES. SEE SHEET X FOR DETAILS.
- 4 SIDE SLOPES: 4" TOPSOIL TYPE A AND SEEDING AND MULCHING. PLANTER STRIP: 6" TOPSOIL TYPE A AND SEEDING FERTILIZING AND MULCHING.
- 5 SAWCUT.
- 6 SELECT BORROW INCL. HAUL.
- 7 CEMENT CONC. TRAFFIC CURB AND GUTTER PER WSDOT STD PLAN F-10.12-03.
- 8 COATED CHAIN LINK FENCE TYPE 6. SEE AL SHEETS FOR LOCATIONS.
- 9 ELEVATED STRUCTURE.
- 10 PEDESTRIAN RAILING, PER KC FIG. 5-008. SEE AL SHEETS FOR LOCATIONS.
- 11 HMA CL 1/2 IN. PG 64-22.
- 12 PERMEABLE BALLAST.
- 13 CRUSHED SURFACING TOP COURSE.
- 14 CONSTRUCTION GEOTEXTILE FOR SEPARATION MODERATE SURVIVABILITY (SIDE & BOTTOM).
- 15 GRIND AND OVERLAY WITH HMA.
- 16 HMA CL. 3/8" PG 64-22.
- 17 INFILTRATION TRENCH.

30 % REVIEW SUBMITTAL
NOT FOR CONSTRUCTION

REVISIONS	DATE	BY	DESIGNED
			J. JUN
			B. PURGANAN
			Y. HO
			J. DVORAK

ONE INCH AT FULL SCALE. IF NOT, SCALE ACCORDINGLY
FILE NAME PS1521151P2C2T2T2CS-01
JOB No. 554-1521-151 P2C T2T200C
DATE MARCH 2017

PRELIMINARY

Parametrix
ENGINEERING · PLANNING · ENVIRONMENTAL SCIENCES

719 2ND AVENUE, SUITE 200 | SEATTLE, WA 98104
P 206.394.3700
WWW.PARAMETRIX.COM

PROJECT NAME

**LAKE TO SOUND TRAIL
SEGMENT C**









FROM S 200TH ST TO S NORMANDY ROAD /
DES MOINES MEMORIAL DRIVE INTERSECTION

TYPICAL CROSS SECTIONS

SHEET NO.
5 OF 33

CS2

LAYOUT: CS3
PATH: U:\PSO\Projects\Clients\1521-151 L2S1-Seq\99Svcs\CADD\Phase 2C\Task 21200C\DWG\ PLOTTED BY: purgabut DATE: Friday, March 10, 2017 10:31:39 AM

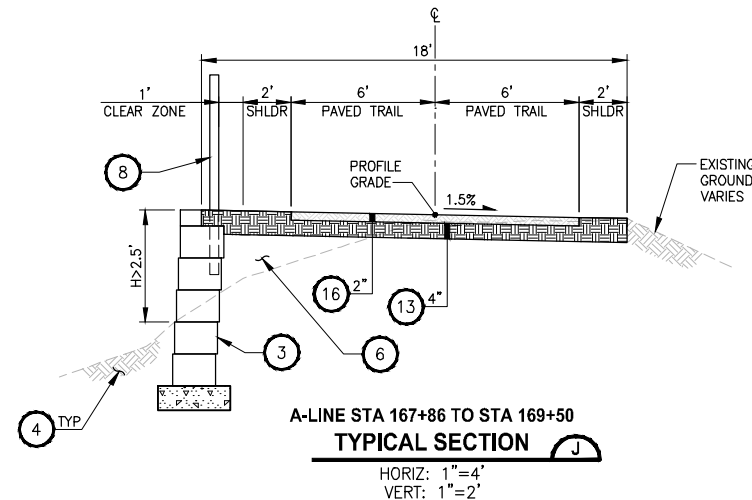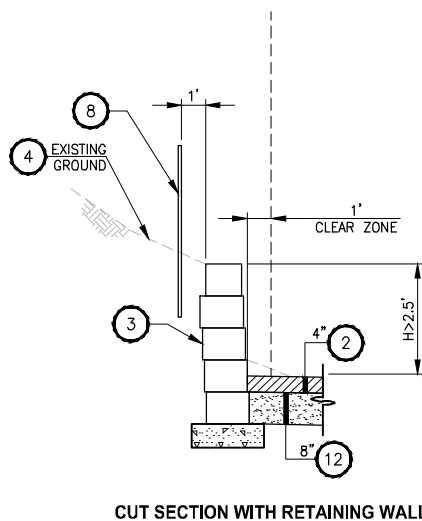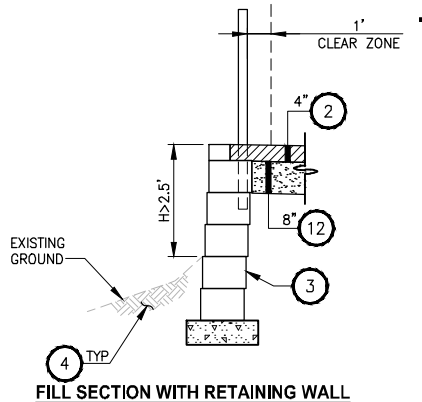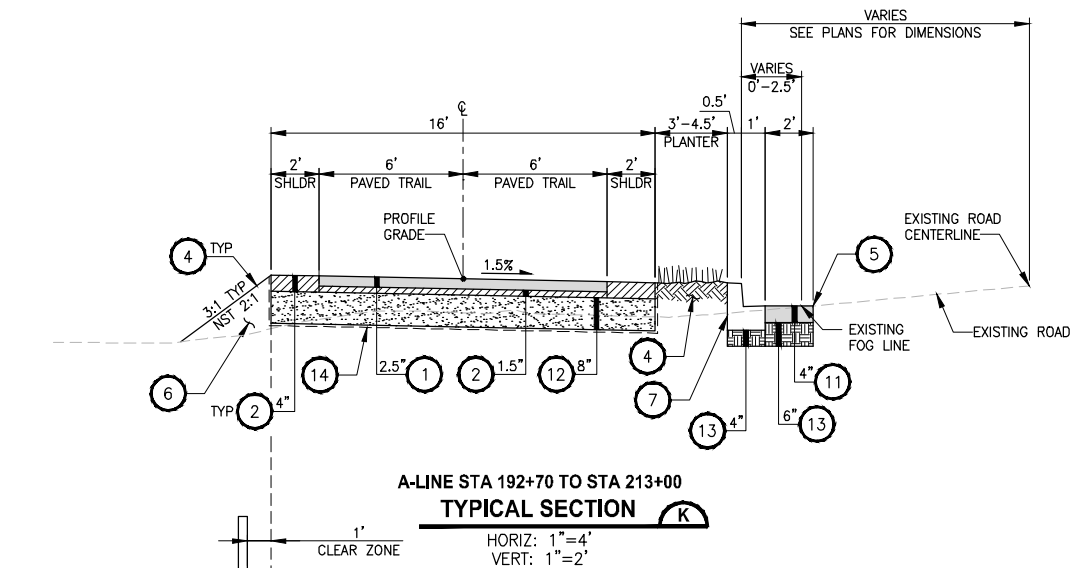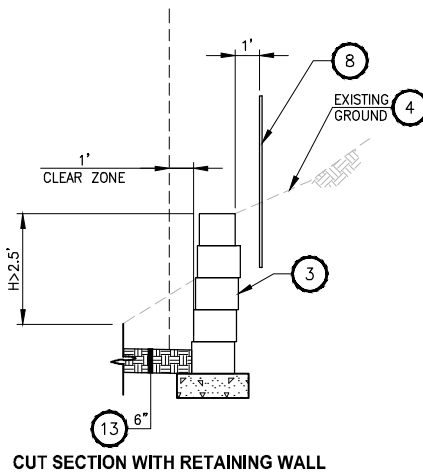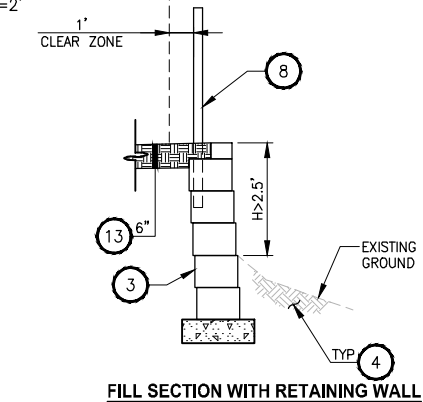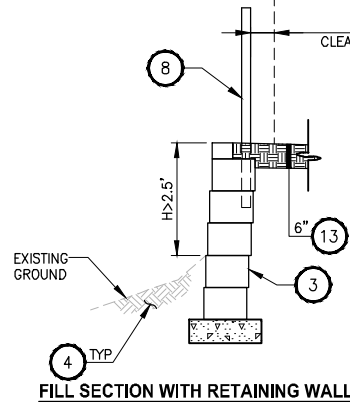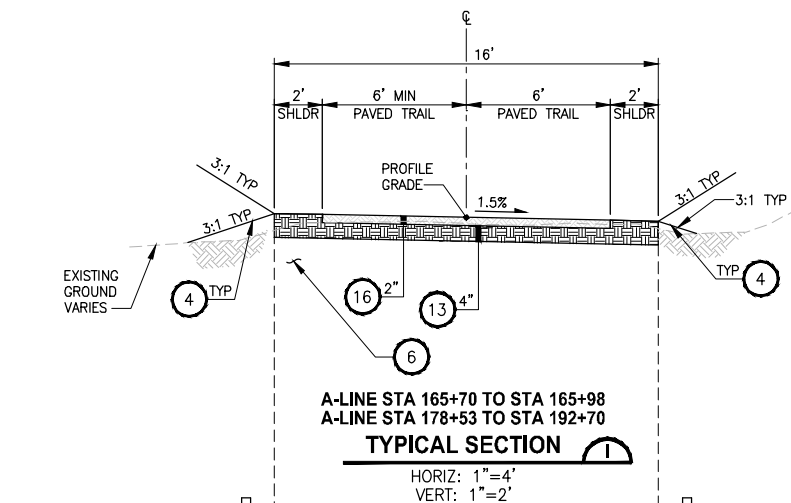

CONSTRUCTION NOTES:

- 1 POROUS HMA CL 1/2 IN. PG 70-22.
- 2 1/2 IN. HMA AGGREGATE (MODIFIED).
- 3 RETAINING WALL, SEE AL PLANS FOR LOCATIONS. SEE X SHEETS FOR WALL PROFILES. SEE SHEET X FOR DETAILS.
- 4 SIDE SLOPES: 4" TOPSOIL TYPE A AND SEEDING AND MULCHING. PLANTER STRIP: 6" TOPSOIL TYPE A AND SEEDING FERTILIZING AND MULCHING.
- 5 SAWCUT.
- 6 SELECT BORROW INCL. HAUL.
- 7 CEMENT CONC. TRAFFIC CURB AND GUTTER PER WSDOT STD PLAN F-10.12-03.
- 8 COATED CHAIN LINK FENCE TYPE 6. SEE AL SHEETS FOR LOCATIONS.
- 9 ELEVATED STRUCTURE.
- 10 PEDESTRIAN RAILING, PER KC FIG. 5-008. SEE AL SHEETS FOR LOCATIONS.
- 11 HMA CL 1/2 IN. PG 64-22.
- 12 PERMEABLE BALLAST.
- 13 CRUSHED SURFACING TOP COURSE.
- 14 CONSTRUCTION GEOTEXTILE FOR SEPARATION MODERATE SURVIVABILITY (SIDE & BOTTOM).
- 15 GRIND AND OVERLAY WITH HMA.
- 16 HMA CL 3/8" PG 64-22.
- 17 INFILTRATION TRENCH.

30 % REVIEW SUBMITTAL
NOT FOR CONSTRUCTION

REVISIONS	DATE	BY	DESIGNED
			J. JUN
			DRAWN
			B. PURGANAN
			CHECKED
			Y. HO
			APPROVED
			J. DVORAK

ONE INCH AT FULL SCALE. IF NOT, SCALE ACCORDINGLY
FILE NAME
PS1521151P2CT2T2CS-01
JOB No.
554-1521-151 P2C T2T200C
DATE
MARCH 2017

PRELIMINARY


 

Parametrix ENGINEERING · PLANNING · ENVIRONMENTAL SCIENCES
719 2ND AVENUE, SUITE 200 SEATTLE, WA 98104 P 206.394.3700 WWW.PARAMETRIX.COM

PROJECT NAME
LAKE TO SOUND TRAIL SEGMENT C
FROM S 200TH ST TO S NORMANDY ROAD / DES MOINES MEMORIAL DRIVE INTERSECTION

TYPICAL CROSS SECTIONS

SHEET NO. 6 OF 33
CS3

PATH: U:\PSO\Projects\Clients\1521-KingCo\1521-151 L251-SegC\95Sves\CA00\Phase 2C\Task 21200C\DWG PLOTTED BY: purgaut DATE: Friday, March 10, 2017 1:09:07 PM LAYOUT: AL1

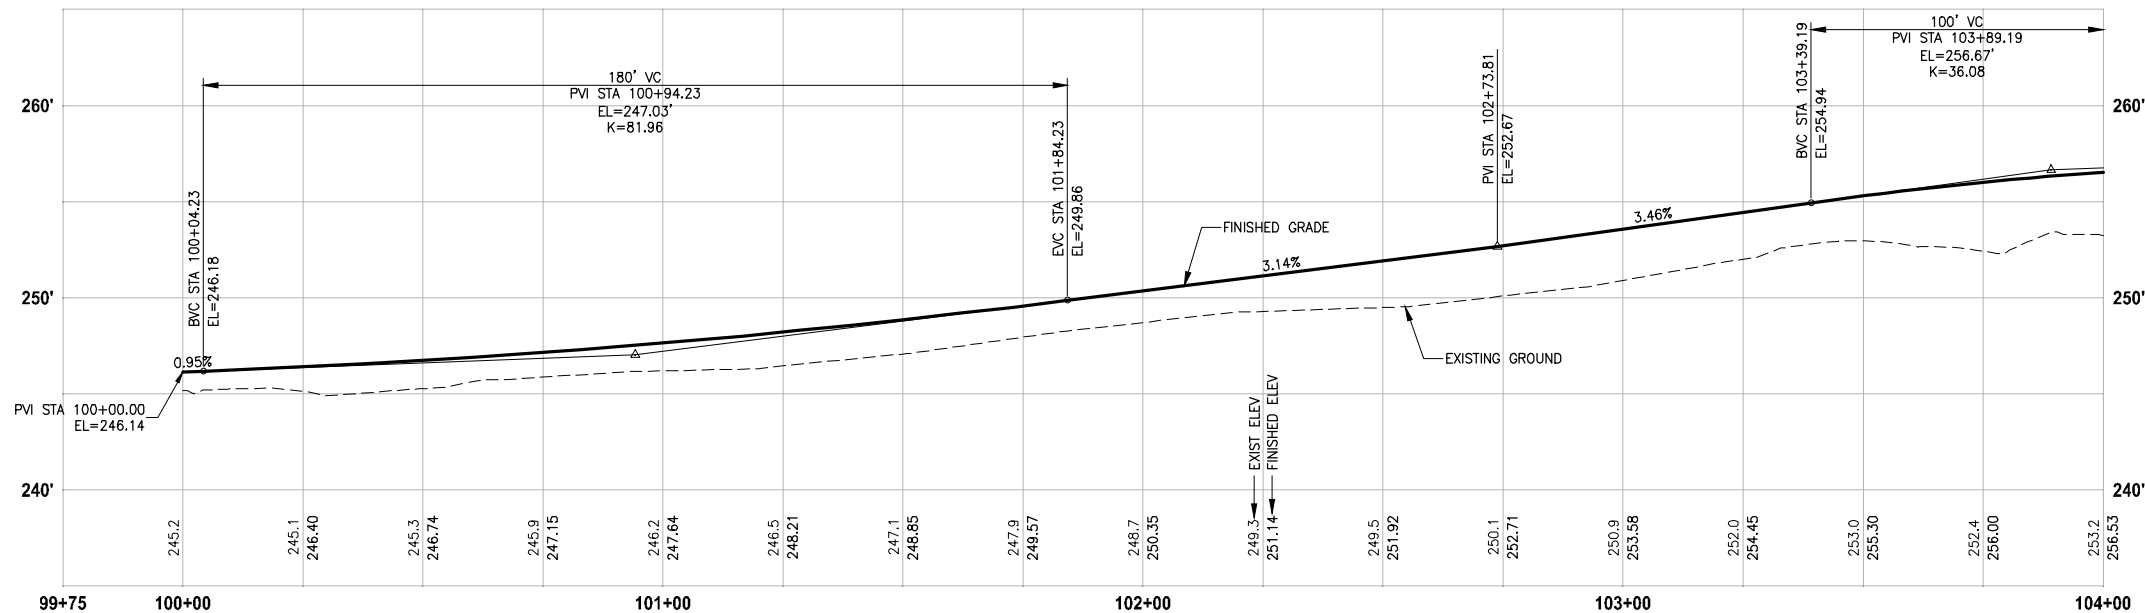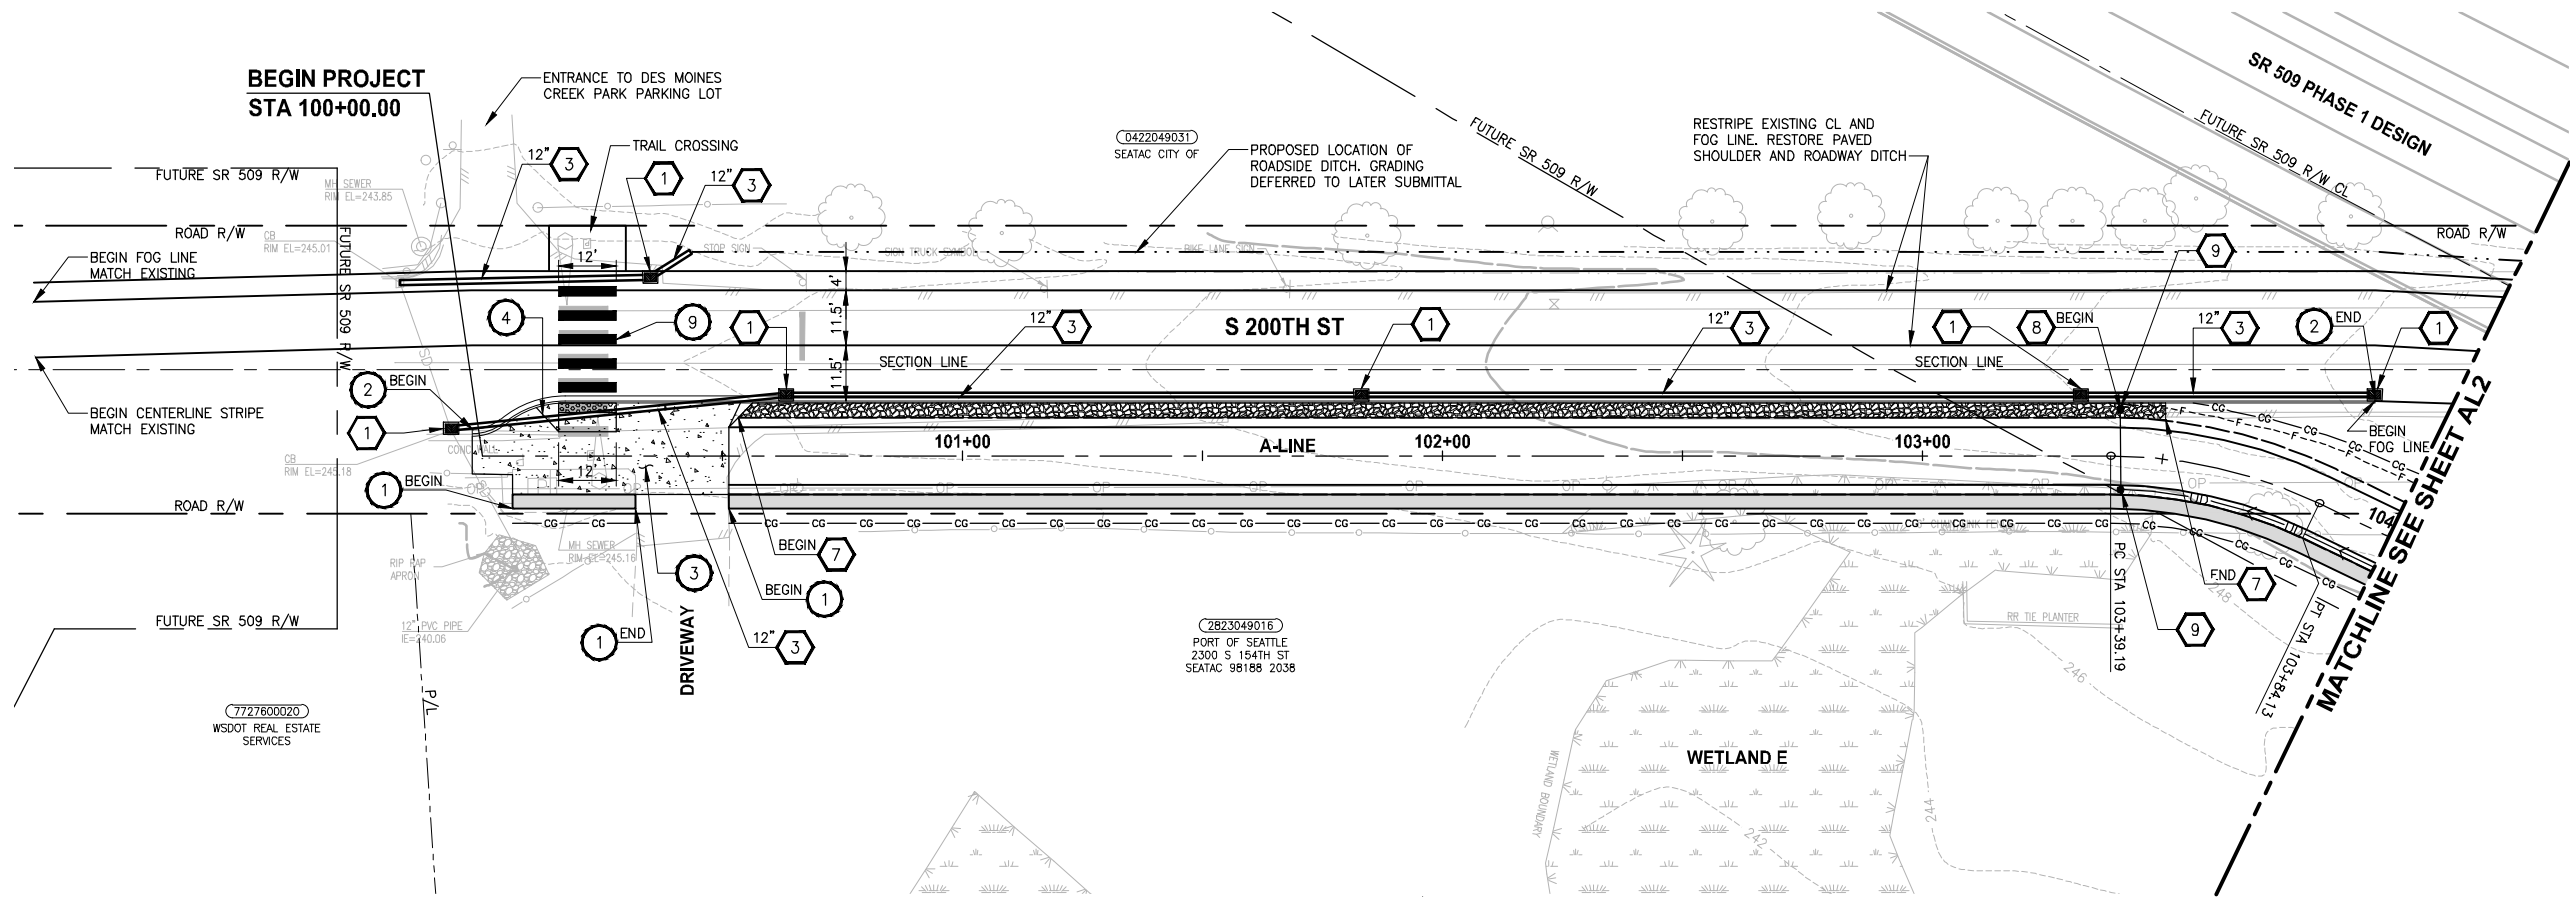

PROFILE

HORIZ: 1"=20'
VERT: 1"=5'

CIVIL CONSTRUCTION NOTES:

1. INSTALL RETAINING WALL.
2. CEMENT CONCRETE CURB AND GUTTER PER WSDOT STD PLAN F-10.12-03.
3. CEMENT CONCRETE DRIVEWAY ENTRANCE TYPE 3 PER WSDOT STD PLAN F-80.10-03.
4. PERPENDICULAR CURB RAMP PER WSDOT STD PLAN F-40.15-03.
5. MOUNTABLE CEMENT CONCRETE TRAFFIC CURB PER WSDOT STD PLAN F-10.12-03.
6. RAISED TRAFFIC ISLAND.
7. ELEVATED STRUCTURE.
8. BUS LANDING PAD.
9. CROSSWALK PER WSDOT STD PLAN M-15.10-01.
10. ASPHALT RAMP TRANSITION TO EXISTING GROUND.

STORMWATER CONSTRUCTION NOTES:

1. CATCH BASIN TYPE 1 PER WSDOT STD PLAN B-5.20-01.
2. CATCH BASIN TYPE 2 PER WSDOT STD PLAN B-10.20-01.
3. SCHEDULE A STORM SEWER PIPE.
4. SCHEDULE A CULVERT PIPE.
5. ADJUST MANHOLE/CATCH BASIN.
6. ADJUST MANHOLE AND REPLACE WITH SLIP RESISTANT LIDS.
7. INFILTRATION TRENCH.
8. UNDERDRAIN TRENCH.
9. UNDERDRAIN TRENCH CLEANOUT.
10. CONCRETE COLLAR FOR CULVERT CONNECTION.

STORMWATER GENERAL NOTES:

1. POTENTIAL LOCATIONS AND APPROXIMATE SIZES FOR STORMWATER PONDS A AND B FOOTPRINTS ARE SHOWN FOR REVIEW. GRADING AND DETAILED CONVEYANCE PIPES WILL BE DESIGNED IN LATER SUBMITTAL.
2. STORMWATER CONVEYANCE SYSTEMS DEPICTED IN THE DRAFT 30 PERCENT PLANS ARE FOR PRELIMINARY DESIGN PURPOSES. STORMWATER CONVEYANCE SYSTEM DESIGN MAY CHANGE DURING FINAL DESIGN IF CONFLICTS WITH EXISTING UTILITIES.
3. PERMEABLE PAVEMENT (POROUS HMA) IS PROPOSED FOR THE PROPOSED TRAIL SURFACE FOR ALL AREAS WHERE INFILTRATION IS LIKELY TO BE FEASIBLE. FURTHER GEOTECHNICAL INVESTIGATION IS REQUIRED TO CONFIRM WHETHER OR NOT THE UNDERLYING SOILS HAVE SUITABLE INFILTRATION RATES TO SUPPORT POROUS HMA. FOR THE DRAFT 30 PERCENT DESIGN PLANS, AREAS ADJACENT TO WETLANDS A, G AND H ARE PROPOSED TO USE CONVENTIONAL HMA UNTIL FURTHER GEOTECHNICAL INVESTIGATION IS PERFORMED TO CONFIRM IF UNDERLYING SOIL TYPES AND GROUNDWATER ELEVATIONS ARE SUITABLE TO INSTALL PERMEABLE PAVEMENT.

LEGEND:

	IMPERVIOUS HMA TRAIL PAVEMENT
	POROUS HMA TRAIL PAVEMENT
	BOARDWALK

30 % REVIEW SUBMITTAL
NOT FOR CONSTRUCTION

REVISIONS	DATE	BY	DESIGNED
			J. JUN
			B. PURGANAN
			Y. HO
			J. DVORAK

ONE INCH AT FULL SCALE. IF NOT, SCALE ACCORDINGLY
FILE NAME PS1521151P2C2T2AL-01
JOB No. 554-1521-151 P2C T2T200C
DATE MARCH 2017

PRELIMINARY



Parametrix ENGINEERING · PLANNING · ENVIRONMENTAL SCIENCES
719 2ND AVENUE, SUITE 200 SEATTLE, WA 98104 P 206.394.3700 WWW.PARAMETRIX.COM

PROJECT NAME
LAKE TO SOUND TRAIL SEGMENT C
FROM S 200TH ST TO S NORMANDY ROAD / DES MOINES MEMORIAL DRIVE INTERSECTION

PLAN AND PROFILE

SHEET NO. 7 OF 33
AL1

PATH: U:\P50\Projects\Clients\1521-KingCo\54-1521-151 L2S1-SegC\955\Drawings\CAADD\Phase 2C\Task 21200C.DWG PLOTTED BY: purganbut DATE: Friday, March 10, 2017 2:09:04 PM LAYOUT: AL2

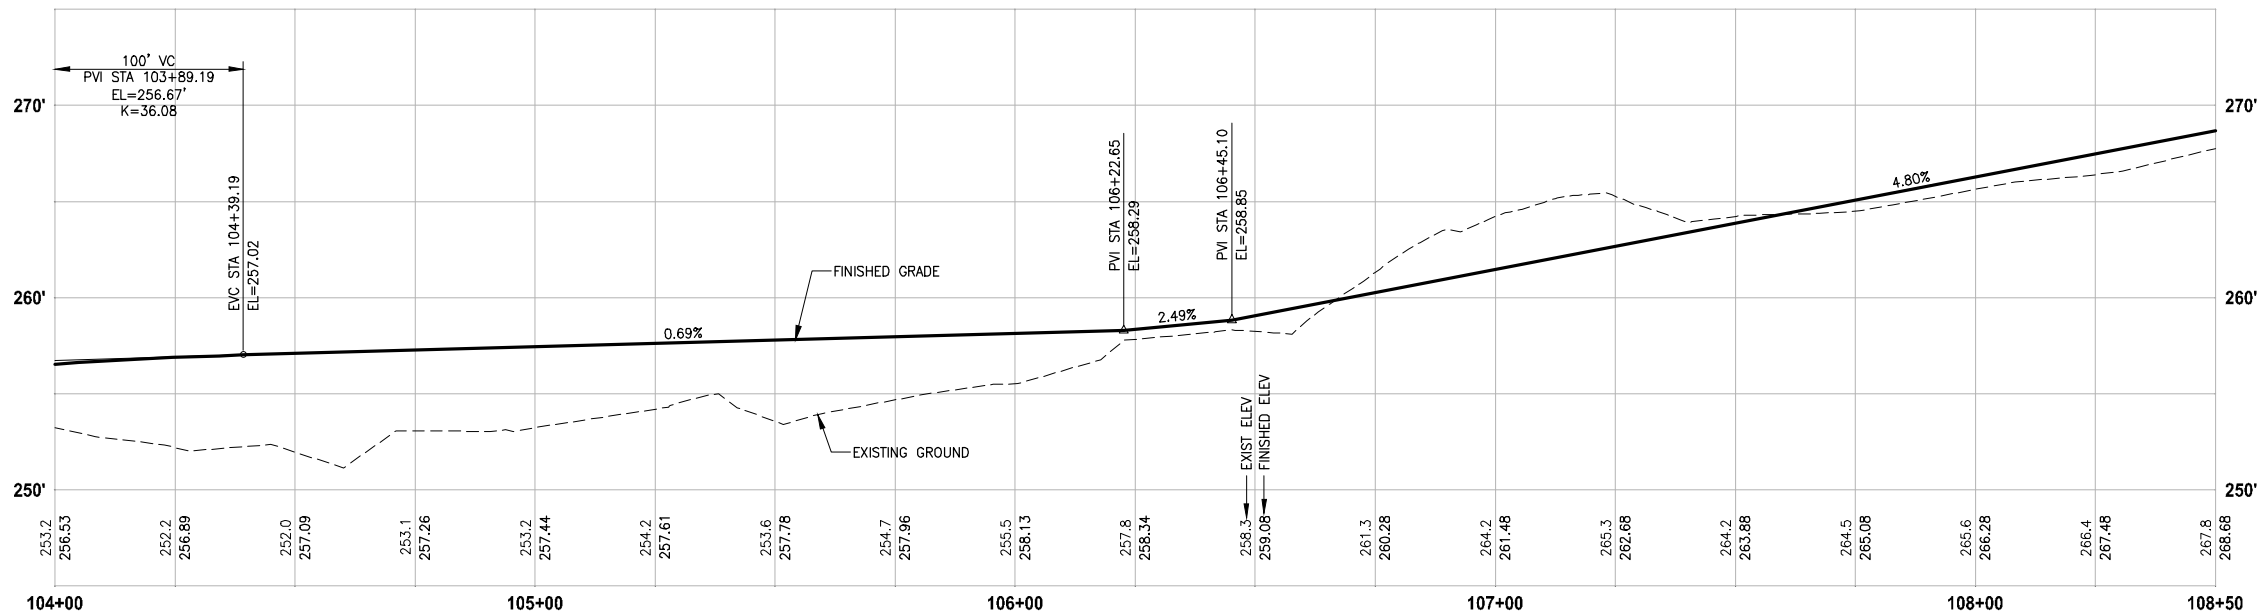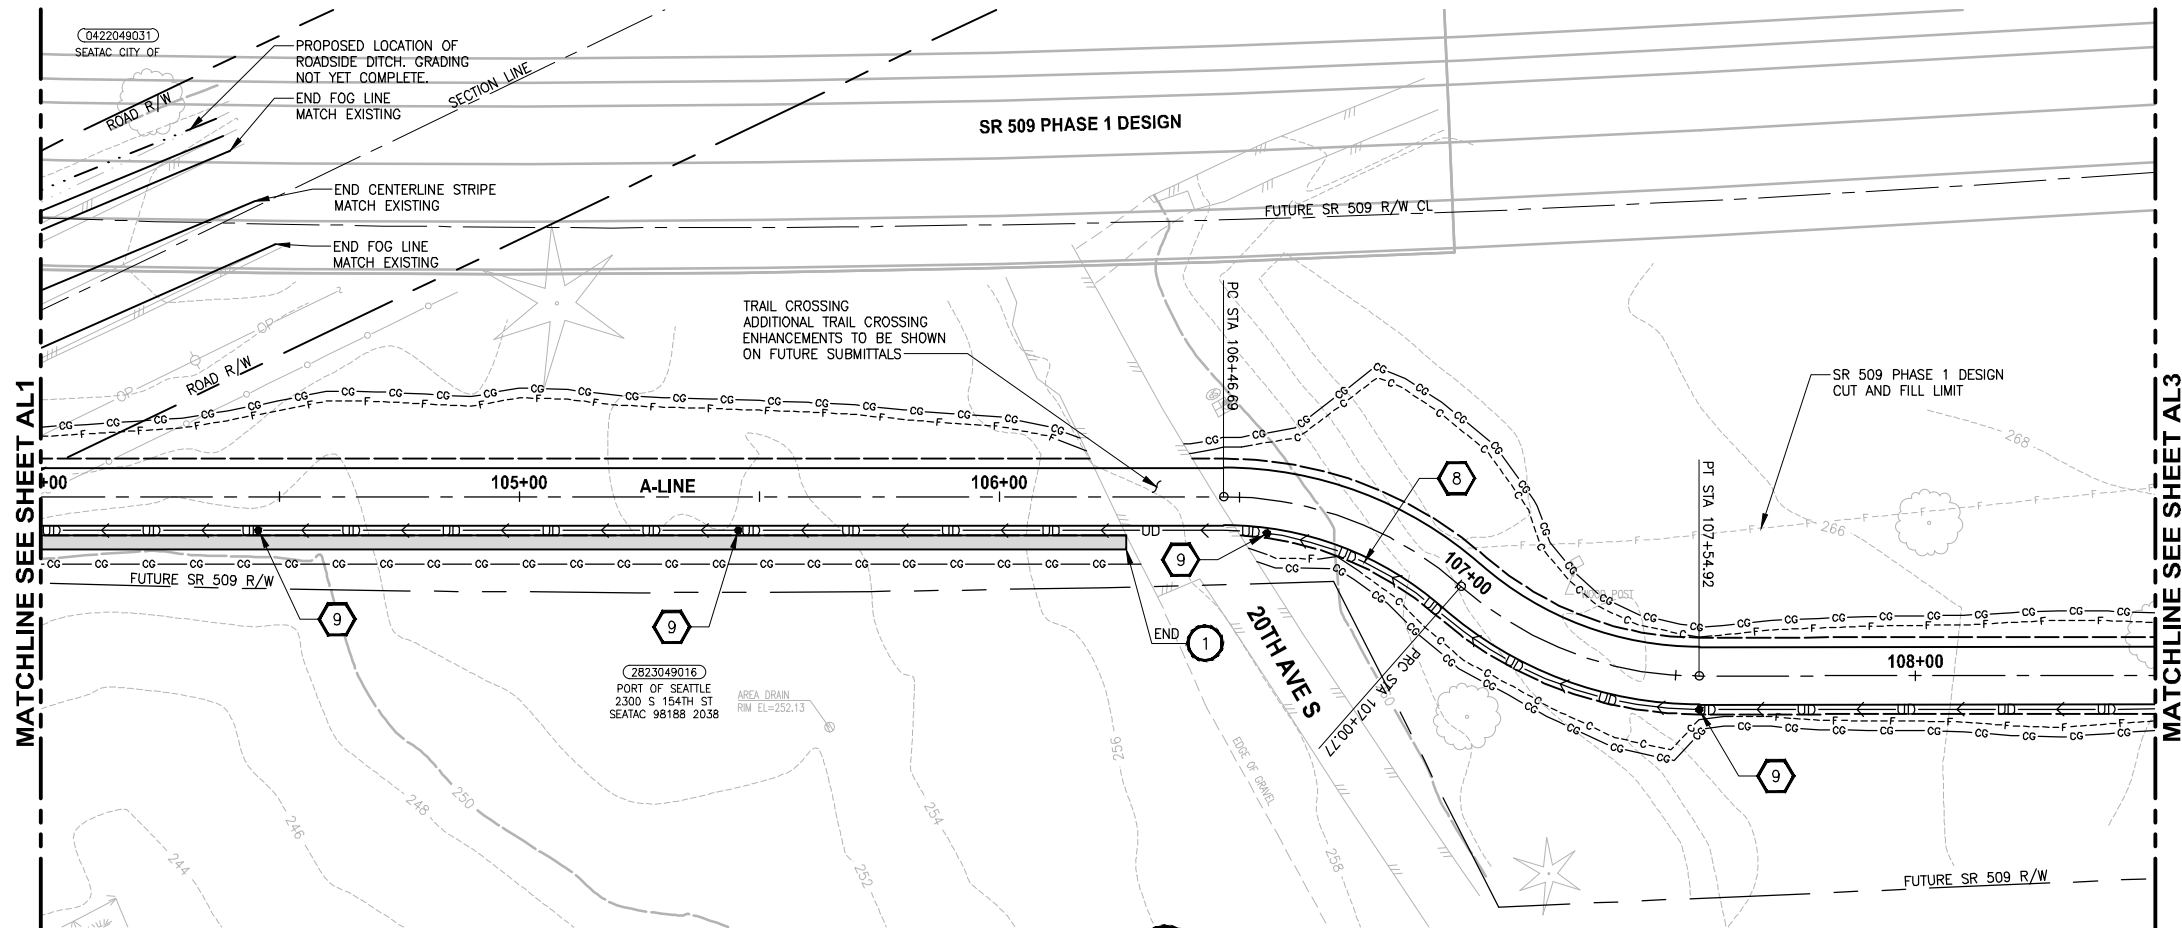

PROFILE

HORIZ: 1"=20'
VERT: 1"=5'

CIVIL CONSTRUCTION NOTES:

1. INSTALL RETAINING WALL.
2. CEMENT CONCRETE CURB AND GUTTER PER WSDOT STD PLAN F-10.12-03.
3. CEMENT CONCRETE DRIVEWAY ENTRANCE TYPE 3 PER WSDOT STD PLAN F-80.10-03.
4. PERPENDICULAR CURB RAMP PER WSDOT STD PLAN F-40.15-03.
5. MOUNTABLE CEMENT CONCRETE TRAFFIC CURB PER WSDOT STD PLAN F-10.12-03.
6. RAISED TRAFFIC ISLAND.
7. ELEVATED STRUCTURE.
8. BUS LANDING PAD.
9. CROSSWALK PER WSDOT STD PLAN M-15.10-01.
10. ASPHALT RAMP TRANSITION TO EXISTING GROUND.

STORMWATER CONSTRUCTION NOTES:

1. CATCH BASIN TYPE 1 PER WSDOT STD PLAN B-5.20-01.
2. CATCH BASIN TYPE 2 PER WSDOT STD PLAN B-10.20-01.
3. SCHEDULE A STORM SEWER PIPE.
4. SCHEDULE A CULVERT PIPE.
5. ADJUST MANHOLE/CATCH BASIN.
6. ADJUST MANHOLE AND REPLACE WITH SLIP RESISTANT LIDS.
7. INFILTRATION TRENCH.
8. UNDERDRAIN TRENCH.
9. UNDERDRAIN TRENCH CLEANOUT.
10. CONCRETE COLLAR FOR CULVERT CONNECTION.

STORMWATER GENERAL NOTES:

1. POTENTIAL LOCATIONS AND APPROXIMATE SIZES FOR STORMWATER PONDS A AND B FOOTPRINTS ARE SHOWN FOR REVIEW. GRADING AND DETAILED CONVEYANCE PIPES WILL BE DESIGNED IN LATER SUBMITTAL.
2. STORMWATER CONVEYANCE SYSTEMS DEPICTED IN THE DRAFT 30 PERCENT PLANS ARE FOR PRELIMINARY DESIGN PURPOSES. STORMWATER CONVEYANCE SYSTEM DESIGN MAY CHANGE DURING FINAL DESIGN IF CONFLICTS WITH EXISTING UTILITIES.
3. PERMEABLE PAVEMENT (POROUS HMA) IS PROPOSED FOR THE PROPOSED TRAIL SURFACE FOR ALL AREAS WHERE INFILTRATION IS LIKELY TO BE FEASIBLE. FURTHER GEOTECHNICAL INVESTIGATION IS REQUIRED TO CONFIRM WHETHER OR NOT THE UNDERLYING SOILS HAVE SUITABLE INFILTRATION RATES TO SUPPORT POROUS HMA. FOR THE DRAFT 30 PERCENT DESIGN PLANS, AREAS ADJACENT TO WETLANDS A, G AND H ARE PROPOSED TO USE CONVENTIONAL HMA UNTIL FURTHER GEOTECHNICAL INVESTIGATION IS PERFORMED TO CONFIRM IF UNDERLYING SOIL TYPES AND GROUNDWATER ELEVATIONS ARE SUITABLE TO INSTALL PERMEABLE PAVEMENT.

LEGEND:

	IMPERVIOUS HMA TRAIL PAVEMENT
	POROUS HMA TRAIL PAVEMENT
	BOARDWALK

30 % REVIEW SUBMITTAL
NOT FOR CONSTRUCTION

REVISIONS	DATE	BY	DESIGNED
			J. JUN
			B. PURGANAN
			Y. HO
			J. DVORAK

ONE INCH AT FULL SCALE. IF NOT, SCALE ACCORDINGLY
FILE NAME PS1521151P2C2T2T2AL-01
JOB No. 54-1521-151 P2C T2T200C
DATE MARCH 2017

Parametrix
ENGINEERING · PLANNING · ENVIRONMENTAL SCIENCES

719 2ND AVENUE, SUITE 200 | SEATTLE, WA 98104
P 206.394.3700
WWW.PARAMETRIX.COM

PROJECT NAME

LAKE TO SOUND TRAIL
SEGMENT C



FROM S 200TH ST TO S NORMANDY ROAD /
DES MOINES MEMORIAL DRIVE INTERSECTION

PLAN AND PROFILE

SHEET NO.
8 OF 33

AL2

PATH: U:\P50\Projects\Clients\1521-KingCo\554-1521-151 L2S1-SegC\955\cs\CA00\Phase 2C\Task 21200C.DWG PLOTTED BY: purgabit DATE: Friday, March 10, 2017 1:07:38 PM LAYOUT: AL3

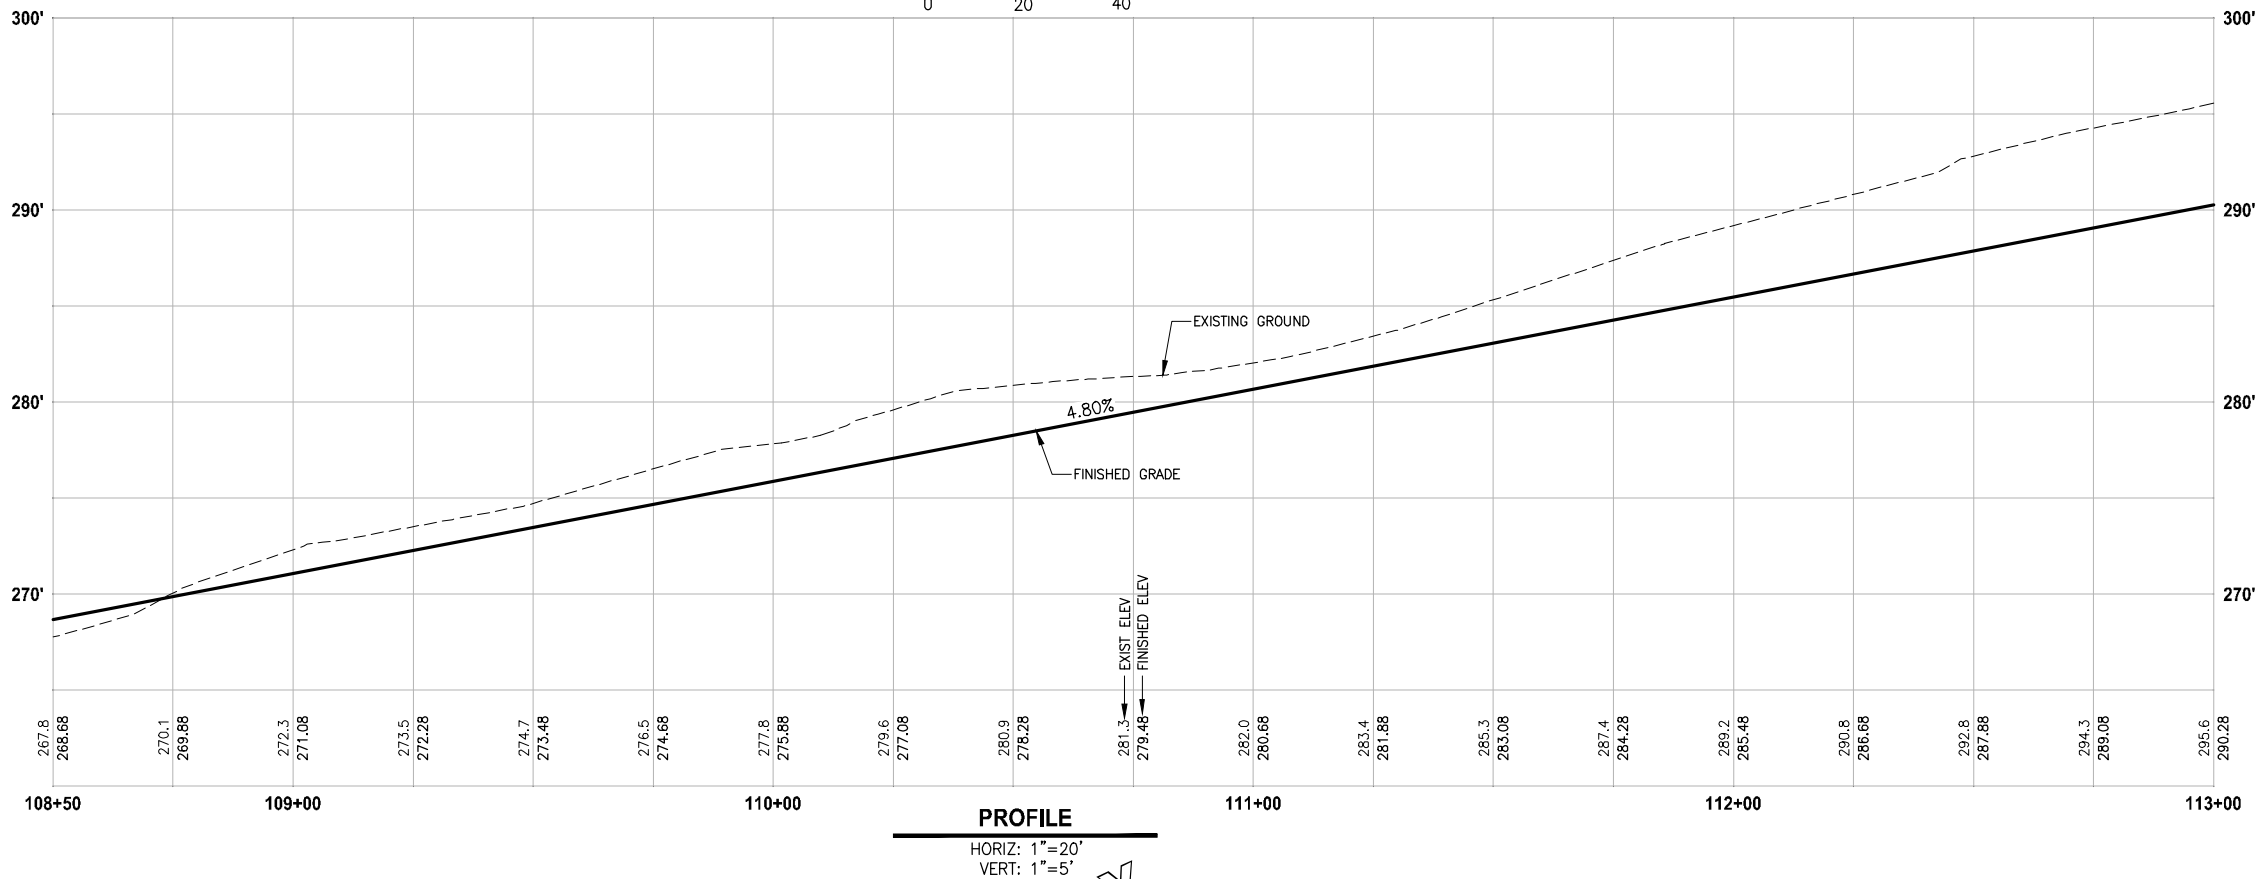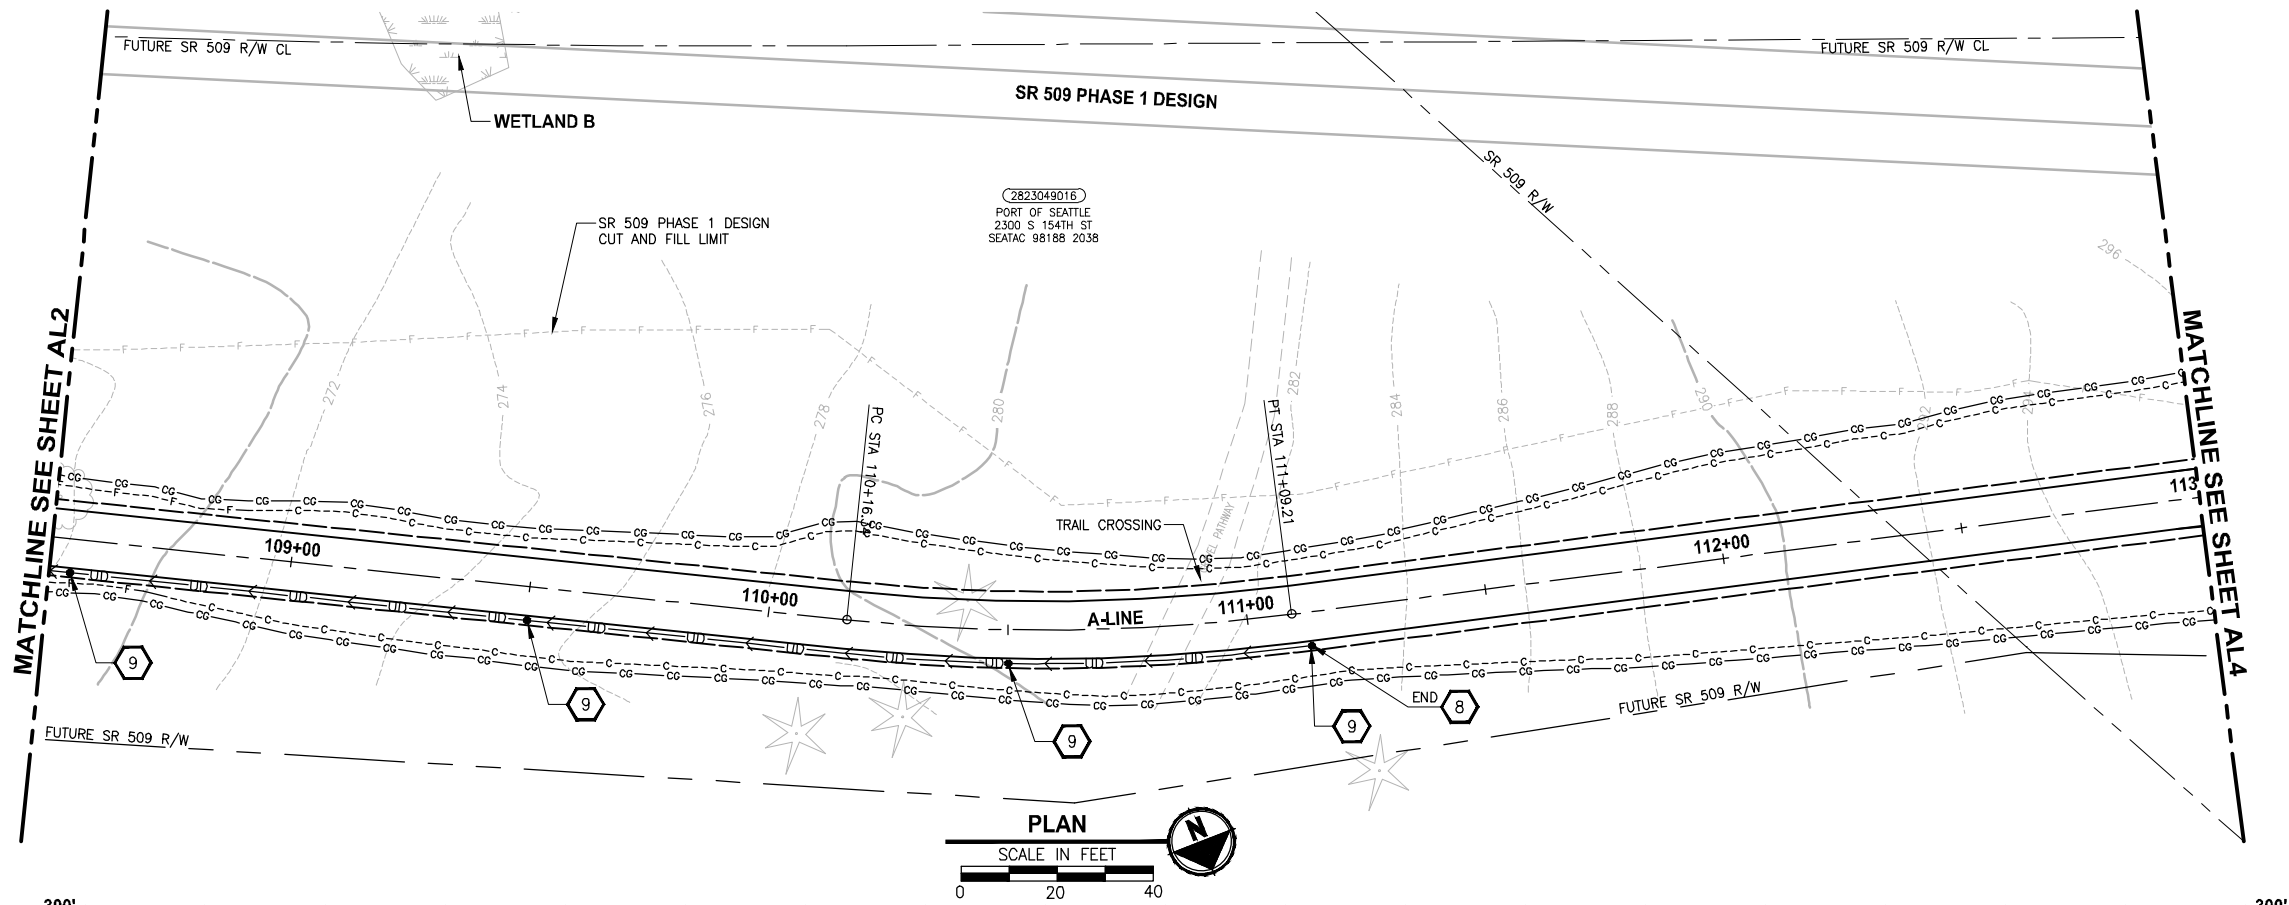

CIVIL CONSTRUCTION NOTES:

1. INSTALL RETAINING WALL.
2. CEMENT CONCRETE CURB AND GUTTER PER WSDOT STD PLAN F-10.12-03.
3. CEMENT CONCRETE DRIVEWAY ENTRANCE TYPE 3 PER WSDOT STD PLAN F-80.10-03.
4. PERPENDICULAR CURB RAMP PER WSDOT STD PLAN F-40.15-03.
5. MOUNTABLE CEMENT CONCRETE TRAFFIC CURB PER WSDOT STD PLAN F-10.12-03.
6. RAISED TRAFFIC ISLAND.
7. ELEVATED STRUCTURE.
8. BUS LANDING PAD.
9. CROSSWALK PER WSDOT STD PLAN M-15.10-01.
10. ASPHALT RAMP TRANSITION TO EXISTING GROUND.

STORMWATER CONSTRUCTION NOTES:

1. CATCH BASIN TYPE 1 PER WSDOT STD PLAN B-5.20-01.
2. CATCH BASIN TYPE 2 PER WSDOT STD PLAN B-10.20-01.
3. SCHEDULE A STORM SEWER PIPE.
4. SCHEDULE A CULVERT PIPE.
5. ADJUST MANHOLE/CATCH BASIN.
6. ADJUST MANHOLE AND REPLACE WITH SLIP RESISTANT LIDS.
7. INFILTRATION TRENCH.
8. UNDERDRAIN TRENCH.
9. UNDERDRAIN TRENCH CLEANOUT.
10. CONCRETE COLLAR FOR CULVERT CONNECTION.

STORMWATER GENERAL NOTES:

1. POTENTIAL LOCATIONS AND APPROXIMATE SIZES FOR STORMWATER PONDS A AND B FOOTPRINTS ARE SHOWN FOR REVIEW. GRADING AND DETAILED CONVEYANCE PIPES WILL BE DESIGNED IN LATER SUBMITTAL.
2. STORMWATER CONVEYANCE SYSTEMS DEPICTED IN THE DRAFT 30 PERCENT PLANS ARE FOR PRELIMINARY DESIGN PURPOSES. STORMWATER CONVEYANCE SYSTEM DESIGN MAY CHANGE DURING FINAL DESIGN IF CONFLICTS WITH EXISTING UTILITIES.
3. PERMEABLE PAVEMENT (POROUS HMA) IS PROPOSED FOR THE PROPOSED TRAIL SURFACE FOR ALL AREAS WHERE INFILTRATION IS LIKELY TO BE FEASIBLE. FURTHER GEOTECHNICAL INVESTIGATION IS REQUIRED TO CONFIRM WHETHER OR NOT THE UNDERLYING SOILS HAVE SUITABLE INFILTRATION RATES TO SUPPORT POROUS HMA. FOR THE DRAFT 30 PERCENT DESIGN PLANS, AREAS ADJACENT TO WETLANDS A, G AND H ARE PROPOSED TO USE CONVENTIONAL HMA UNTIL FURTHER GEOTECHNICAL INVESTIGATION IS PERFORMED TO CONFIRM IF UNDERLYING SOIL TYPES AND GROUNDWATER ELEVATIONS ARE SUITABLE TO INSTALL PERMEABLE PAVEMENT.

LEGEND:

- | | |
|--|-------------------------------|
| | IMPERVIOUS HMA TRAIL PAVEMENT |
| | POROUS HMA TRAIL PAVEMENT |
| | BOARDWALK |

30 % REVIEW SUBMITTAL
NOT FOR CONSTRUCTION

REVISIONS	DATE	BY	DESIGNED
			J. JUN
			B. PURGANAN
			Y. HO
			J. DVORAK

ONE INCH AT FULL SCALE. IF NOT, SCALE ACCORDINGLY
FILE NAME PS1521151P2C2T2AL-01
JOB No. 554-1521-151 P2C T2T200C
DATE MARCH 2017

PRELIMINARY

Parametrix
ENGINEERING · PLANNING · ENVIRONMENTAL SCIENCES

719 2ND AVENUE, SUITE 200 | SEATTLE, WA 98104
P 206.394.3700
WWW.PARAMETRIX.COM

PROJECT NAME

LAKE TO SOUND TRAIL
SEGMENT C



FROM S 200TH ST TO S NORMANDY ROAD /
DES MOINES MEMORIAL DRIVE INTERSECTION

PLAN AND PROFILE

SHEET NO.
9 OF 33

AL3

PATH: U:\P50\Projects\Clients\1521-KingCo\554-1521-151 L2S1-SegC\955\cs\CA00\Phase 2C\Task 21200C.DWG PLOTTED BY: purgabit DATE: Friday, March 10, 2017 1:04:41 PM LAYOUT: AL4

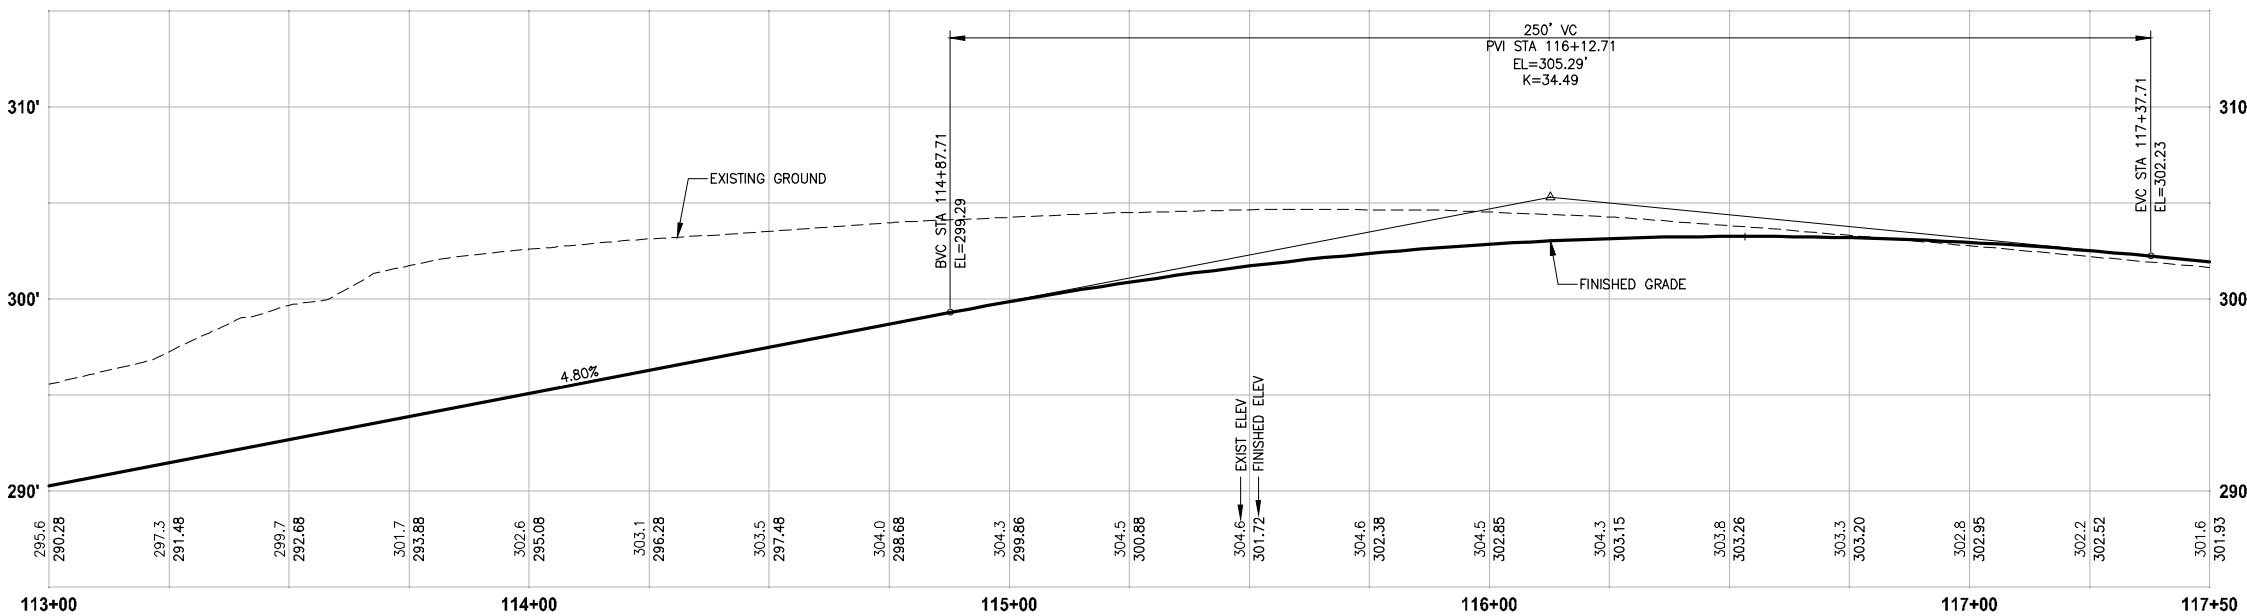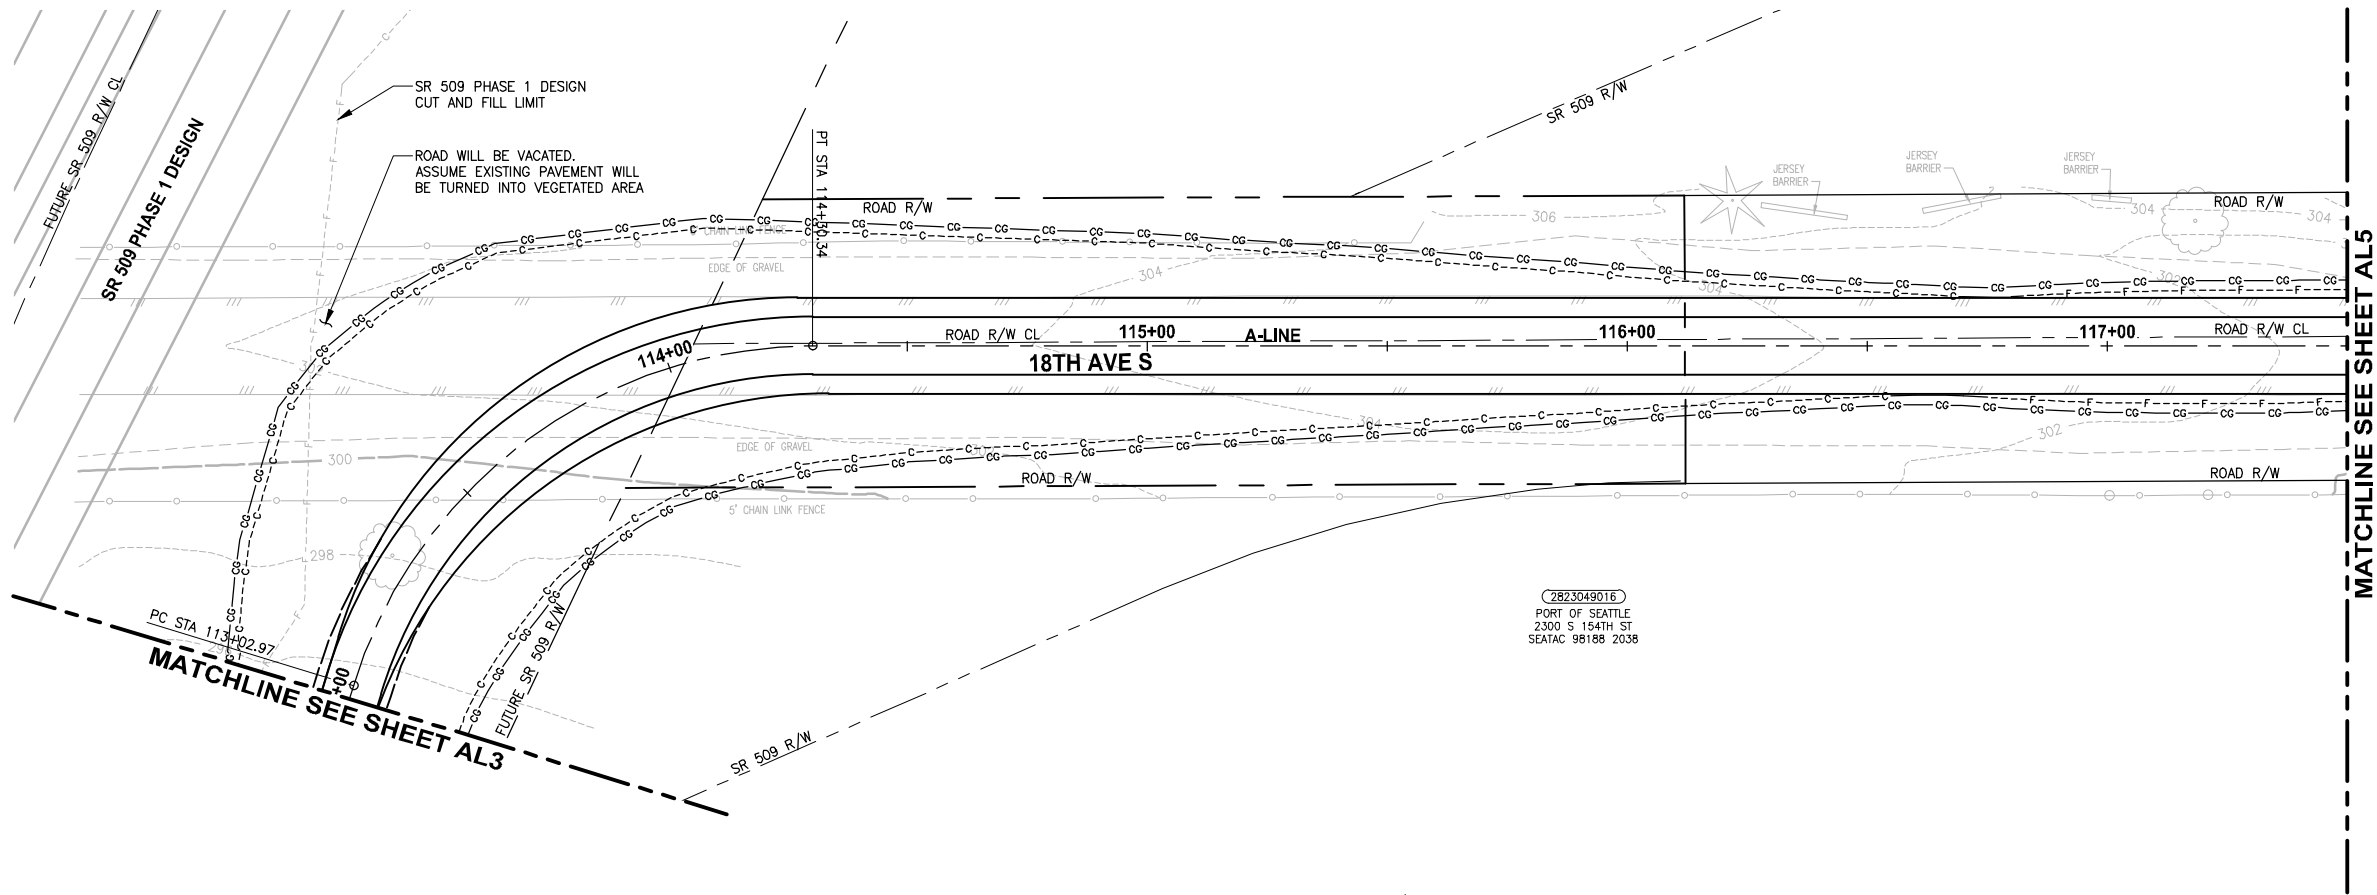

PROFILE

HORIZ: 1"=20'
VERT: 1"=5'

CIVIL CONSTRUCTION NOTES:

1. INSTALL RETAINING WALL.
2. CEMENT CONCRETE CURB AND GUTTER PER WSDOT STD PLAN F-10.12-03.
3. CEMENT CONCRETE DRIVEWAY ENTRANCE TYPE 3 PER WSDOT STD PLAN F-80.10-03.
4. PERPENDICULAR CURB RAMP PER WSDOT STD PLAN F-40.15-03.
5. MOUNTABLE CEMENT CONCRETE TRAFFIC CURB PER WSDOT STD PLAN F-10.12-03.
6. RAISED TRAFFIC ISLAND.
7. ELEVATED STRUCTURE.
8. BUS LANDING PAD.
9. CROSSWALK PER WSDOT STD PLAN M-15.10-01.
10. ASPHALT RAMP TRANSITION TO EXISTING GROUND.

STORMWATER CONSTRUCTION NOTES:

1. CATCH BASIN TYPE 1 PER WSDOT STD PLAN B-5.20-01.
2. CATCH BASIN TYPE 2 PER WSDOT STD PLAN B-10.20-01.
3. SCHEDULE A STORM SEWER PIPE.
4. SCHEDULE A CULVERT PIPE.
5. ADJUST MANHOLE/CATCH BASIN.
6. ADJUST MANHOLE AND REPLACE WITH SLIP RESISTANT LIDS.
7. INFILTRATION TRENCH.
8. UNDERDRAIN TRENCH.
9. UNDERDRAIN TRENCH CLEANOUT.
10. CONCRETE COLLAR FOR CULVERT CONNECTION.

STORMWATER GENERAL NOTES:

1. POTENTIAL LOCATIONS AND APPROXIMATE SIZES FOR STORMWATER PONDS A AND B FOOTPRINTS ARE SHOWN FOR REVIEW. GRADING AND DETAILED CONVEYANCE PIPES WILL BE DESIGNED IN LATER SUBMITTAL.
2. STORMWATER CONVEYANCE SYSTEMS DEPICTED IN THE DRAFT 30 PERCENT PLANS ARE FOR PRELIMINARY DESIGN PURPOSES. STORMWATER CONVEYANCE SYSTEM DESIGN MAY CHANGE DURING FINAL DESIGN IF CONFLICTS WITH EXISTING UTILITIES.
3. PERMEABLE PAVEMENT (POROUS HMA) IS PROPOSED FOR THE PROPOSED TRAIL SURFACE FOR ALL AREAS WHERE INFILTRATION IS LIKELY TO BE FEASIBLE. FURTHER GEOTECHNICAL INVESTIGATION IS REQUIRED TO CONFIRM WHETHER OR NOT THE UNDERLYING SOILS HAVE SUITABLE INFILTRATION RATES TO SUPPORT POROUS HMA. FOR THE DRAFT 30 PERCENT DESIGN PLANS, AREAS ADJACENT TO WETLANDS A, G AND H ARE PROPOSED TO USE CONVENTIONAL HMA UNTIL FURTHER GEOTECHNICAL INVESTIGATION IS PERFORMED TO CONFIRM IF UNDERLYING SOIL TYPES AND GROUNDWATER ELEVATIONS ARE SUITABLE TO INSTALL PERMEABLE PAVEMENT.

LEGEND:

	IMPERVIOUS HMA TRAIL PAVEMENT
	POROUS HMA TRAIL PAVEMENT
	BOARDWALK

30 % REVIEW SUBMITTAL
NOT FOR CONSTRUCTION

REVISIONS	DATE	BY	DESIGNED
			J. JUN
			B. PURGANAN
			Y. HO
			J. DVORAK

ONE INCH AT FULL SCALE. IF NOT, SCALE ACCORDINGLY
FILE NAME PS1521151P2CT2T2AL-01
JOB No. 554-1521-151 P2C T2T200C
DATE MARCH 2017



PRELIMINARY

Parametrix ENGINEERING · PLANNING · ENVIRONMENTAL SCIENCES
719 2ND AVENUE, SUITE 200 SEATTLE, WA 98104 P 206.394.3700 WWW.PARAMETRIX.COM

PROJECT NAME
LAKE TO SOUND TRAIL SEGMENT C
FROM S 200TH ST TO S NORMANDY ROAD / DES MOINES MEMORIAL DRIVE INTERSECTION

PLAN AND PROFILE
SHEET NO. 10 OF 33
AL4

PATH: U:\PSO\Projects\Clients\1521-KingCo\554-1521-151 L2S1-SegC\95Svcs\CADD\Phase 2C\Task 21200C.DWG PLOTTED BY: purgabit DATE: Thursday, March 09, 2017 4:52:47 PM LAYOUT: AL5

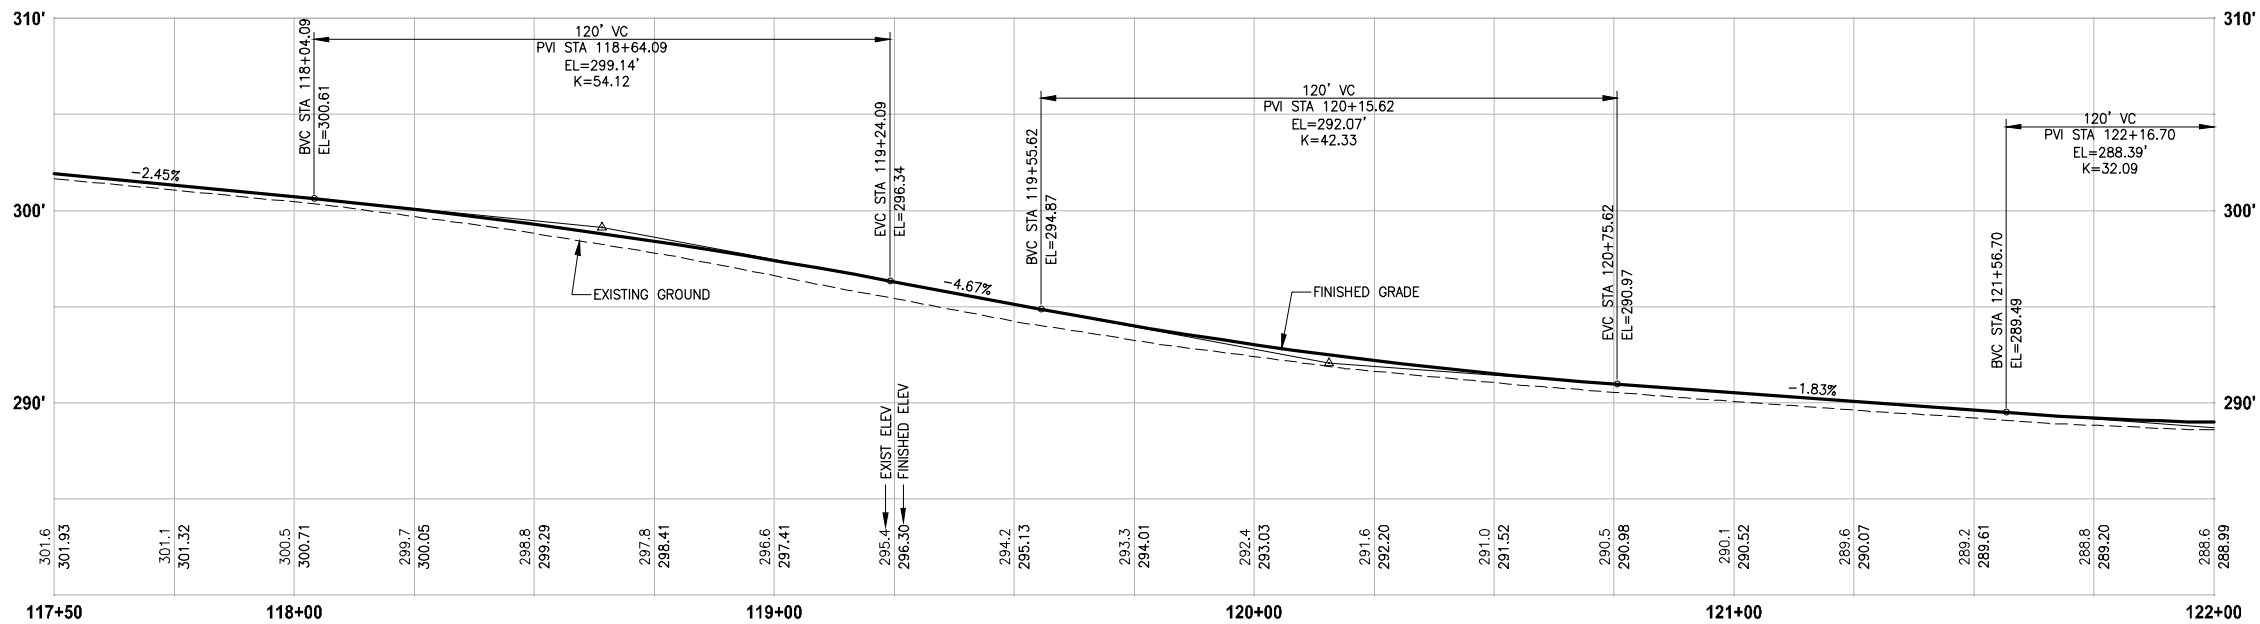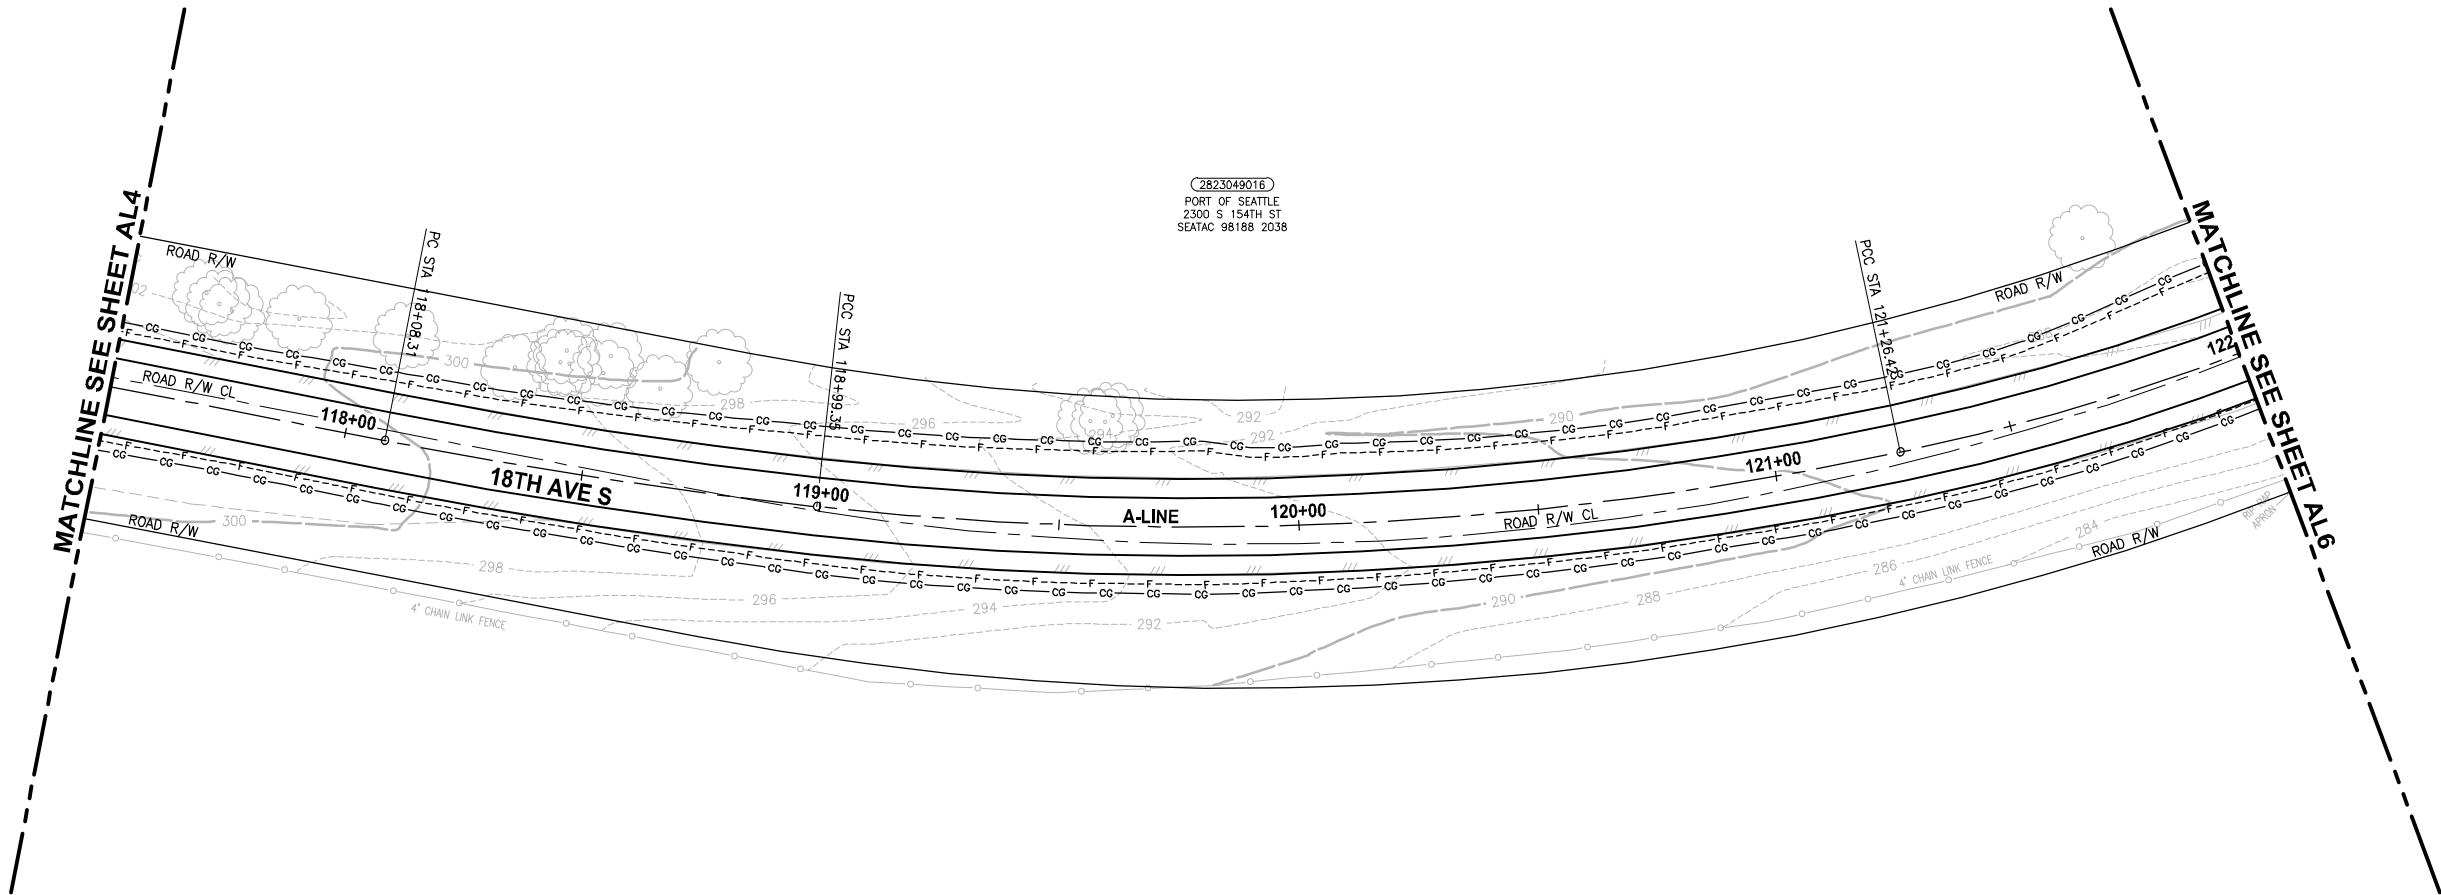

PROFILE

HORIZ: 1"=20'
VERT: 1"=5'

CIVIL CONSTRUCTION NOTES:

1. INSTALL RETAINING WALL.
2. CEMENT CONCRETE CURB AND GUTTER PER WSDOT STD PLAN F-10.12-03.
3. CEMENT CONCRETE DRIVEWAY ENTRANCE TYPE 3 PER WSDOT STD PLAN F-80.10-03.
4. PERPENDICULAR CURB RAMP PER WSDOT STD PLAN F-40.15-03.
5. MOUNTABLE CEMENT CONCRETE TRAFFIC CURB PER WSDOT STD PLAN F-10.12-03.
6. RAISED TRAFFIC ISLAND.
7. ELEVATED STRUCTURE.
8. BUS LANDING PAD.
9. CROSSWALK PER WSDOT STD PLAN M-15.10-01.
10. ASPHALT RAMP TRANSITION TO EXISTING GROUND.

STORMWATER CONSTRUCTION NOTES:

1. CATCH BASIN TYPE 1 PER WSDOT STD PLAN B-5.20-01.
2. CATCH BASIN TYPE 2 PER WSDOT STD PLAN B-10.20-01.
3. SCHEDULE A STORM SEWER PIPE.
4. SCHEDULE A CULVERT PIPE.
5. ADJUST MANHOLE/CATCH BASIN.
6. ADJUST MANHOLE AND REPLACE WITH SLIP RESISTANT LIDS.
7. INFILTRATION TRENCH.
8. UNDERDRAIN TRENCH.
9. UNDERDRAIN TRENCH CLEANOUT.
10. CONCRETE COLLAR FOR CULVERT CONNECTION.

STORMWATER GENERAL NOTES:

1. POTENTIAL LOCATIONS AND APPROXIMATE SIZES FOR STORMWATER PONDS A AND B FOOTPRINTS ARE SHOWN FOR REVIEW. GRADING AND DETAILED CONVEYANCE PIPES WILL BE DESIGNED IN LATER SUBMITTAL.
2. STORMWATER CONVEYANCE SYSTEMS DEPICTED IN THE DRAFT 30 PERCENT PLANS ARE FOR PRELIMINARY DESIGN PURPOSES. STORMWATER CONVEYANCE SYSTEM DESIGN MAY CHANGE DURING FINAL DESIGN IF CONFLICTS WITH EXISTING UTILITIES.
3. PERMEABLE PAVEMENT (POROUS HMA) IS PROPOSED FOR THE PROPOSED TRAIL SURFACE FOR ALL AREAS WHERE INFILTRATION IS LIKELY TO BE FEASIBLE. FURTHER GEOTECHNICAL INVESTIGATION IS REQUIRED TO CONFIRM WHETHER OR NOT THE UNDERLYING SOILS HAVE SUITABLE INFILTRATION RATES TO SUPPORT POROUS HMA. FOR THE DRAFT 30 PERCENT DESIGN PLANS, AREAS ADJACENT TO WETLANDS A, G AND H ARE PROPOSED TO USE CONVENTIONAL HMA UNTIL FURTHER GEOTECHNICAL INVESTIGATION IS PERFORMED TO CONFIRM IF UNDERLYING SOIL TYPES AND GROUNDWATER ELEVATIONS ARE SUITABLE TO INSTALL PERMEABLE PAVEMENT.

LEGEND:

- | | |
|--|-------------------------------|
| | IMPERVIOUS HMA TRAIL PAVEMENT |
| | POROUS HMA TRAIL PAVEMENT |
| | BOARDWALK |

30 % REVIEW SUBMITTAL
NOT FOR CONSTRUCTION

REVISIONS	DATE	BY	DESIGNED
			J. JUN
			DRAWN
			B. PURGANAN
			CHECKED
			Y. HO
			APPROVED
			J. DVORAK

ONE INCH AT FULL SCALE. IF NOT, SCALE ACCORDINGLY
FILE NAME PS1521151P2CT2T2AL-01
JOB No. 554-1521-151 P2C T2T200C
DATE MARCH 2017

PRELIMINARY

Parametrix
ENGINEERING · PLANNING · ENVIRONMENTAL SCIENCES

719 2ND AVENUE, SUITE 200 | SEATTLE, WA 98104
P 206.394.3700
WWW.PARAMETRIX.COM

PROJECT NAME


**LAKE TO SOUND TRAIL
SEGMENT C**

FROM S 200TH ST TO S NORMANDY ROAD /
DES MOINES MEMORIAL DRIVE INTERSECTION

PLAN AND PROFILE

SHEET NO.
11 OF 33

 AL5



HORIZ: 1"=20'
VERT: 1"=5'

**ONE INCH AT FULL SCALE.
IF NOT, SCALE ACCORDINGLY**

FILE NAME
PS1521151P2CT2T2AL-01

JOB No.
554-1521-151 P2C T2T200C

DATE
MARCH 2017

Parametrix
ENGINEERING . PLANNING . ENVIRONMENTAL SCIENCES

719 2ND AVENUE, SUITE 200 | SEATTLE, WA 98104
P 206.394.3700
WWW.PARAMETRIX.COM

**LAKE TO SOUND TRAIL
SEGMENT C**

FROM S 200TH ST TO S NORMANDY ROAD /
DES MOINES MEMORIAL DRIVE INTERSECTION

PLAN AND PROFILE

30 % REVIEW SUBMITTAL
NOT FOR CONSTRUCTION

SHEET NO.
12 OF 33

AL6



1. INSTALL RETAINING WALL.
2. CEMENT CONCRETE CURB AND GUTTER PER WSDOT STD PLAN F-10.12-03.
3. CEMENT CONCRETE DRIVEWAY ENTRANCE TYPE 3 PER WSDOT STD PLAN F-80.10-03.
4. PERPENDICULAR CURB RAMP PER WSDOT STD PLAN F-40.15-03.
5. MOUNTABLE CEMENT CONCRETE TRAFFIC CURB PER WSDOT STD PLAN F-10.12-03.
6. RAISED TRAFFIC ISLAND.
7. ELEVATED STRUCTURE.
8. BUS LANDING PAD.
9. CROSSWALK PER WSDOT STD PLAN M-15.10-01.
10. ASPHALT RAMP TRANSITION TO EXISTING GROUND.

- 1 CATCH BASIN TYPE 1 PER WSDOT STD PLAN B-5.20-01.
- 2 CATCH BASIN TYPE 2 PER WSDOT STD PLAN B-10.20-01.
- 3 SCHEDULE A STORM SEWER PIPE.
- 4 SCHEDULE A CULVERT PIPE.
- 5 ADJUST MANHOLE/CATCH BASIN.
- 6 ADJUST MANHOLE AND REPLACE WITH SLIP RESISTANT LIDS.
- 7 INFILTRATION TRENCH.
- 8 UNDERDRAIN TRENCH.
- 9 UNDERDRAIN TRENCH CLEANOUT.
- 10 CONCRETE COLLAR FOR CULVERT CONNECTION

1. POTENTIAL LOCATIONS AND APPROXIMATE SIZES FOR STORMWATER PONDS A AND B FOOTPRINTS ARE SHOWN FOR REVIEW. GRADING AND DETAILED CONVEYANCE PIPES WILL BE DESIGNED IN LATER SUBMITTAL.
2. STORMWATER CONVEYANCE SYSTEMS DEPICTED IN THE DRAFT 30 PERCENT PLANS ARE FOR PRELIMINARY DESIGN PURPOSES. STORMWATER CONVEYANCE SYSTEM DESIGN MAY CHANGE DURING FINAL DESIGN IF CONFLICTS WITH EXISTING UTILITIES.
3. PERMEABLE PAVEMENT (POROUS HMA) IS PROPOSED FOR THE PROPOSED TRAIL SURFACE FOR ALL AREAS WHERE INFILTRATION IS LIKELY TO BE FEASIBLE. FURTHER GEOTECHNICAL INVESTIGATION IS REQUIRED TO CONFIRM WHETHER OR NOT THE UNDERLYING SOILS HAVE SUITABLE INFILTRATION RATES TO SUPPORT POROUS HMA. FOR THE DRAFT 30 PERCENT DESIGN PLANS, AREAS ADJACENT TO WETLANDS A, C AND H ARE PROPOSED TO USE CONVENTIONAL HMA UNTIL FURTHER GEOTECHNICAL INVESTIGATION IS PERFORMED TO CONFIRM IF UNDERLYING SOIL TYPES AND GROUNDWATER ELEVATIONS ARE SUITABLE TO INSTALL PERMEABLE PAVEMENT.

	IMPERVIOUS HMA TRAIL PAVEMENT
	POROUS HMA TRAIL PAVEMENT
	BOARDWALK

PATH: U:\P50\Projects\Clients\1521-KingCo\554-1521-151 L2S1-SegC\95Svcs\CADD\Phase 2C\Task 21200C.DWG PLOTTED BY: purgabit DATE: Thursday, March 09, 2017 4:53:37 PM LAYOUT: AL7

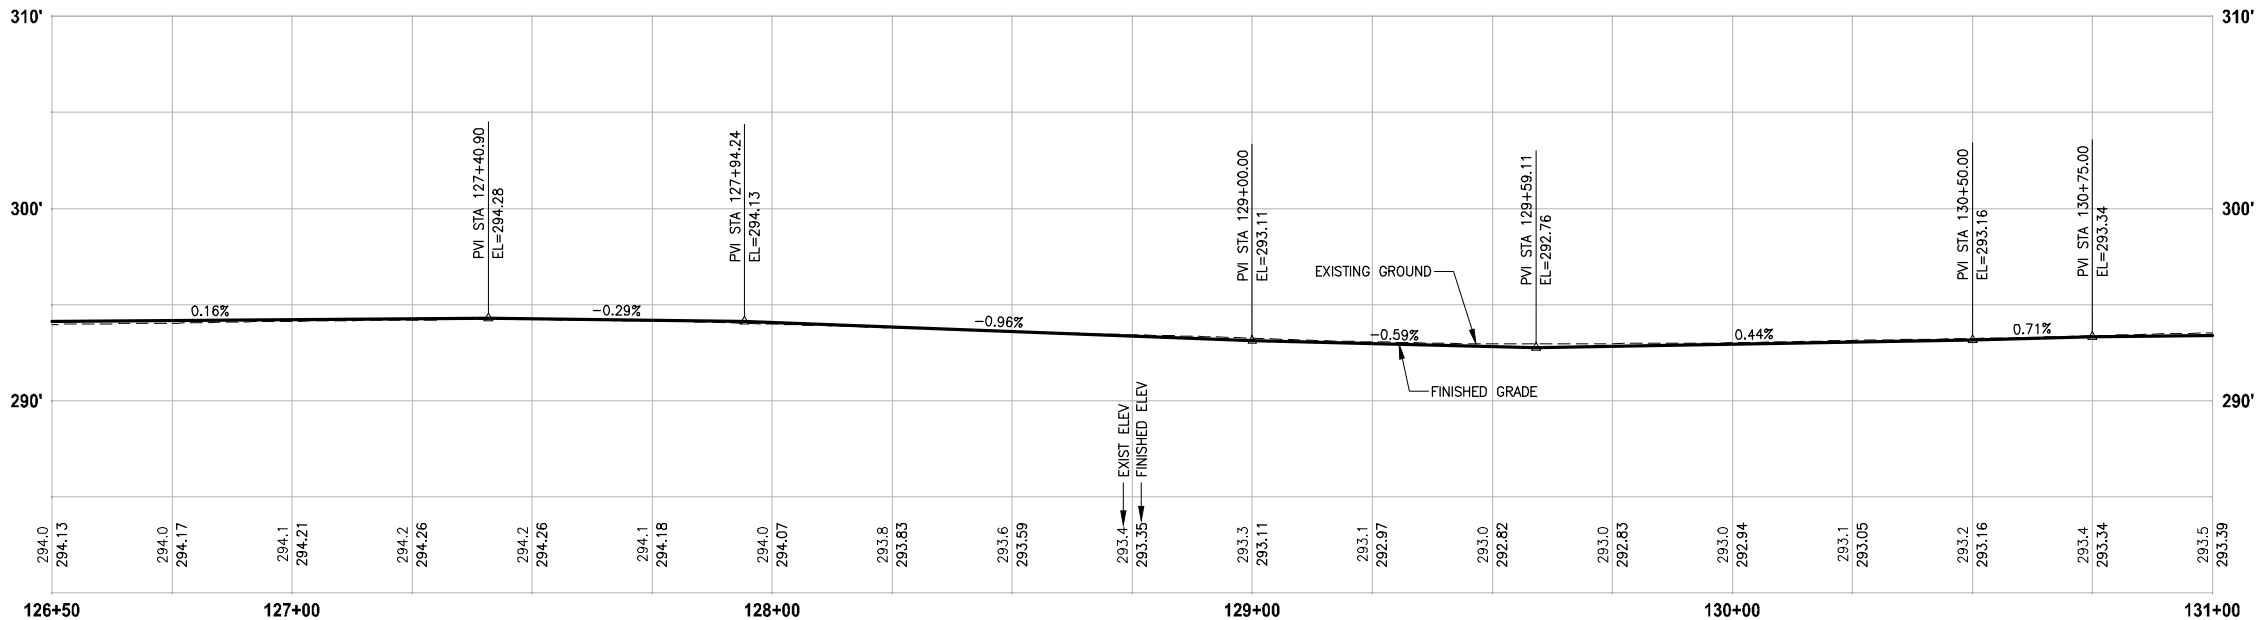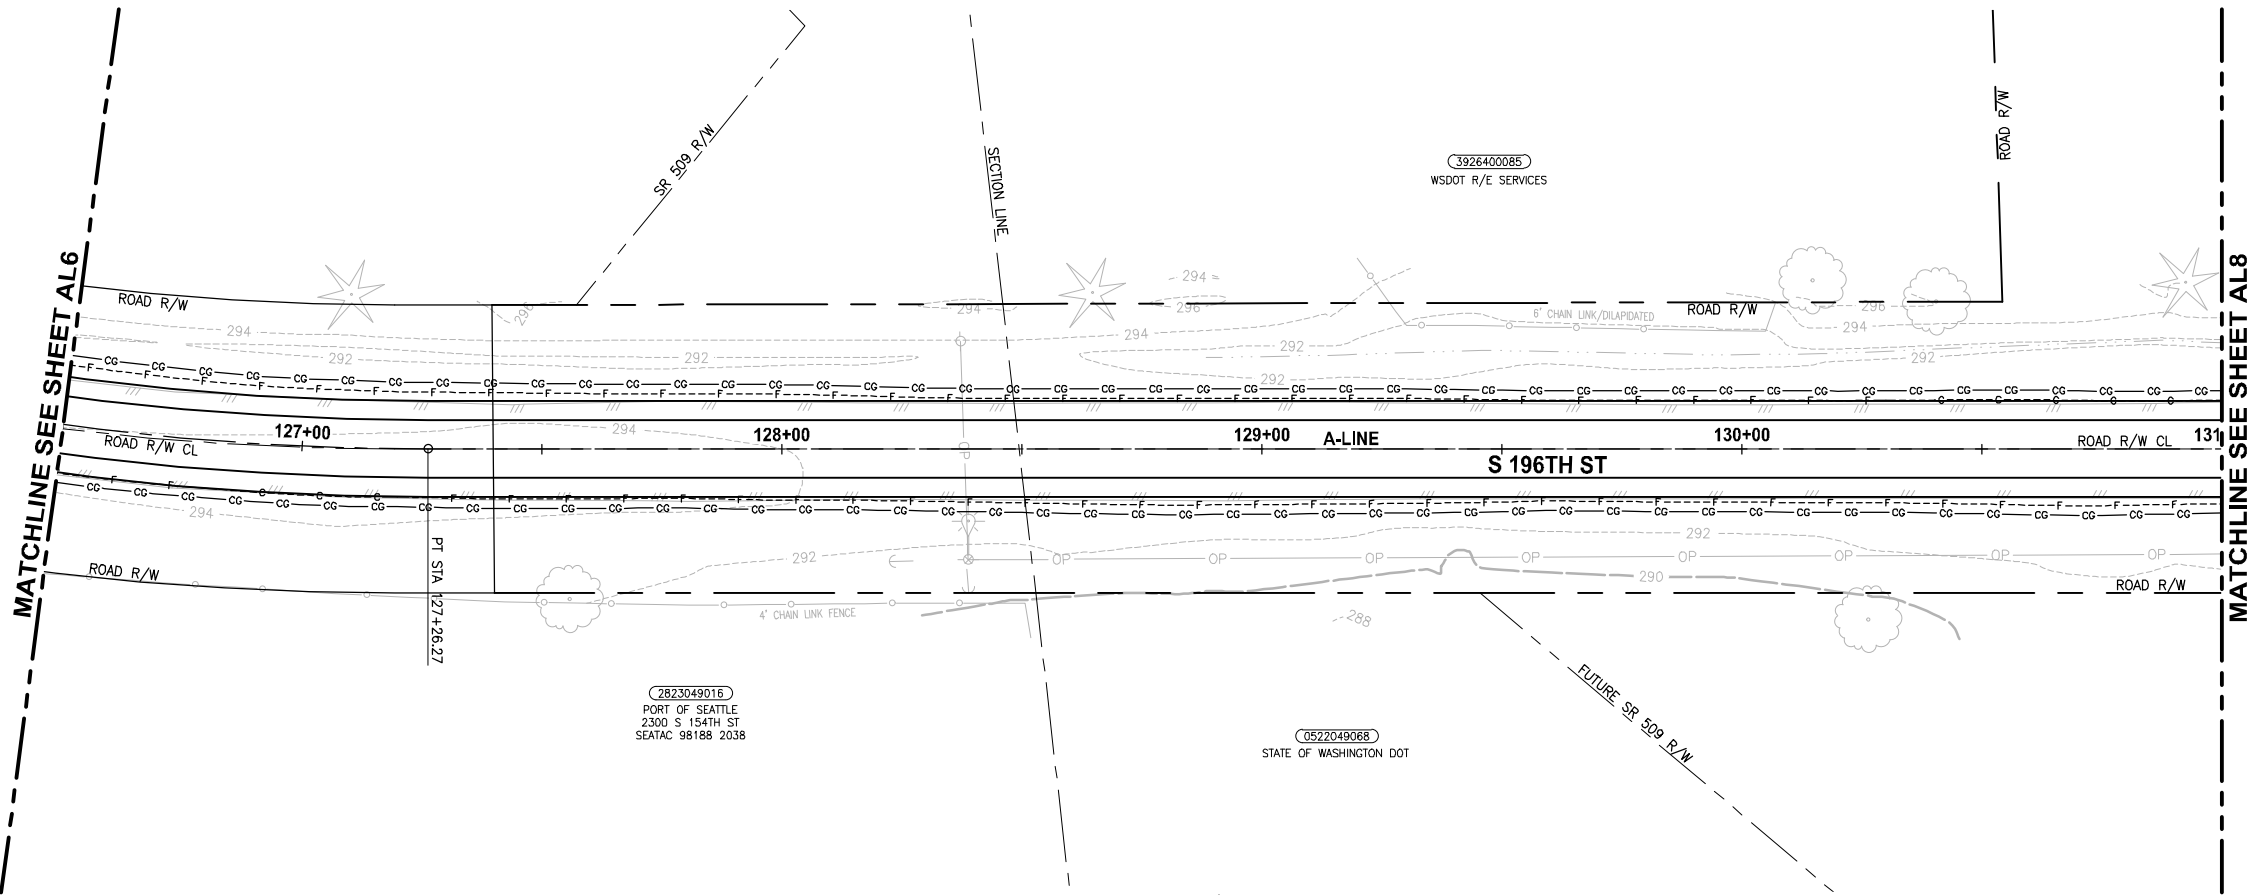

PROFILE

HORIZ: 1"=20'
VERT: 1"=5'

CIVIL CONSTRUCTION NOTES:

1. INSTALL RETAINING WALL.
2. CEMENT CONCRETE CURB AND GUTTER PER WSDOT STD PLAN F-10.12-03.
3. CEMENT CONCRETE DRIVEWAY ENTRANCE TYPE 3 PER WSDOT STD PLAN F-80.10-03.
4. PERPENDICULAR CURB RAMP PER WSDOT STD PLAN F-40.15-03.
5. MOUNTABLE CEMENT CONCRETE TRAFFIC CURB PER WSDOT STD PLAN F-10.12-03.
6. RAISED TRAFFIC ISLAND.
7. ELEVATED STRUCTURE.
8. BUS LANDING PAD.
9. CROSSWALK PER WSDOT STD PLAN M-15.10-01.
10. ASPHALT RAMP TRANSITION TO EXISTING GROUND.

STORMWATER CONSTRUCTION NOTES:

1. CATCH BASIN TYPE 1 PER WSDOT STD PLAN B-5.20-01.
2. CATCH BASIN TYPE 2 PER WSDOT STD PLAN B-10.20-01.
3. SCHEDULE A STORM SEWER PIPE.
4. SCHEDULE A CULVERT PIPE.
5. ADJUST MANHOLE/CATCH BASIN.
6. ADJUST MANHOLE AND REPLACE WITH SLIP RESISTANT LIDS.
7. INFILTRATION TRENCH.
8. UNDERDRAIN TRENCH.
9. UNDERDRAIN TRENCH CLEANOUT.
10. CONCRETE COLLAR FOR CULVERT CONNECTION.

STORMWATER GENERAL NOTES:

1. POTENTIAL LOCATIONS AND APPROXIMATE SIZES FOR STORMWATER PONDS A AND B FOOTPRINTS ARE SHOWN FOR REVIEW. GRADING AND DETAILED CONVEYANCE PIPES WILL BE DESIGNED IN LATER SUBMITTAL.
2. STORMWATER CONVEYANCE SYSTEMS DEPICTED IN THE DRAFT 30 PERCENT PLANS ARE FOR PRELIMINARY DESIGN PURPOSES. STORMWATER CONVEYANCE SYSTEM DESIGN MAY CHANGE DURING FINAL DESIGN IF CONFLICTS WITH EXISTING UTILITIES.
3. PERMEABLE PAVEMENT (POROUS HMA) IS PROPOSED FOR THE PROPOSED TRAIL SURFACE FOR ALL AREAS WHERE INFILTRATION IS LIKELY TO BE FEASIBLE. FURTHER GEOTECHNICAL INVESTIGATION IS REQUIRED TO CONFIRM WHETHER OR NOT THE UNDERLYING SOILS HAVE SUITABLE INFILTRATION RATES TO SUPPORT POROUS HMA. FOR THE DRAFT 30 PERCENT DESIGN PLANS, AREAS ADJACENT TO WETLANDS A, G AND H ARE PROPOSED TO USE CONVENTIONAL HMA UNTIL FURTHER GEOTECHNICAL INVESTIGATION IS PERFORMED TO CONFIRM IF UNDERLYING SOIL TYPES AND GROUNDWATER ELEVATIONS ARE SUITABLE TO INSTALL PERMEABLE PAVEMENT.

LEGEND:

- | | |
|--|-------------------------------|
| | IMPERVIOUS HMA TRAIL PAVEMENT |
| | POROUS HMA TRAIL PAVEMENT |
| | BOARDWALK |

30 % REVIEW SUBMITTAL
NOT FOR CONSTRUCTION

PLAN AND PROFILE

SHEET NO.
13 OF 33

AL7

Parametrix
ENGINEERING · PLANNING · ENVIRONMENTAL SCIENCES

719 2ND AVENUE, SUITE 200 | SEATTLE, WA 98104
P 206.394.3700
WWW.PARAMETRIX.COM

PROJECT NAME

LAKE TO SOUND TRAIL SEGMENT C

FROM S 200TH ST TO S NORMANDY ROAD /
DES MOINES MEMORIAL DRIVE INTERSECTION

REVISIONS	DATE	BY	DESIGNED
			J. JUN
			B. PURGANAN
			Y. HO
			J. DVORAK

ONE INCH AT FULL SCALE.
IF NOT, SCALE ACCORDINGLY

FILE NAME
PS1521151P2C2T2T2AL-01


 

JOB No.
554-1521-151 P2C T2T200C

DATE
MARCH 2017

PRELIMINARY

PATH: U:\PSO\Projects\Clients\1521-KingCo\554-1521-151 L2S1-SegC\955\Drawings\Phase 2C\Task 21200C\DWG LAYOUT: ALB PLOTTED BY: purgabaui DATE: Friday, March 10, 2017 2:09:55 PM

MATCHLINE SEE SHEET AL7

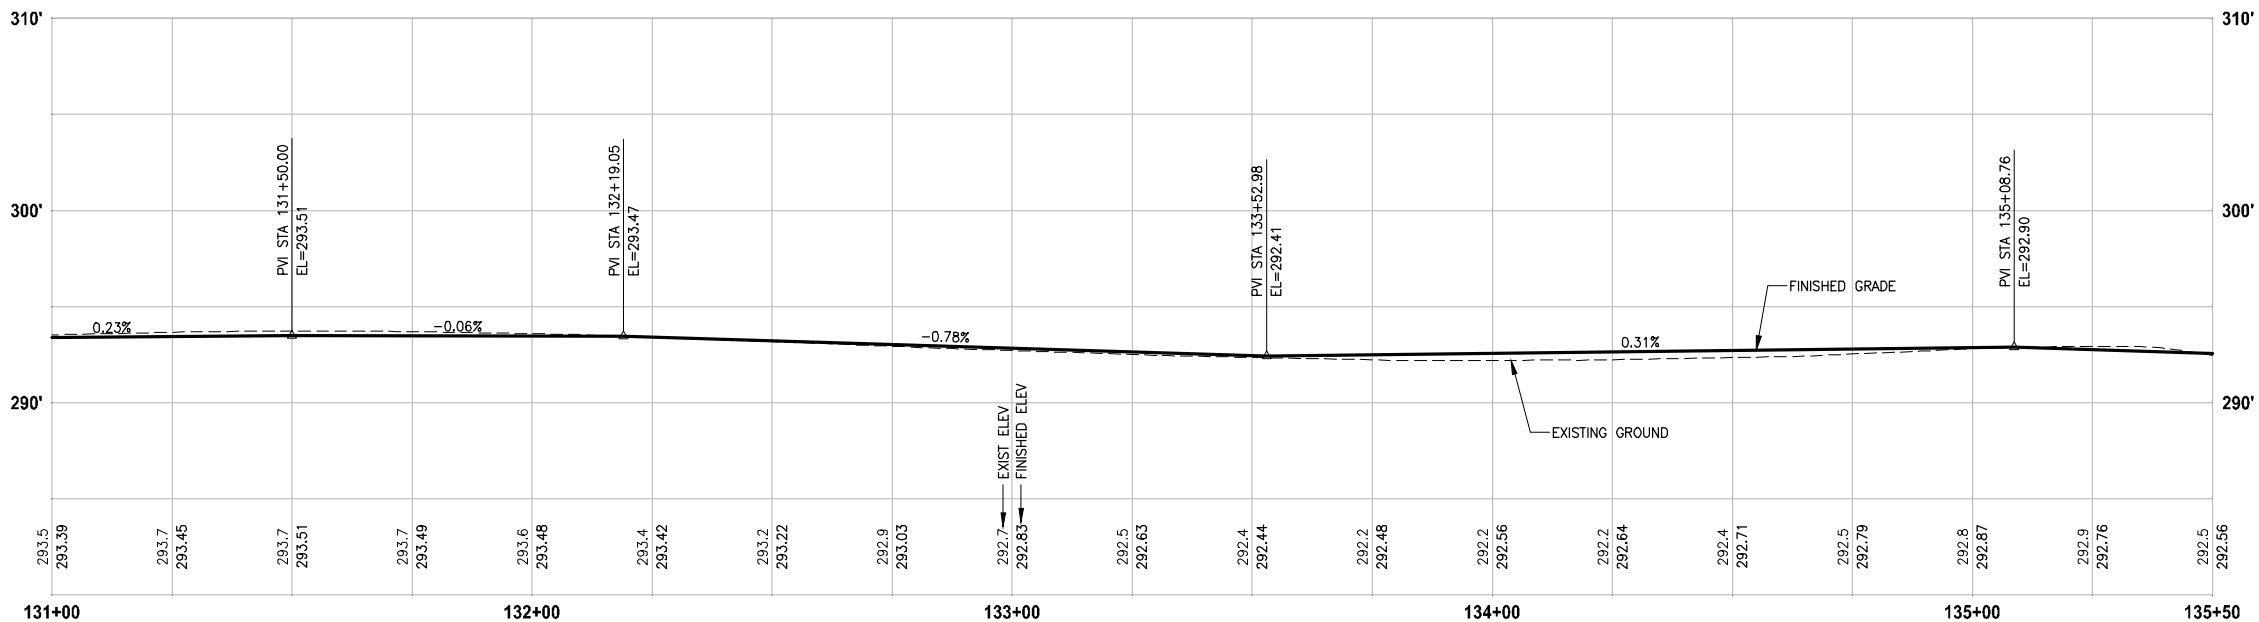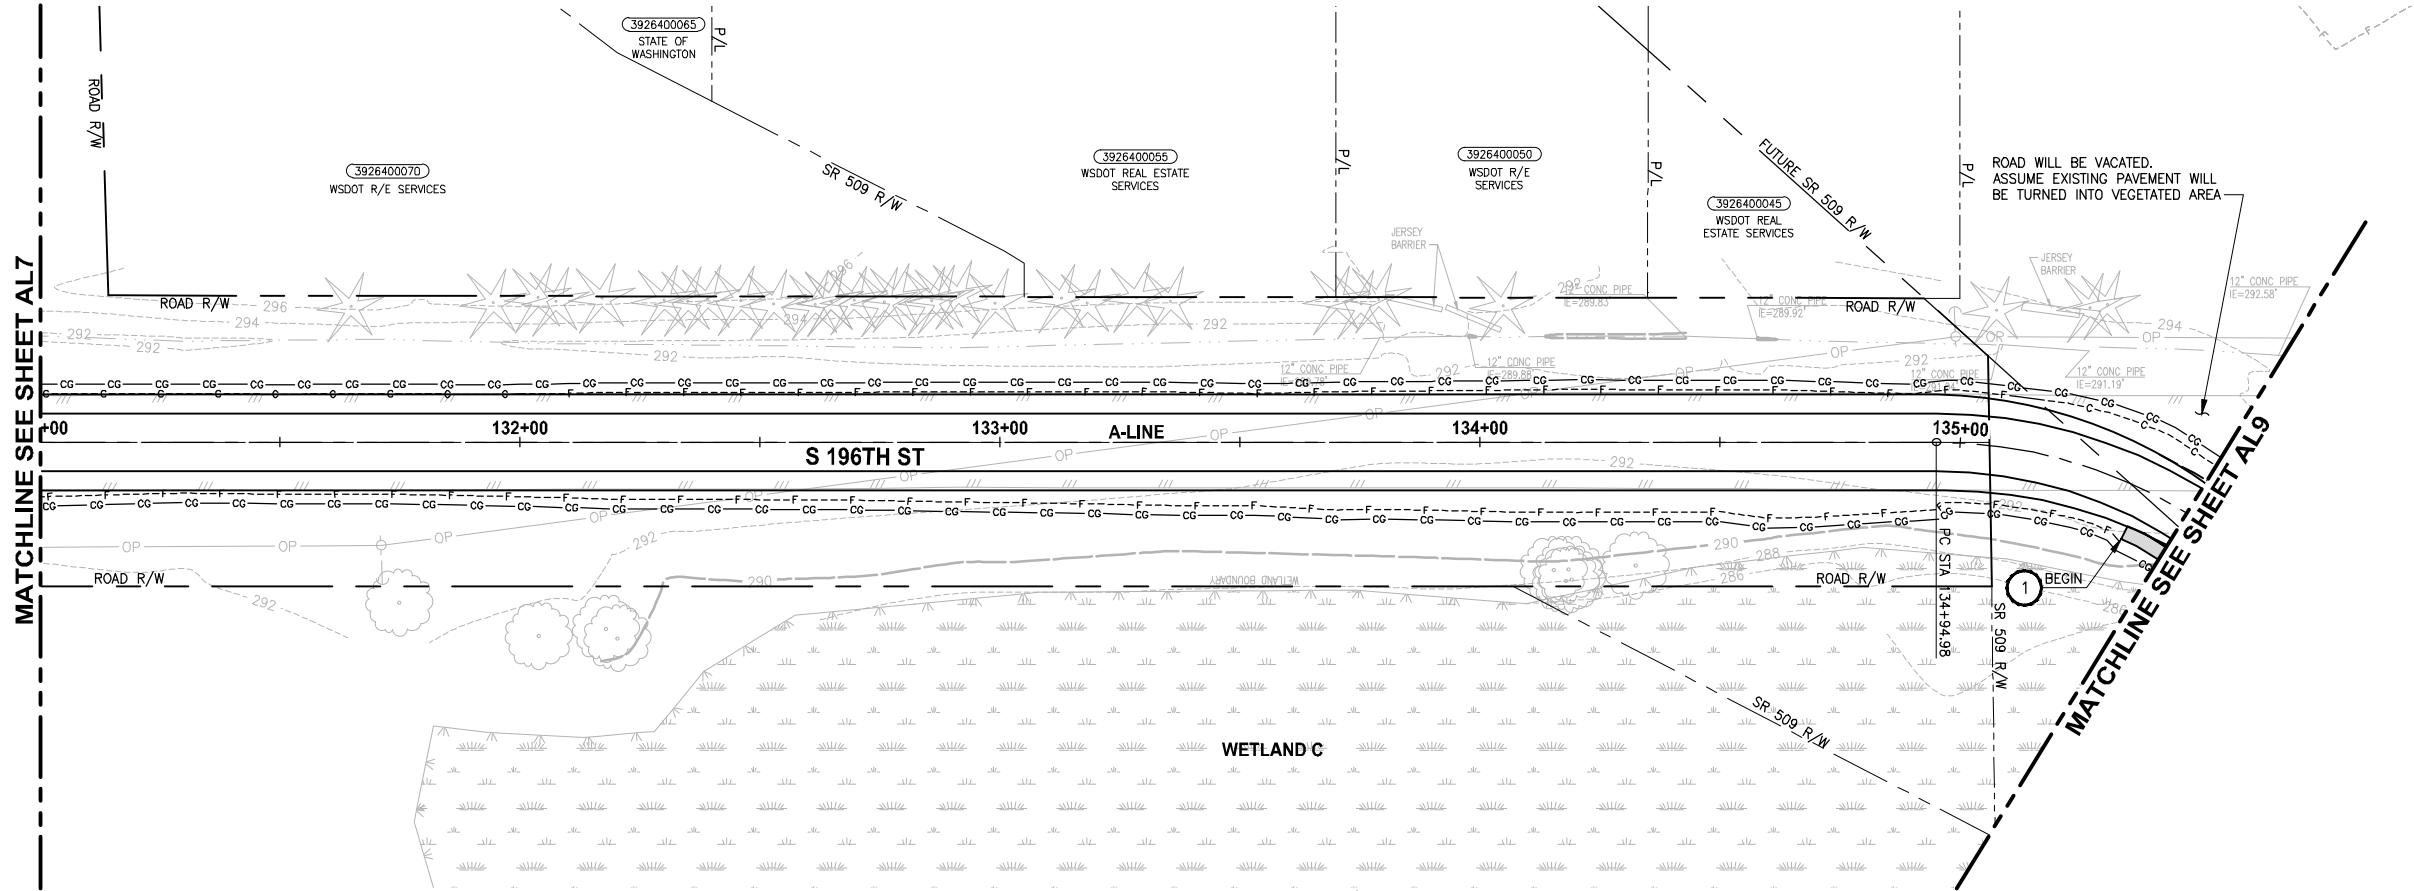

PROFILE

HORIZ: 1"=20'
VERT: 1"=5'

CIVIL CONSTRUCTION NOTES:

1. INSTALL RETAINING WALL.
2. CEMENT CONCRETE CURB AND GUTTER PER WSDOT STD PLAN F-10.12-03.
3. CEMENT CONCRETE DRIVEWAY ENTRANCE TYPE 3 PER WSDOT STD PLAN F-80.10-03.
4. PERPENDICULAR CURB RAMP PER WSDOT STD PLAN F-40.15-03.
5. MOUNTABLE CEMENT CONCRETE TRAFFIC CURB PER WSDOT STD PLAN F-10.12-03.
6. RAISED TRAFFIC ISLAND.
7. ELEVATED STRUCTURE.
8. BUS LANDING PAD.
9. CROSSWALK PER WSDOT STD PLAN M-15.10-01.
10. ASPHALT RAMP TRANSITION TO EXISTING GROUND.

STORMWATER CONSTRUCTION NOTES:

1. CATCH BASIN TYPE 1 PER WSDOT STD PLAN B-5.20-01.
2. CATCH BASIN TYPE 2 PER WSDOT STD PLAN B-10.20-01.
3. SCHEDULE A STORM SEWER PIPE.
4. SCHEDULE A CULVERT PIPE.
5. ADJUST MANHOLE/CATCH BASIN.
6. ADJUST MANHOLE AND REPLACE WITH SLIP RESISTANT LIDS.
7. INFILTRATION TRENCH.
8. UNDERDRAIN TRENCH.
9. UNDERDRAIN TRENCH CLEANOUT.
10. CONCRETE COLLAR FOR CULVERT CONNECTION.

STORMWATER GENERAL NOTES:

1. POTENTIAL LOCATIONS AND APPROXIMATE SIZES FOR STORMWATER PONDS A AND B FOOTPRINTS ARE SHOWN FOR REVIEW. GRADING AND DETAILED CONVEYANCE PIPES WILL BE DESIGNED IN LATER SUBMITTAL.
2. STORMWATER CONVEYANCE SYSTEMS DEPICTED IN THE DRAFT 30 PERCENT PLANS ARE FOR PRELIMINARY DESIGN PURPOSES. STORMWATER CONVEYANCE SYSTEM DESIGN MAY CHANGE DURING FINAL DESIGN IF CONFLICTS WITH EXISTING UTILITIES.
3. PERMEABLE PAVEMENT (POROUS HMA) IS PROPOSED FOR THE PROPOSED TRAIL SURFACE FOR ALL AREAS WHERE INFILTRATION IS LIKELY TO BE FEASIBLE. FURTHER GEOTECHNICAL INVESTIGATION IS REQUIRED TO CONFIRM WHETHER OR NOT THE UNDERLYING SOILS HAVE SUITABLE INFILTRATION RATES TO SUPPORT POROUS HMA. FOR THE DRAFT 30 PERCENT DESIGN PLANS, AREAS ADJACENT TO WETLANDS A, G AND H ARE PROPOSED TO USE CONVENTIONAL HMA UNTIL FURTHER GEOTECHNICAL INVESTIGATION IS PERFORMED TO CONFIRM IF UNDERLYING SOIL TYPES AND GROUNDWATER ELEVATIONS ARE SUITABLE TO INSTALL PERMEABLE PAVEMENT.

LEGEND:

	IMPERVIOUS HMA TRAIL PAVEMENT
	POROUS HMA TRAIL PAVEMENT
	BOARDWALK

30 % REVIEW SUBMITTAL
NOT FOR CONSTRUCTION

REVISIONS	DATE	BY	DESIGNED
			J. JUN
			B. PURGANAN
			Y. HO
			J. DVORAK

ONE INCH AT FULL SCALE. IF NOT, SCALE ACCORDINGLY
FILE NAME PS1521151P2CT2T2AL-01
JOB No. 554-1521-151 P2C T2T200C
DATE MARCH 2017


 

PRELIMINARY

Parametrix ENGINEERING · PLANNING · ENVIRONMENTAL SCIENCES
719 2ND AVENUE, SUITE 200 SEATTLE, WA 98104 P 206.394.3700 WWW.PARAMETRIX.COM

PROJECT NAME
LAKE TO SOUND TRAIL SEGMENT C
FROM S 200TH ST TO S NORMANDY ROAD / DES MOINES MEMORIAL DRIVE INTERSECTION

PLAN AND PROFILE
SHEET NO. 14 OF 33
AL8

PATH: U:\PSO\Projects\Clients\1521-KingCo\554-1521-151 L2S1-SegC\95Svcs\CADD\Phase 2C\Task 21200C.DWG PLOTTED BY: purgabit DATE: Friday, March 10, 2017 2:10:36 PM LAYOUT: AL9

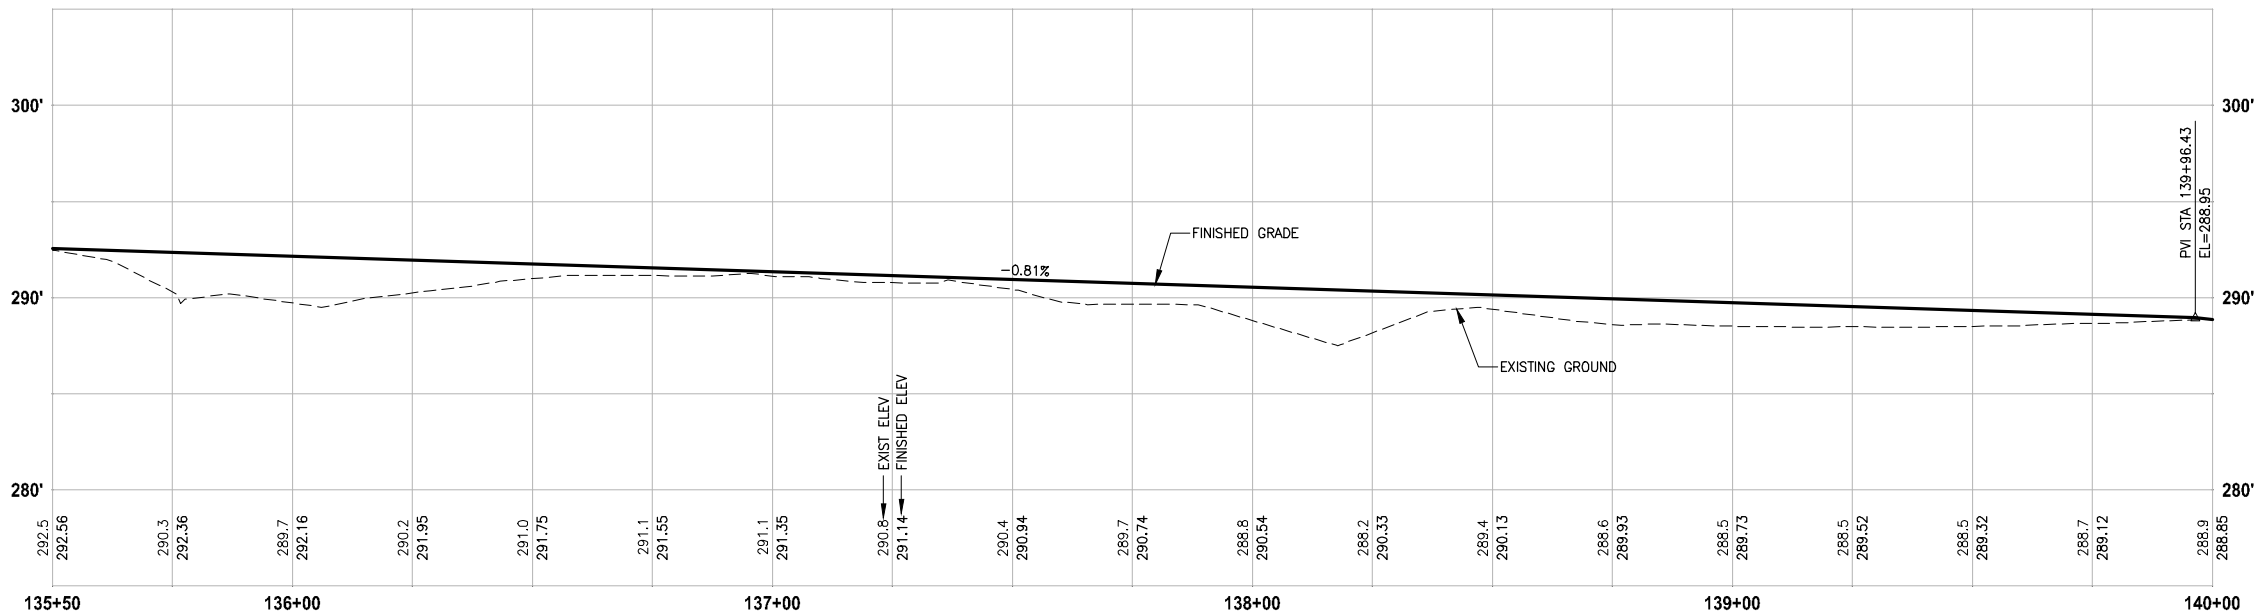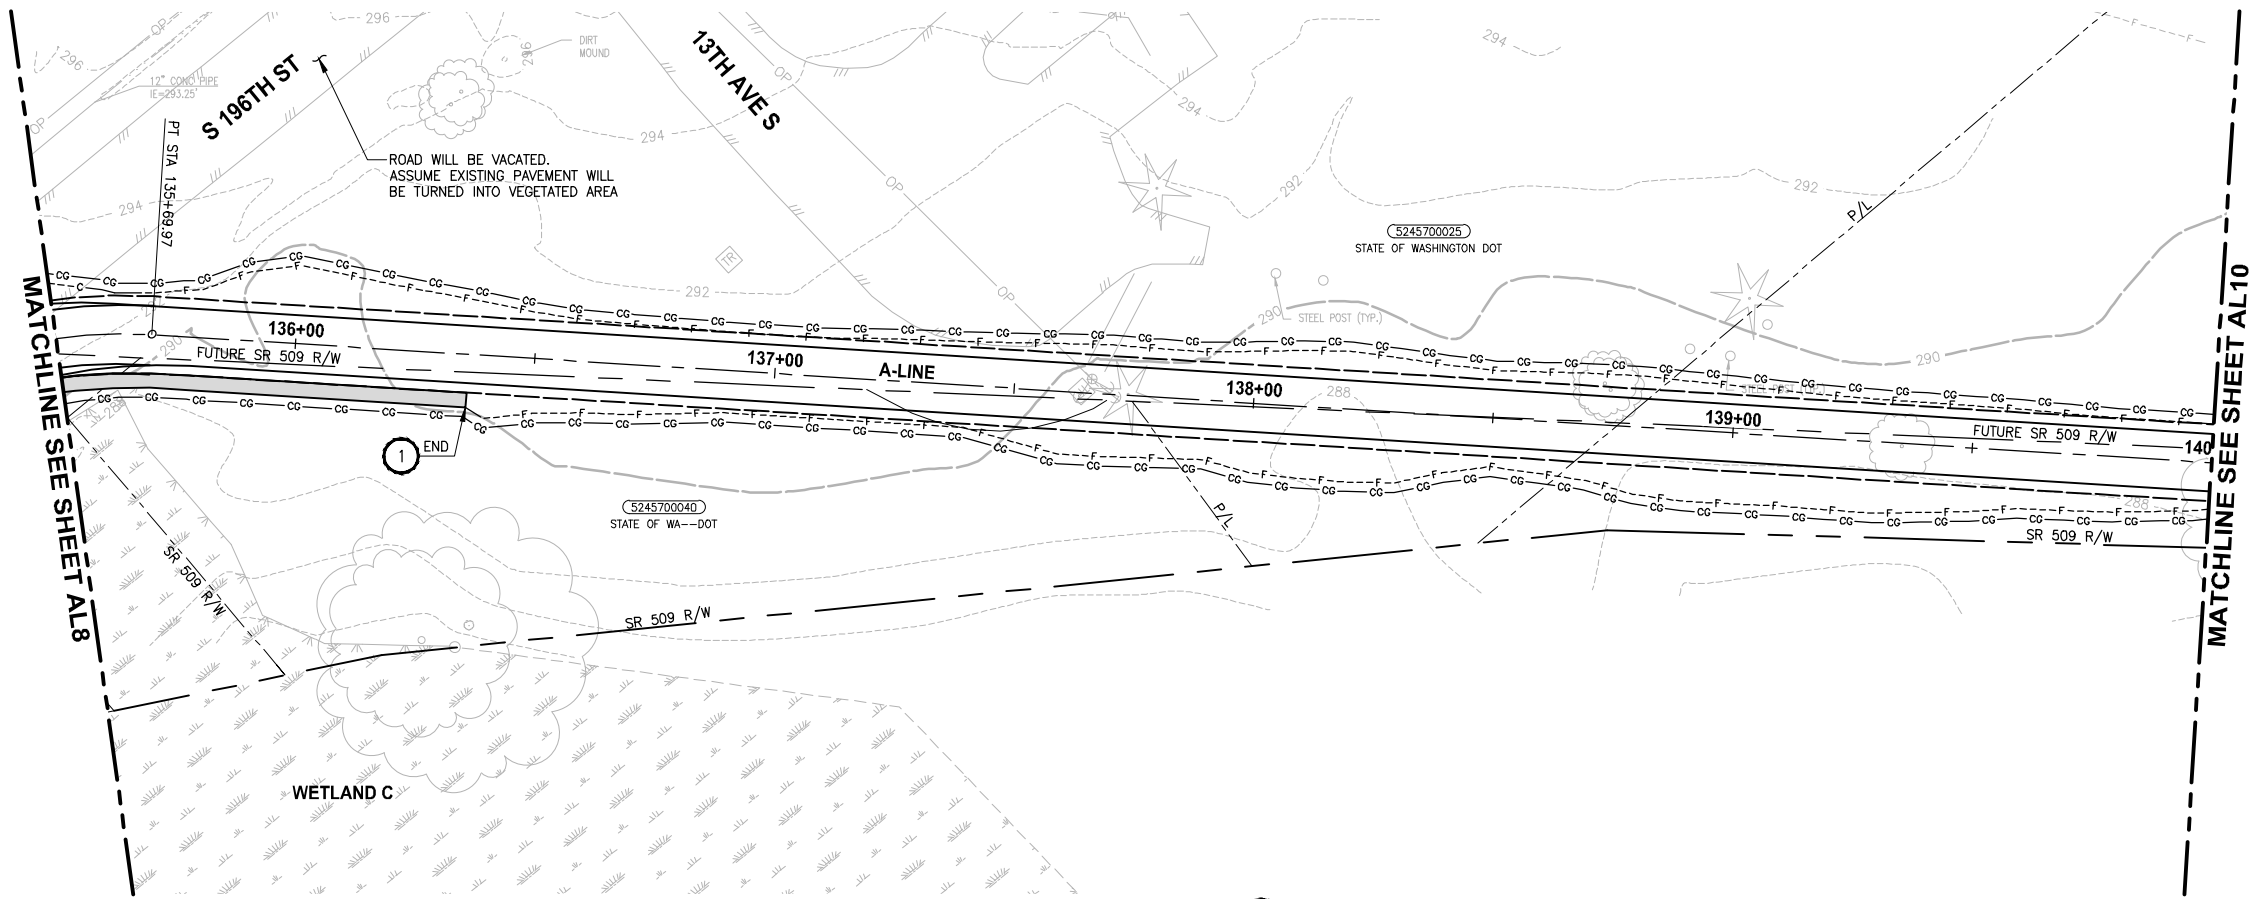

PROFILE

HORIZ: 1"=20'
VERT: 1"=5'

CIVIL CONSTRUCTION NOTES:

1. INSTALL RETAINING WALL.
2. CEMENT CONCRETE CURB AND GUTTER PER WSDOT STD PLAN F-10.12-03.
3. CEMENT CONCRETE DRIVEWAY ENTRANCE TYPE 3 PER WSDOT STD PLAN F-80.10-03.
4. PERPENDICULAR CURB RAMP PER WSDOT STD PLAN F-40.15-03.
5. MOUNTABLE CEMENT CONCRETE TRAFFIC CURB PER WSDOT STD PLAN F-10.12-03.
6. RAISED TRAFFIC ISLAND.
7. ELEVATED STRUCTURE.
8. BUS LANDING PAD.
9. CROSSWALK PER WSDOT STD PLAN M-15.10-01.
10. ASPHALT RAMP TRANSITION TO EXISTING GROUND.

STORMWATER CONSTRUCTION NOTES:

1. CATCH BASIN TYPE 1 PER WSDOT STD PLAN B-5.20-01.
2. CATCH BASIN TYPE 2 PER WSDOT STD PLAN B-10.20-01.
3. SCHEDULE A STORM SEWER PIPE.
4. SCHEDULE A CULVERT PIPE.
5. ADJUST MANHOLE/CATCH BASIN.
6. ADJUST MANHOLE AND REPLACE WITH SLIP RESISTANT LIDS.
7. INFILTRATION TRENCH.
8. UNDERDRAIN TRENCH.
9. UNDERDRAIN TRENCH CLEANOUT.
10. CONCRETE COLLAR FOR CULVERT CONNECTION.

STORMWATER GENERAL NOTES:

1. POTENTIAL LOCATIONS AND APPROXIMATE SIZES FOR STORMWATER PONDS A AND B FOOTPRINTS ARE SHOWN FOR REVIEW. GRADING AND DETAILED CONVEYANCE PIPES WILL BE DESIGNED IN LATER SUBMITTAL.
2. STORMWATER CONVEYANCE SYSTEMS DEPICTED IN THE DRAFT 30 PERCENT PLANS ARE FOR PRELIMINARY DESIGN PURPOSES. STORMWATER CONVEYANCE SYSTEM DESIGN MAY CHANGE DURING FINAL DESIGN IF CONFLICTS WITH EXISTING UTILITIES.
3. PERMEABLE PAVEMENT (POROUS HMA) IS PROPOSED FOR THE PROPOSED TRAIL SURFACE FOR ALL AREAS WHERE INFILTRATION IS LIKELY TO BE FEASIBLE. FURTHER GEOTECHNICAL INVESTIGATION IS REQUIRED TO CONFIRM WHETHER OR NOT THE UNDERLYING SOILS HAVE SUITABLE INFILTRATION RATES TO SUPPORT POROUS HMA. FOR THE DRAFT 30 PERCENT DESIGN PLANS, AREAS ADJACENT TO WETLANDS A, G AND H ARE PROPOSED TO USE CONVENTIONAL HMA UNTIL FURTHER GEOTECHNICAL INVESTIGATION IS PERFORMED TO CONFIRM IF UNDERLYING SOIL TYPES AND GROUNDWATER ELEVATIONS ARE SUITABLE TO INSTALL PERMEABLE PAVEMENT.

LEGEND:

- | | |
|--|-------------------------------|
| | IMPERVIOUS HMA TRAIL PAVEMENT |
| | POROUS HMA TRAIL PAVEMENT |
| | BOARDWALK |

30 % REVIEW SUBMITTAL
NOT FOR CONSTRUCTION

PLAN AND PROFILE

SHEET NO.
15 OF 33

AL9

REVISIONS	DATE	BY	DESIGNED
			J. JUN
			DRAWN
			B. PURGANAN
			CHECKED
			Y. HO
			APPROVED
			J. DVORAK

ONE INCH AT FULL SCALE. IF NOT, SCALE ACCORDINGLY
FILE NAME PS1521151P2CT2T2AL-01
JOB No. 554-1521-151 P2C T2T200C
DATE MARCH 2017



Parametrix
ENGINEERING · PLANNING · ENVIRONMENTAL SCIENCES

719 2ND AVENUE, SUITE 200 | SEATTLE, WA 98104
P 206.394.3700
WWW.PARAMETRIX.COM

PROJECT NAME

LAKE TO SOUND TRAIL
SEGMENT C

FROM S 200TH ST TO S NORMANDY ROAD /
DES MOINES MEMORIAL DRIVE INTERSECTION

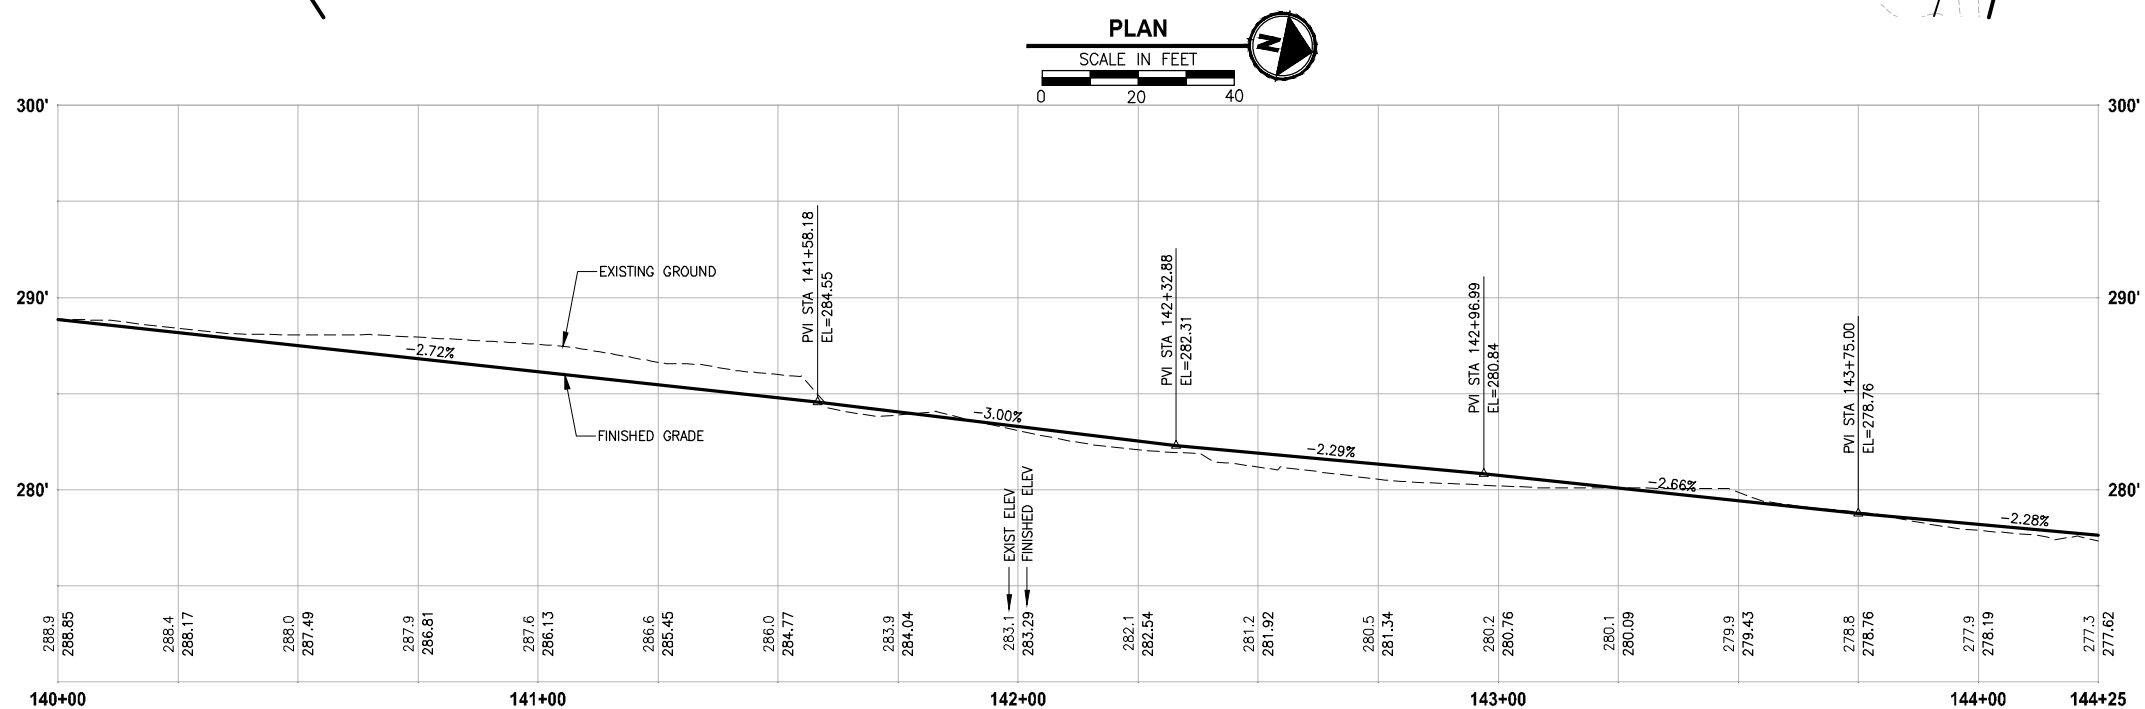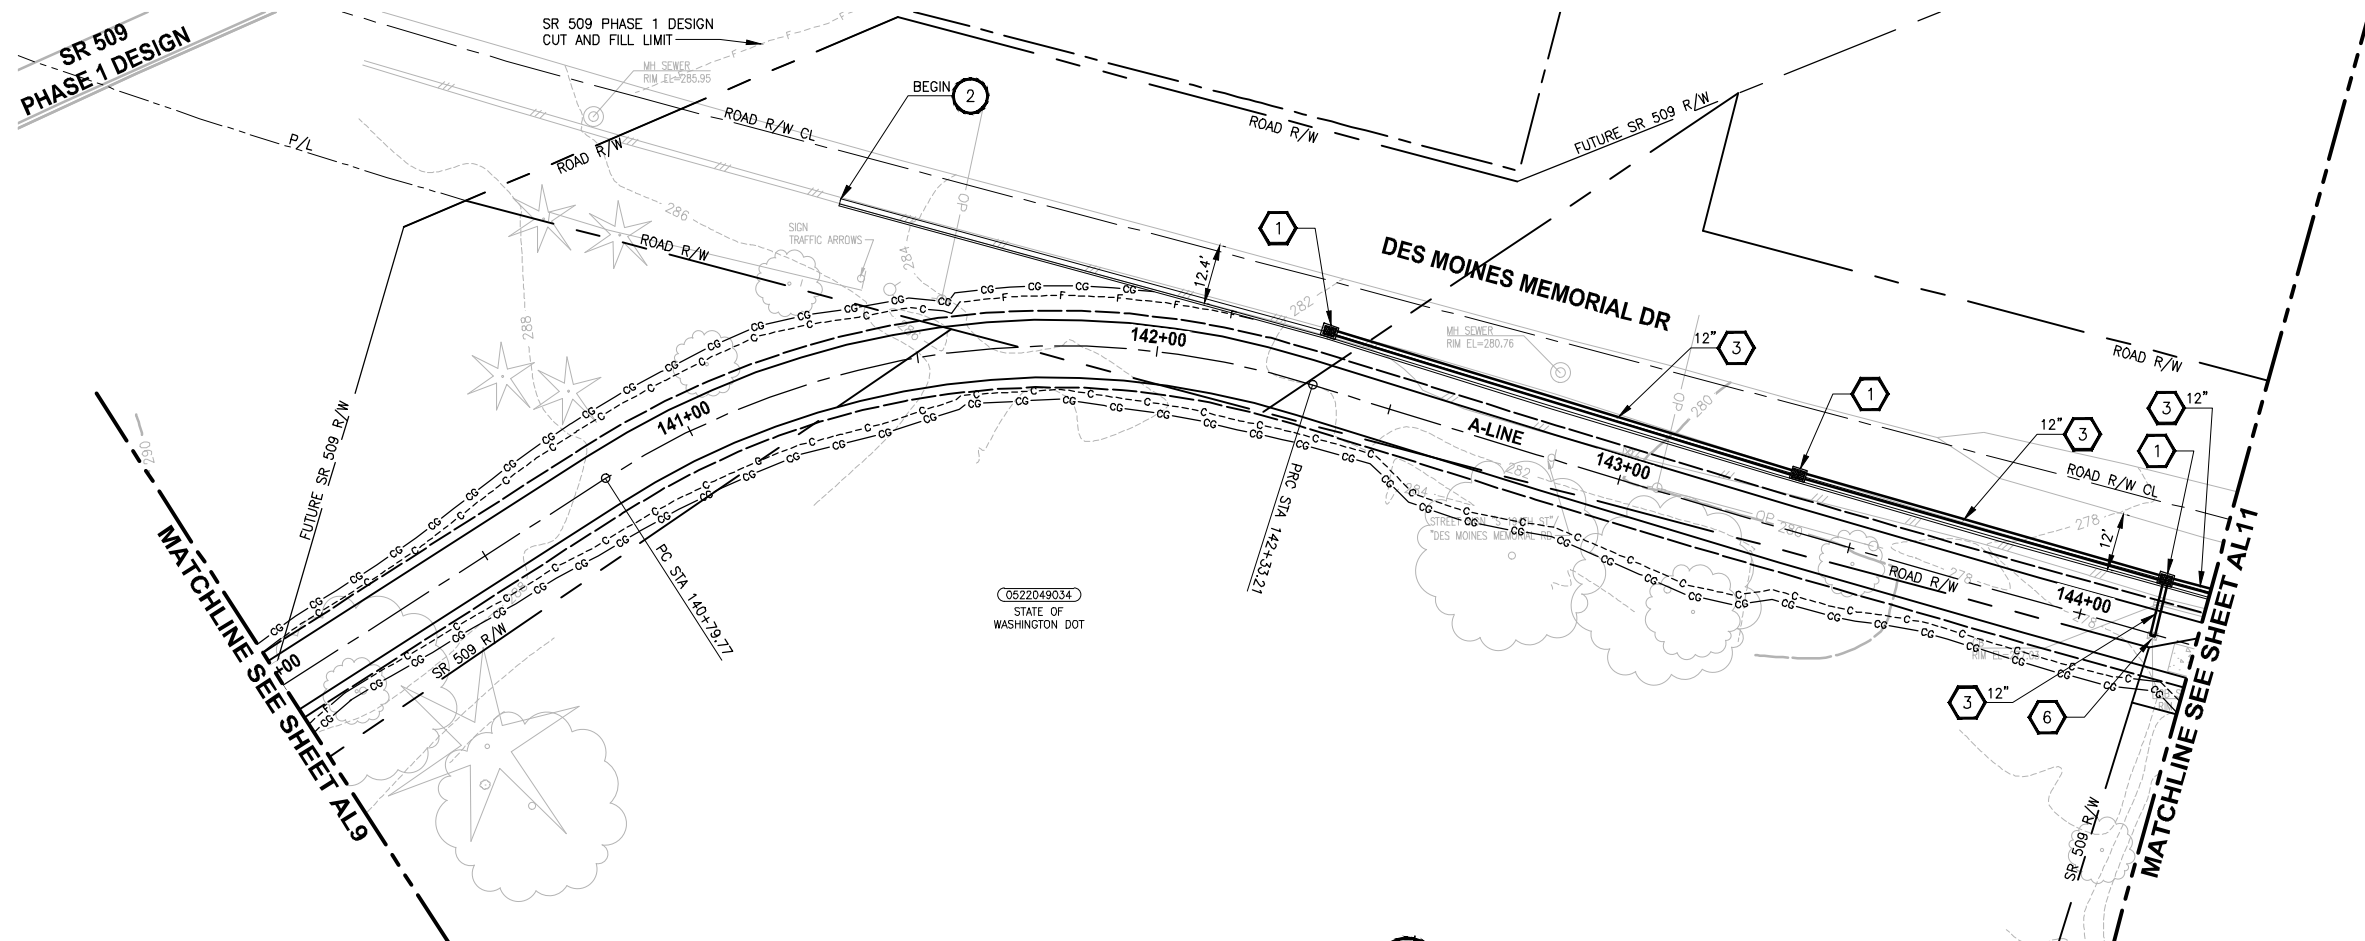

PROFILE

HORIZ: 1"=20'
VERT: 1"=5'

▷	REVISIONS	DATE	BY	DESIGNED J. JUN
				DRAWN B. PURGANAN
				CHECKED Y. HO
				APPROVED J. DVORAK

ONE INCH AT FULL SCALE.
IF NOT, SCALE ACCORDINGLY

FILE NAME
PS1521151P2CT2T2AL-01
JOB No.
554-1521-151 P2C T2T200C
DATE
MARCH 2017

Parametrix
ENGINEERING . PLANNING . ENVIRONMENTAL SCIENCES

719 2ND AVENUE, SUITE 200 | SEATTLE, WA 98104
P 206.394.3700
WWW.PARAMETRIX.COM

PROJECT NAME

**LAKE TO SOUND TRAIL
SEGMENT C**

FROM S 200TH ST TO S NORMANDY ROAD /
DES MOINES MEMORIAL DRIVE INTERSECTION

PLAN AND PROFILE

30 % REVIEW SUBMITTAL
NOT FOR CONSTRUCTION

SHEET NO.
16 OF 33

AL10

CIVIL CONSTRUCTION NOTES:

1. INSTALL RETAINING WALL.
2. CEMENT CONCRETE CURB AND GUTTER PER WSDOT STD PLAN F-10.12-03.
3. CEMENT CONCRETE DRIVEWAY ENTRANCE TYPE 3 PER WSDOT STD PLAN F-80.10-03.
4. PERPENDICULAR CURB RAMP PER WSDOT STD PLAN F-40.15-03.
5. MOUNTABLE CEMENT CONCRETE TRAFFIC CURB PER WSDOT STD PLAN F-10.12-03.
6. RAISED TRAFFIC ISLAND.
7. ELEVATED STRUCTURE.
8. BUS LANDING PAD.
9. CROSSWALK PER WSDOT STD PLAN M-15.10-01.
10. ASPHALT RAMP TRANSITION TO EXISTING GROUND.

STORMWATER CONSTRUCTION NOTES:

- 1 CATCH BASIN TYPE 1 PER WSDOT STD PLAN B-5.20-01.
- 2 CATCH BASIN TYPE 2 PER WSDOT STD PLAN B-10.20-01.
- 3 SCHEDULE A STORM SEWER PIPE.
- 4 SCHEDULE A CULVERT PIPE.
- 5 ADJUST MANHOLE/CATCH BASIN.
- 6 ADJUST MANHOLE AND REPLACE WITH SLIP RESISTANT LIDS.
- 7 INFILTRATION TRENCH.
- 8 UNDERDRAIN TRENCH.
- 9 UNDERDRAIN TRENCH CLEANOUT.
- 10 CONCRETE COLLAR FOR CULVERT CONNECTION.



STORMWATER GENERAL NOTES:

1. POTENTIAL LOCATIONS AND APPROXIMATE SIZES FOR STORMWATER PONDS A AND B FOOTPRINTS ARE SHOWN FOR REVIEW. GRADING AND DETAILED CONVEYANCE PIPES WILL BE DESIGNED IN LATER SUBMITTAL.
2. STORMWATER CONVEYANCE SYSTEMS DEPICTED IN THE DRAFT 30 PERCENT PLANS ARE FOR PRELIMINARY DESIGN PURPOSES. STORMWATER CONVEYANCE SYSTEM DESIGN MAY CHANGE DURING FINAL DESIGN IF CONFLICTS WITH EXISTING UTILITIES.
3. PERMEABLE PAVEMENT (POROUS HMA) IS PROPOSED FOR THE PROPOSED TRAIL SURFACE FOR ALL AREAS WHERE INFILTRATION IS LIKELY TO BE FEASIBLE. FURTHER GEOTECHNICAL INVESTIGATION IS REQUIRED TO CONFIRM WHETHER OR NOT THE UNDERLYING SOILS HAVE SUITABLE INFILTRATION RATES TO SUPPORT POROUS HMA. FOR THE DRAFT 30 PERCENT DESIGN PLANS, AREAS ADJACENT TO WETLANDS A, G AND H ARE PROPOSED TO USE CONVENTIONAL HMA UNTIL FURTHER GEOTECHNICAL INVESTIGATION IS PERFORMED TO CONFIRM IF UNDERLYING SOIL TYPES AND GROUNDWATER ELEVATIONS ARE SUITABLE TO INSTALL PERMEABLE PAVEMENT.

LEGEND:

Diagram illustrating three types of pavement:

- IMPERVIOUS HMA TRAIL PAVEMENT
- POROUS HMA TRAIL PAVEMENT
- BOARDWALK

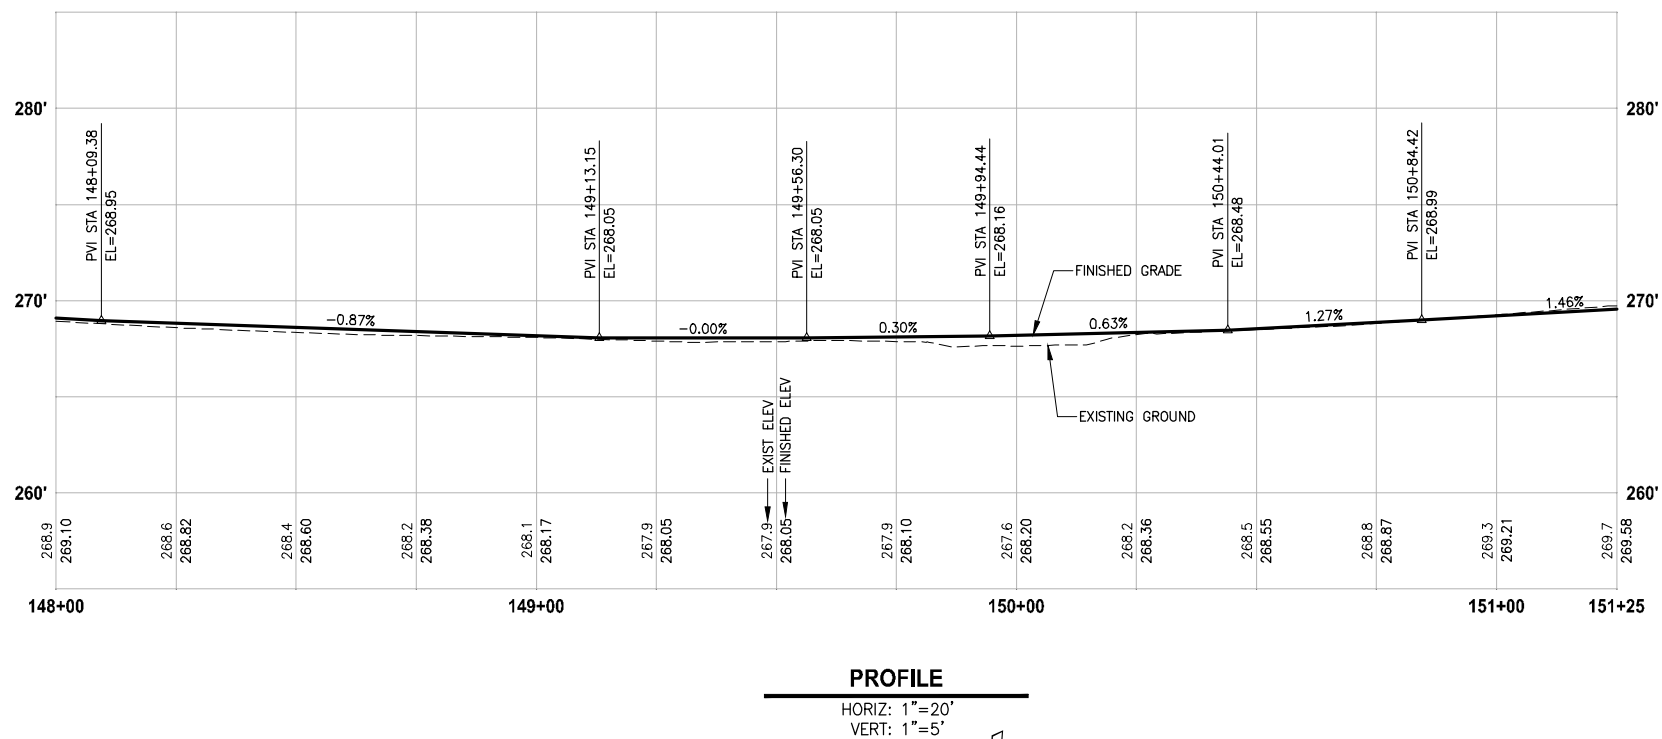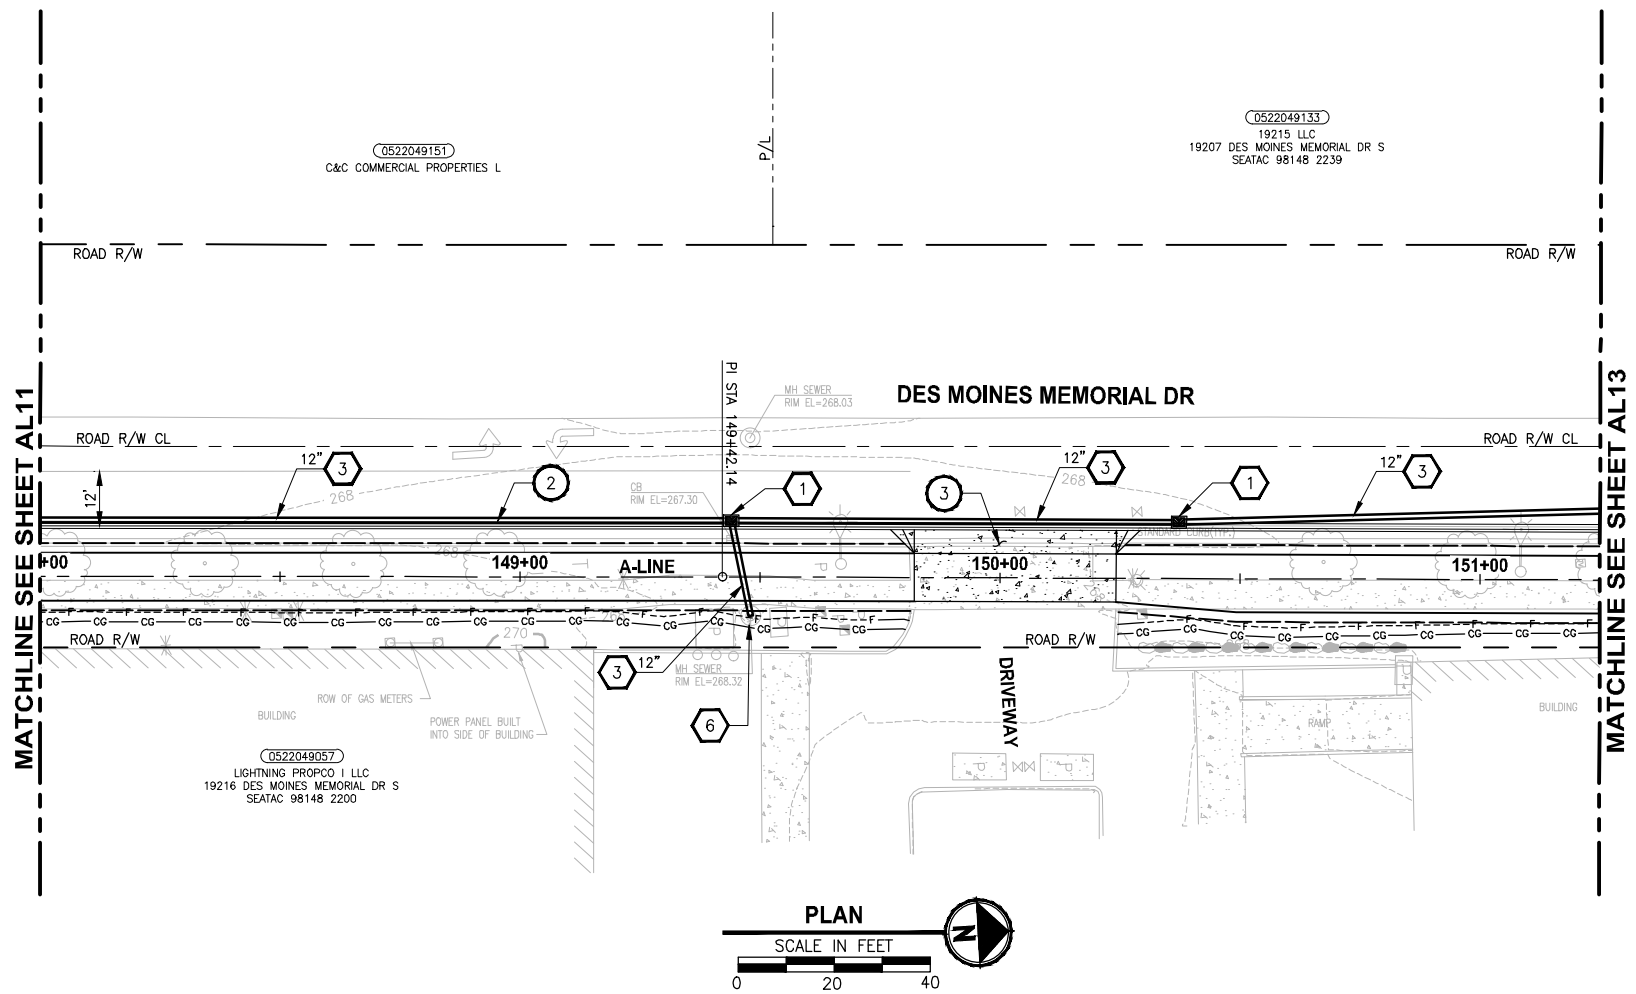

CIVIL CONSTRUCTION NOTES:

1. INSTALL RETAINING WALL.
2. CEMENT CONCRETE CURB AND GUTTER PER WSDOT STD PLAN F-10.12-03.
3. CEMENT CONCRETE DRIVEWAY ENTRANCE TYPE 3 PER WSDOT STD PLAN F-80.10-03.
4. PERPENDICULAR CURB RAMP PER WSDOT STD PLAN F-40.15-03.
5. MOUNTABLE CEMENT CONCRETE TRAFFIC CURB PER WSDOT STD PLAN F-10.12-03.
6. RAISED TRAFFIC ISLAND.
7. ELEVATED STRUCTURE.
8. BUS LANDING PAD.
9. CROSSWALK PER WSDOT STD PLAN M-15.10-01.
10. ASPHALT RAMP TRANSITION TO EXISTING GROUND.

STORMWATER CONSTRUCTION NOTES:

- 1 CATCH BASIN TYPE 1 PER WSDOT STD PLAN B-5.20-01.
- 2 CATCH BASIN TYPE 2 PER WSDOT STD PLAN B-10.20-01.
- 3 SCHEDULE A STORM SEWER PIPE.
- 4 SCHEDULE A CULVERT PIPE.
- 5 ADJUST MANHOLE/CATCH BASIN.
- 6 ADJUST MANHOLE AND REPLACE WITH SLIP RESISTANT LIDS.
- 7 INFILTRATION TRENCH.
- 8 UNDERDRAIN TRENCH.
- 9 UNDERDRAIN TRENCH CLEANOUT.
- 10 CONCRETE COLLAR FOR CULVERT CONNECTION.

STORMWATER GENERAL NOTES:

1. POTENTIAL LOCATIONS AND APPROXIMATE SIZES FOR STORMWATER PONDS A AND B FOOTPRINTS ARE SHOWN FOR REVIEW. GRADING AND DETAILED CONVEYANCE PIPES WILL BE DESIGNED IN LATER SUBMITTAL.
2. STORMWATER CONVEYANCE SYSTEMS DEPICTED IN THE DRAFT 30 PERCENT PLANS ARE FOR PRELIMINARY DESIGN PURPOSES. STORMWATER CONVEYANCE SYSTEM DESIGN MAY CHANGE DURING FINAL DESIGN IF CONFLICTS WITH EXISTING UTILITIES.
3. PERMEABLE PAVEMENT (POROUS HMA) IS PROPOSED FOR THE PROPOSED TRAIL SURFACE FOR ALL AREAS WHERE INFILTRATION IS LIKELY TO BE FEASIBLE. FURTHER GEOTECHNICAL INVESTIGATION IS REQUIRED TO CONFIRM WHETHER OR NOT THE UNDERLYING SOILS HAVE SUITABLE INFILTRATION RATES TO SUPPORT POROUS HMA. FOR THE DRAFT 30 PERCENT DESIGN AREAS ADJACENT TO WETLANDS A, C AND H ARE PROPOSED TO USE CONVENTIONAL HMA UNTIL FURTHER GEOTECHNICAL INVESTIGATION IS PERFORMED TO CONFIRM IF UNDERLYING SOIL TYPES AND GROUNDWATER ELEVATIONS ARE SUITABLE TO INSTALL PERMEABLE PAVEMENT.

LEGEND:

Diagram illustrating three types of pavement cross-sections:

- IMPERVIOUS HMA TRAIL PAVEMENT
- POROUS HMA TRAIL PAVEMENT
- BOARDWALK

30 % REVIEW SUBMITTAL
NOT FOR CONSTRUCTION

PLAN AND PROFILE

SHEET NO.
8 OF 33

AL12

▷	REVISIONS	DATE	BY	DESIGNED J. JUN
				DRAWN B. PURGANAN
				CHECKED Y. HO
				APPROVED J. DVORAK

ONE INCH AT FULL SCALE.
IF NOT, SCALE ACCORDINGLY.

FILE NAME
PS1521151P2CT2T2AL-01

JOB No.
554-1521-151 P2C T2T200C

DATE
MARCH 2017



PRELIMINARY



PROJECT NAME

**LAKE TO SOUND TRAIL
SEGMENT C**

FROM S 200TH ST TO S NORMANDY ROAD /
DES MOINES MEMORIAL DRIVE INTERSECTION

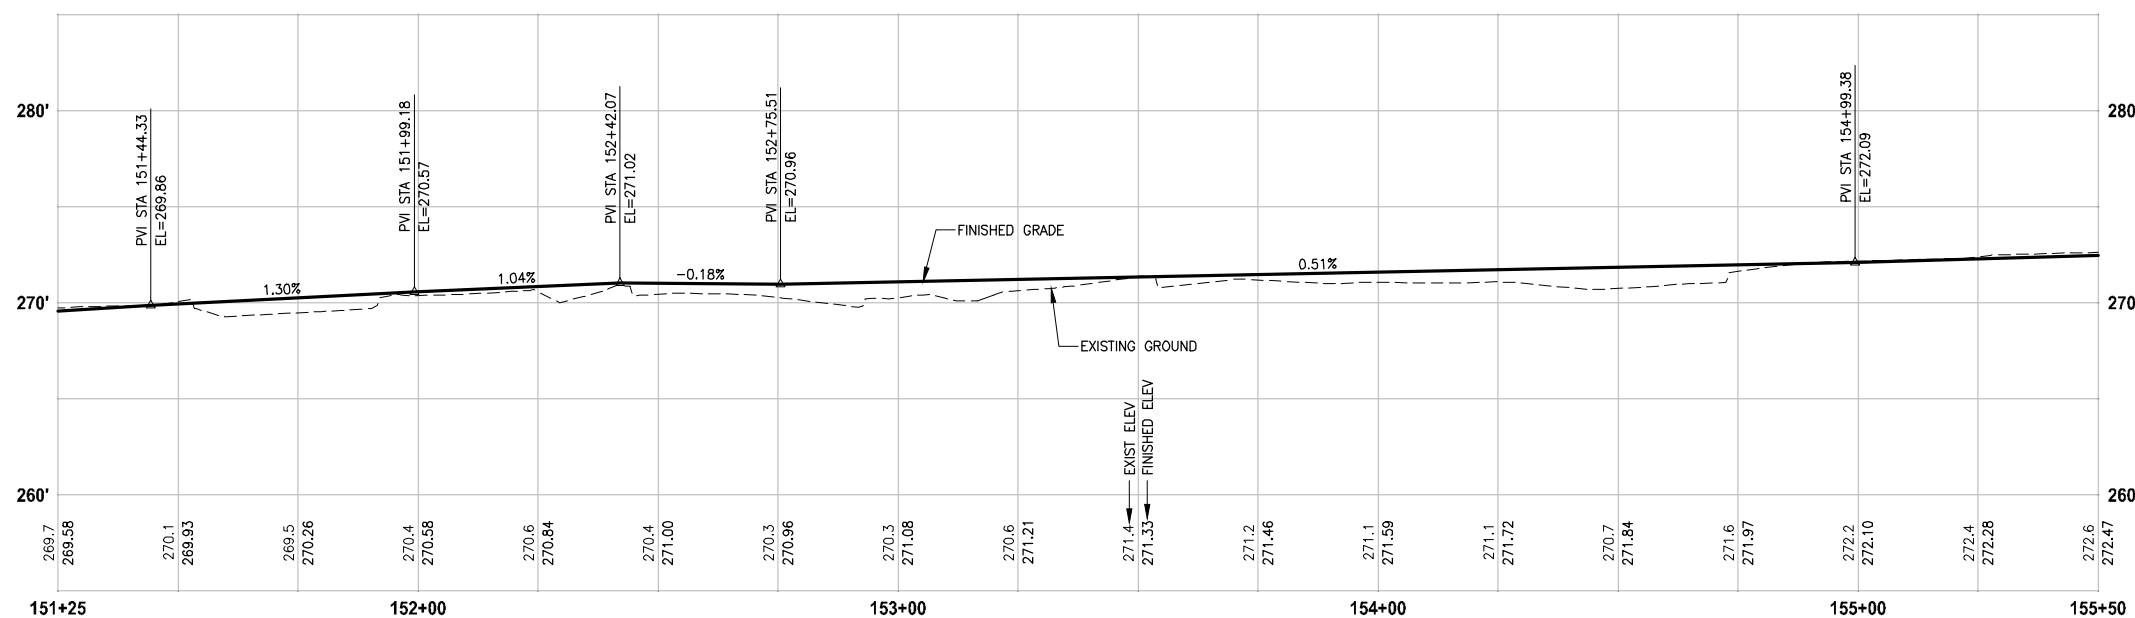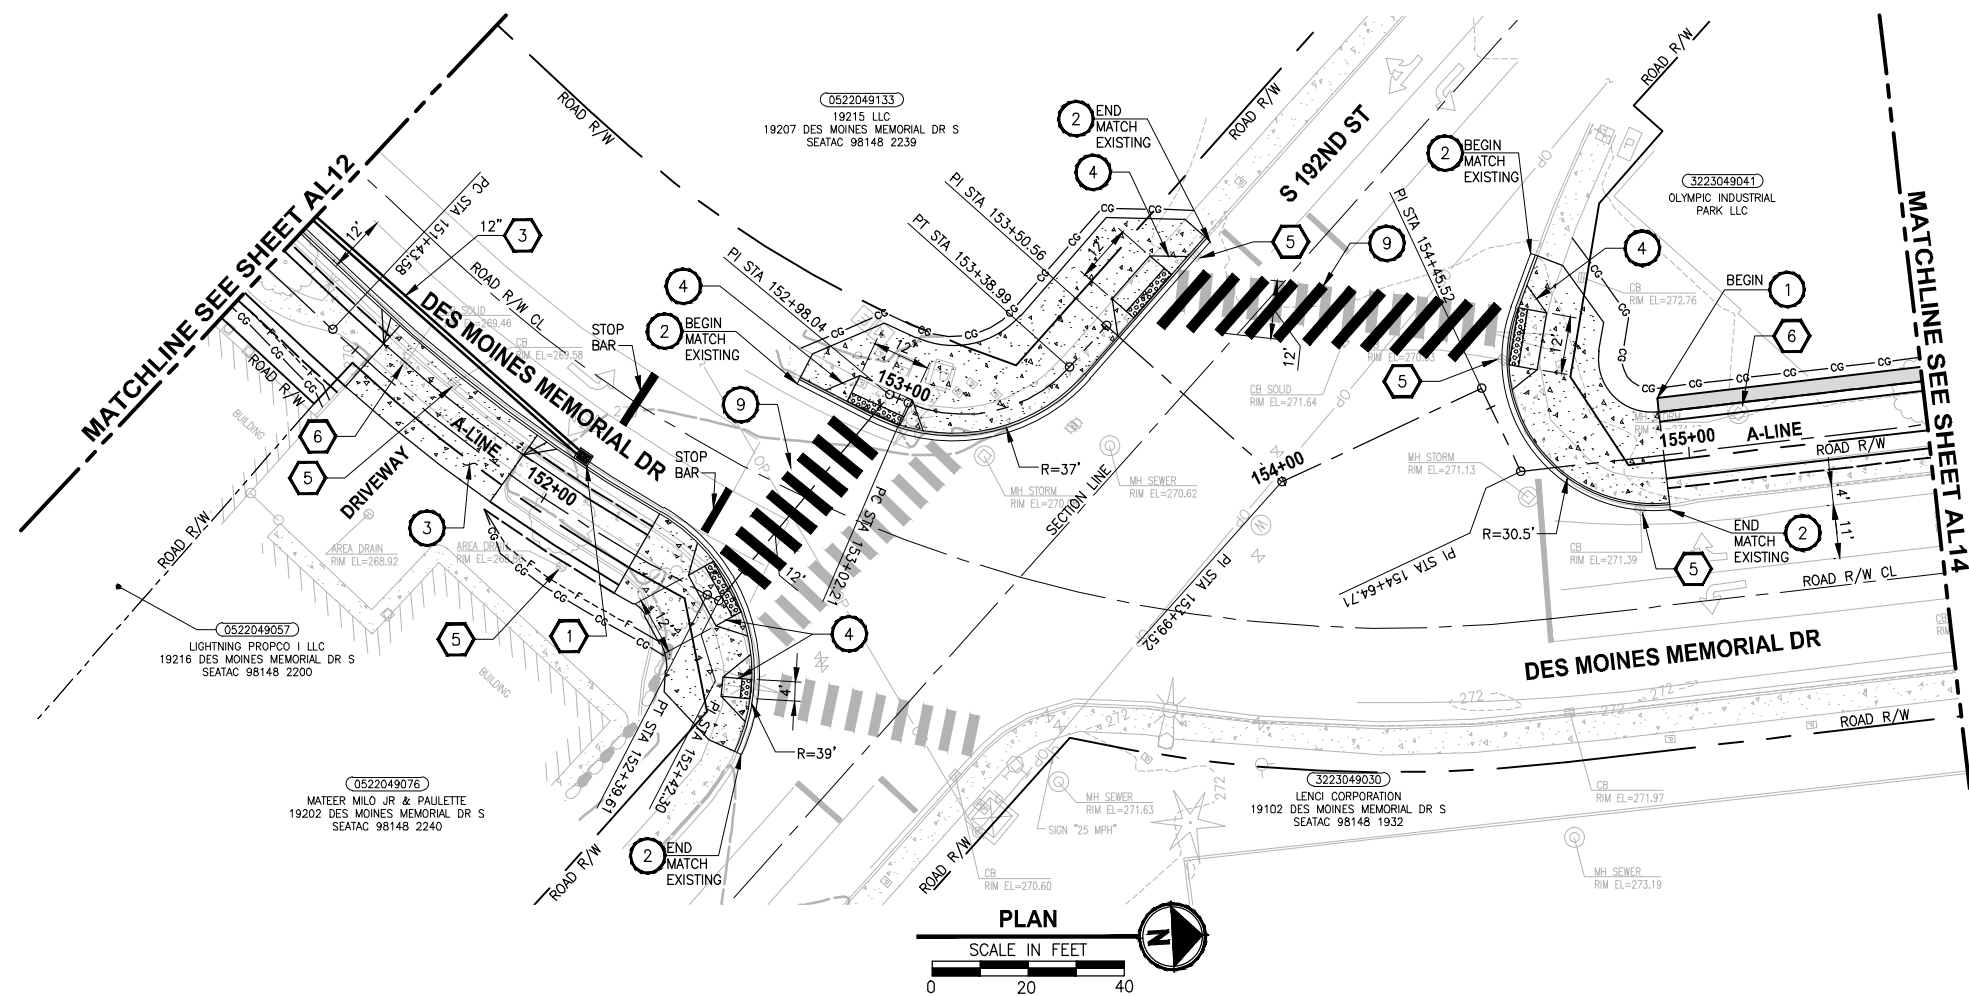

PROFILE

HORIZ: 1"=20'
VERT: 1"=5'

VERT: 1"=5'

PRELIMINARY

Parametrix
ENGINEERING . PLANNING . ENVIRONMENTAL SCIENCES

719 2ND AVENUE, SUITE 200 | SEATTLE, WA 98104
P 206.394.3700
WWW.PARAMETRIX.COM

PROJECT NAME

**LAKE TO SOUND TRAIL
SEGMENT C**

FROM S 200TH ST TO S NORMANDY ROAD /
DES MOINES MEMORIAL DRIVE INTERSECTION

CIVIL CONSTRUCTION NOTES:

1. INSTALL RETAINING WALL.
2. CEMENT CONCRETE CURB AND GUTTER PER WSDOT STD PLAN F-10.12-03.
3. CEMENT CONCRETE DRIVEWAY ENTRANCE TYPE 3 PER WSDOT STD PLAN F-80.10-03.
4. PERPENDICULAR CURB RAMP PER WSDOT STD PLAN F-40.15-03.
5. MOUNTABLE CEMENT CONCRETE TRAFFIC CURB PER WSDOT STD PLAN F-10.12-03.
6. RAISED TRAFFIC ISLAND.
7. ELEVATED STRUCTURE.
8. BUS LANDING PAD.
9. CROSSWALK PER WSDOT STD PLAN M-15.10-01.
10. ASPHALT RAMP TRANSITION TO EXISTING GROUND.

STORMWATER CONSTRUCTION NOTES:

- 1 CATCH BASIN TYPE 1 PER WSDOT STD PLAN B-5.20-01.
- 2 CATCH BASIN TYPE 2 PER WSDOT STD PLAN B-10.20-01.
- 3 SCHEDULE A STORM SEWER PIPE.
- 4 SCHEDULE A CULVERT PIPE.
- 5 ADJUST MANHOLE/CATCH BASIN.
- 6 ADJUST MANHOLE AND REPLACE WITH SLIP RESISTANT LIDS.
- 7 INFILTRATION TRENCH.
- 8 UNDERDRAIN TRENCH.
- 9 UNDERDRAIN TRENCH CLEANOUT.
- 10 CONCRETE COLLAR FOR CULVERT CONNECTION.

STORMWATER GENERAL NOTES:

1. POTENTIAL LOCATIONS AND APPROXIMATE SIZES FOR STORMWATER PONDS A AND B FOOTPRINTS ARE SHOWN FOR REVIEW. GRADING AND DETAILED CONVEYANCE PIPES WILL BE DESIGNED IN LATER SUBMITTAL.
2. STORMWATER CONVEYANCE SYSTEMS DEPICTED IN THE DRAFT 30 PERCENT PLANS ARE FOR PRELIMINARY DESIGN PURPOSES. STORMWATER CONVEYANCE SYSTEM DESIGN MAY CHANGE DURING FINAL DESIGN IF CONFLICTS WITH EXISTING UTILITIES.
3. PERMEABLE PAVEMENT (POROUS HMA) IS PROPOSED FOR THE PROPOSED TRAIL SURFACE FOR ALL AREAS WHERE INFILTRATION IS LIKELY TO BE FEASIBLE. FURTHER GEOTECHNICAL INVESTIGATION IS REQUIRED TO CONFIRM WHETHER OR NOT THE UNDERLYING SOILS HAVE SUITABLE INFILTRATION RATES TO SUPPORT POROUS HMA. FOR THE DRAFT 30 PERCENT DESIGN PLANS, AREAS ADJACENT TO WETLANDS A, G AND H ARE PROPOSED TO USE CONVENTIONAL HMA UNTIL FURTHER GEOTECHNICAL INVESTIGATION IS PERFORMED TO CONFIRM IF UNDERLYING SOIL TYPES AND GROUNDWATER ELEVATIONS ARE SUITABLE TO INSTALL PERMEABLE PAVEMENT.

LEGEND:

	IMPERVIOUS HMA TRAIL PAVEMENT
	POROUS HMA TRAIL PAVEMENT
	BOARDWALK



30 % REVIEW SUBMITTAL
NOT FOR CONSTRUCTION

PLAN AND PROFILE

SHEET NO.
19 OF 33

AL13

PATH: U:\PSO\Projects\1521-KingCA\554-1521-151 L2ST-SegC\985vcs\CADD\Phase 2C\Task 21200C\DWG LAYOUT: AL14 PLOTTED BY: purgubut DATE: Thursday, March 09, 2017 4:56:12 PM

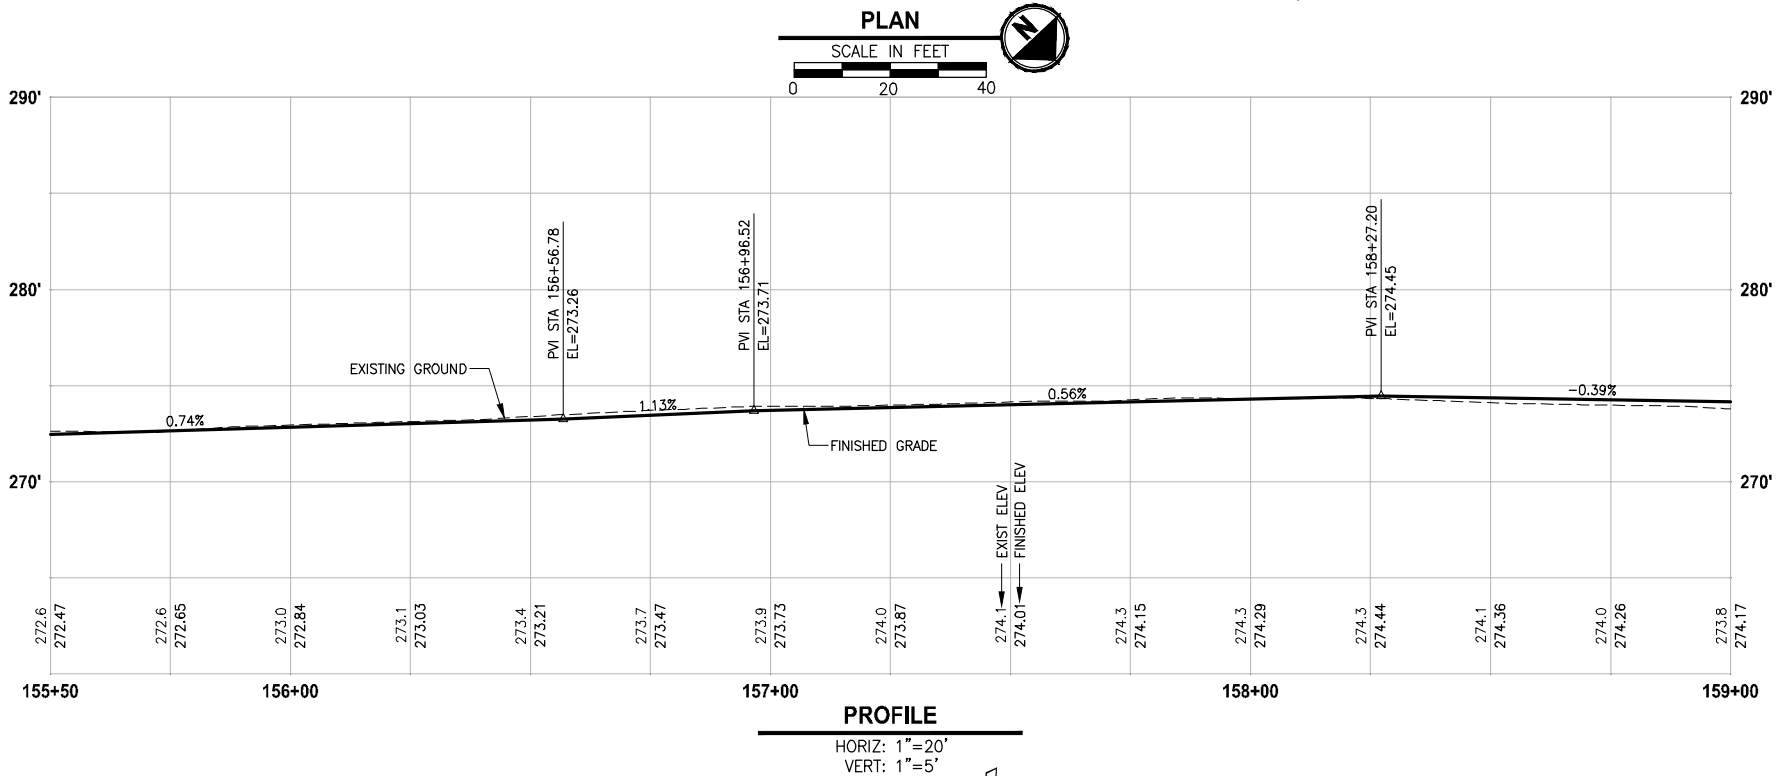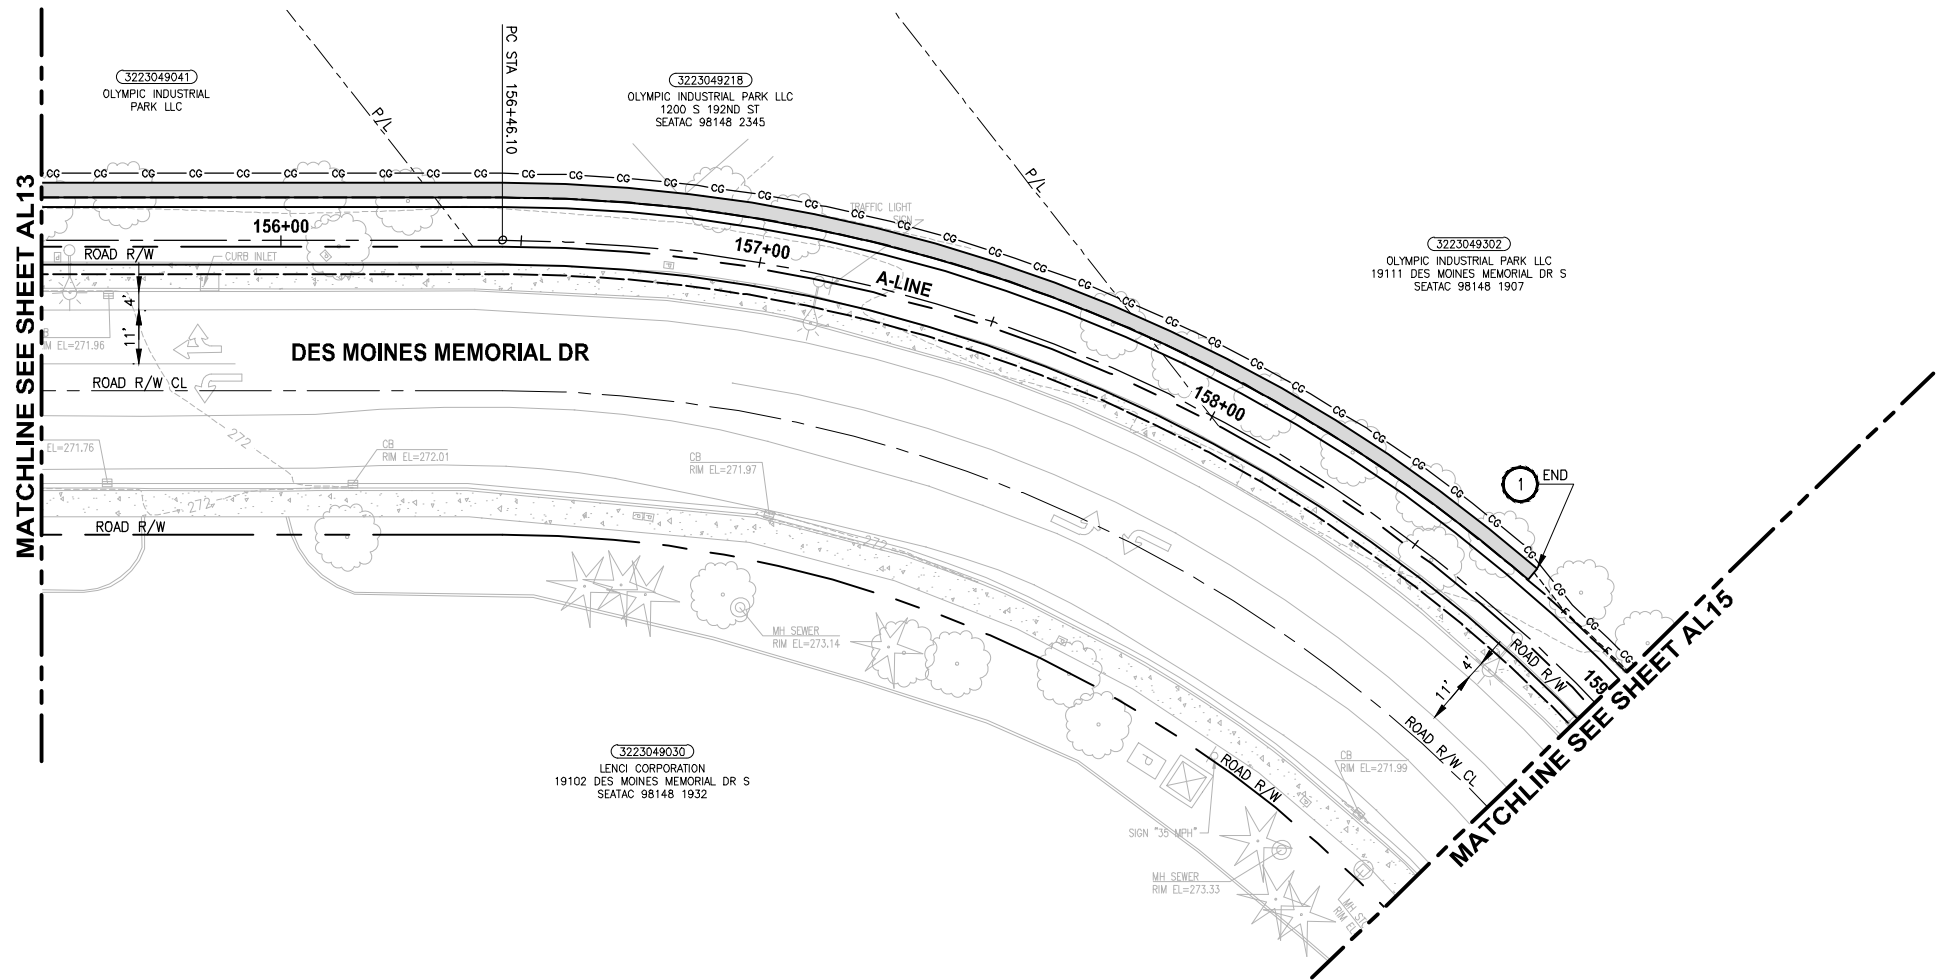

CIVIL CONSTRUCTION NOTES:

1. INSTALL RETAINING WALL.
2. CEMENT CONCRETE CURB AND GUTTER PER WSDOT STD PLAN F-10.12-03.
3. CEMENT CONCRETE DRIVEWAY ENTRANCE TYPE 3 PER WSDOT STD PLAN F-80.10-03.
4. PERPENDICULAR CURB RAMP PER WSDOT STD PLAN F-40.15-03.
5. MOUNTABLE CEMENT CONCRETE TRAFFIC CURB PER WSDOT STD PLAN F-10.12-03.
6. RAISED TRAFFIC ISLAND.
7. ELEVATED STRUCTURE.
8. BUS LANDING PAD.
9. CROSSWALK PER WSDOT STD PLAN M-15.10-01.
10. ASPHALT RAMP TRANSITION TO EXISTING GROUND.

STORMWATER CONSTRUCTION NOTES:

1. CATCH BASIN TYPE 1 PER WSDOT STD PLAN B-5.20-01.
2. CATCH BASIN TYPE 2 PER WSDOT STD PLAN B-10.20-01.
3. SCHEDULE A STORM SEWER PIPE.
4. SCHEDULE A CULVERT PIPE.
5. ADJUST MANHOLE/CATCH BASIN.
6. ADJUST MANHOLE AND REPLACE WITH SLIP RESISTANT LIDS.
7. INFILTRATION TRENCH.
8. UNDERDRAIN TRENCH.
9. UNDERDRAIN TRENCH CLEANOUT.
10. CONCRETE COLLAR FOR CULVERT CONNECTION.

STORMWATER GENERAL NOTES:

1. POTENTIAL LOCATIONS AND APPROXIMATE SIZES FOR STORMWATER PONDS A AND B FOOTPRINTS ARE SHOWN FOR REVIEW. GRADING AND DETAILED CONVEYANCE PIPES WILL BE DESIGNED IN LATER SUBMITTAL.
2. STORMWATER CONVEYANCE SYSTEMS DEPICTED IN THE DRAFT 30 PERCENT PLANS ARE FOR PRELIMINARY DESIGN PURPOSES. STORMWATER CONVEYANCE SYSTEM DESIGN MAY CHANGE DURING FINAL DESIGN IF CONFLICTS WITH EXISTING UTILITIES.
3. PERMEABLE PAVEMENT (POROUS HMA) IS PROPOSED FOR THE PROPOSED TRAIL SURFACE FOR ALL AREAS WHERE INFILTRATION IS LIKELY TO BE FEASIBLE. FURTHER GEOTECHNICAL INVESTIGATION IS REQUIRED TO CONFIRM WHETHER OR NOT THE UNDERLYING SOILS HAVE SUITABLE INFILTRATION RATES TO SUPPORT POROUS HMA. FOR THE DRAFT 30 PERCENT DESIGN PLANS, AREAS ADJACENT TO WETLANDS A, G AND H ARE PROPOSED TO USE CONVENTIONAL HMA UNTIL FURTHER GEOTECHNICAL INVESTIGATION IS PERFORMED TO CONFIRM IF UNDERLYING SOIL TYPES AND GROUNDWATER ELEVATIONS ARE SUITABLE TO INSTALL PERMEABLE PAVEMENT.

LEGEND:

	IMPERVIOUS HMA TRAIL PAVEMENT
	POROUS HMA TRAIL PAVEMENT
	BOARDWALK

30 % REVIEW SUBMITTAL
NOT FOR CONSTRUCTION

REVISIONS	DATE	BY	DESIGNED
			J. JUN
			B. PURGANAN
			Y. HO
			J. DVORAK

ONE INCH AT FULL SCALE. IF NOT, SCALE ACCORDINGLY
FILE NAME PS1521151P2CT2T2AL-01
JOB No. 584-1521-151 P2C T2T200C
DATE MARCH 2017



PRELIMINARY

Parametrix ENGINEERING · PLANNING · ENVIRONMENTAL SCIENCES
719 2ND AVENUE, SUITE 200 SEATTLE, WA 98104 P 206.394.3700 WWW.PARAMETRIX.COM

PROJECT NAME
LAKE TO SOUND TRAIL SEGMENT C
FROM S 200TH ST TO S NORMANDY ROAD / DES MOINES MEMORIAL DRIVE INTERSECTION

PLAN AND PROFILE

SHEET NO. 20 OF 33
AL14

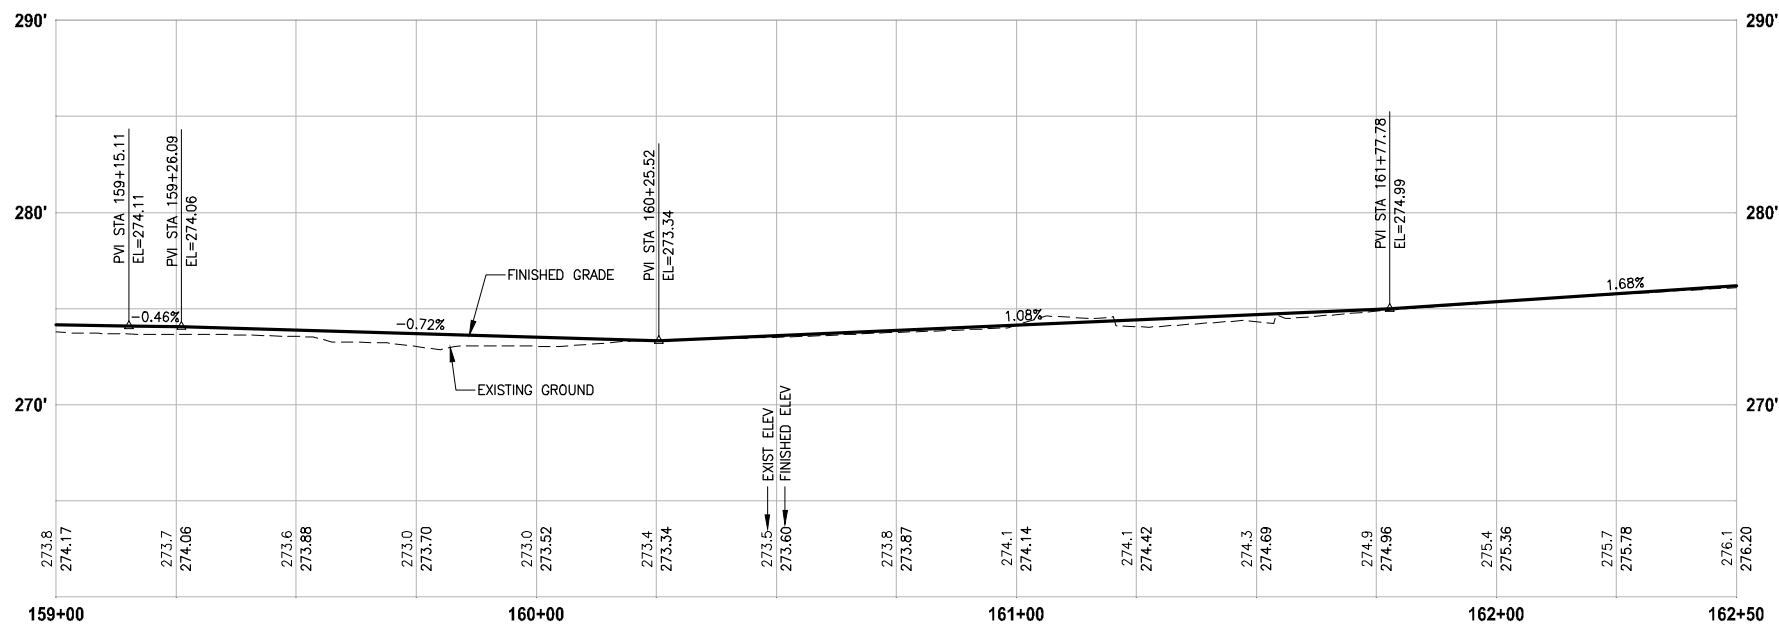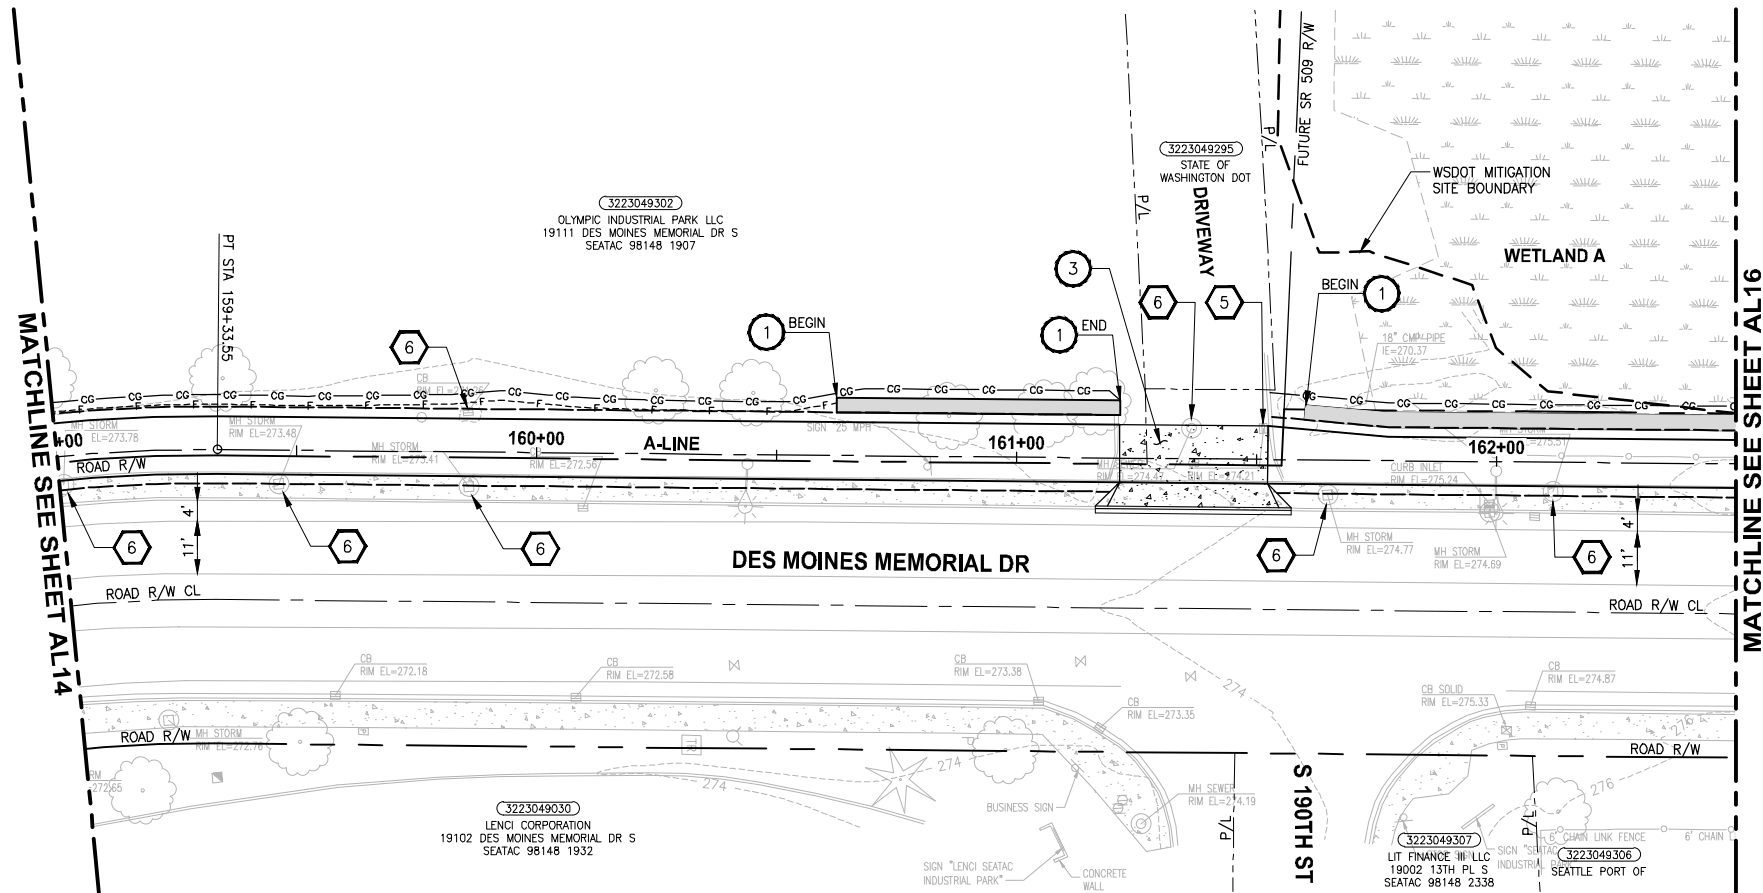

PROFILE

HORIZ: 1"=20'
VERT: 1"=5'

▷	REVISIONS	DATE	BY	DESIGNED J. JUN
				DRAWN B. PURGANAN
				CHECKED Y. HO
				APPROVED J. DVORAK

ONE INCH AT FULL SCALE.
IF NOT, SCALE ACCORDINGLY.

FILE NAME
PS1521151P2CT2T2AL-01

JOB No.
554-1521-151 P2C T2T200C

DATE
MARCH 2017

PRELIMINARY



PROJECT NAME

**LAKE TO SOUND TRAIL
SEGMENT C**

FROM S 200TH ST TO S NORMANDY ROAD /
DES MOINES MEMORIAL DRIVE INTERSECTION

PLAN AND PROFILE

30 % REVIEW SUBMITTAL
NOT FOR CONSTRUCTION

SHEET NO.
21 OF 33

AL15

CIVIL CONSTRUCTION NOTES:

1. INSTALL RETAINING WALL.
2. CEMENT CONCRETE CURB AND GUTTER PER WSDOT STD PLAN F-10.12-03.
3. CEMENT CONCRETE DRIVEWAY ENTRANCE TYPE 3 PER WSDOT STD PLAN F-80.10-03.
4. PERPENDICULAR CURB RAMP PER WSDOT STD PLAN F-40.15-03.
5. MOUNTABLE CEMENT CONCRETE TRAFFIC CURB PER WSDOT STD PLAN F-10.12-03.
6. RAISED TRAFFIC ISLAND.
7. ELEVATED STRUCTURE.
8. BUS LANDING PAD.
9. CROSSWALK PER WSDOT STD PLAN M-15.10-01.
10. ASPHALT RAMP TRANSITION TO EXISTING GROUND.


STORMWATER CONSTRUCTION NOTES:

1. CATCH BASIN TYPE 1 PER WSDOT STD PLAN B-5.20-01.
2. CATCH BASIN TYPE 2 PER WSDOT STD PLAN B-10.20-01.
3. SCHEDULE A STORM SEWER PIPE.
4. SCHEDULE A CULVERT PIPE.
5. ADJUST MANHOLE/CATCH BASIN.
6. ADJUST MANHOLE AND REPLACE WITH SLIP RESISTANT LIDS.
7. INFILTRATION TRENCH.
8. UNDERDRAIN TRENCH.
9. UNDERDRAIN TRENCH CLEANOUT.
10. CONCRETE COLLAR FOR CULVERT CONNECTION.

STORMWATER GENERAL NOTES:

1. POTENTIAL LOCATIONS AND APPROXIMATE SIZES FOR STORMWATER PONDS A AND B FOOTPRINTS ARE SHOWN FOR REVIEW. GRADING AND DETAILED CONVEYANCE PIPES WILL BE DESIGNED IN LATER SUBMITTAL.
2. STORMWATER CONVEYANCE SYSTEMS DEPICTED IN THE DRAFT 30 PERCENT PLANS ARE FOR PRELIMINARY DESIGN PURPOSES. STORMWATER CONVEYANCE SYSTEM DESIGN MAY CHANGE DURING FINAL DESIGN IF CONFLICTS WITH EXISTING UTILITIES.
3. PERMEABLE PAVEMENT (POROUS HMA) IS PROPOSED FOR THE PROPOSED TRAIL SURFACE FOR ALL AREAS WHERE INFILTRATION IS LIKELY TO BE FEASIBLE. FURTHER GEOTECHNICAL INVESTIGATION IS REQUIRED TO CONFIRM WHETHER OR NOT THE UNDERLYING SOILS HAVE SUITABLE INFILTRATION RATES TO SUPPORT POROUS HMA. FOR THE DRAFT 30 PERCENT DESIGN PLANS, AREAS ADJACENT TO WETLANDS A, C AND H ARE PROPOSED TO USE CONVENTIONAL HMA UNTIL FURTHER GEOTECHNICAL INVESTIGATION IS PERFORMED TO CONFIRM IF UNDERLYING SOIL TYPES AND GROUNDWATER ELEVATIONS ARE SUITABLE TO INSTALL PERMEABLE PAVEMENT.

LEGEND:

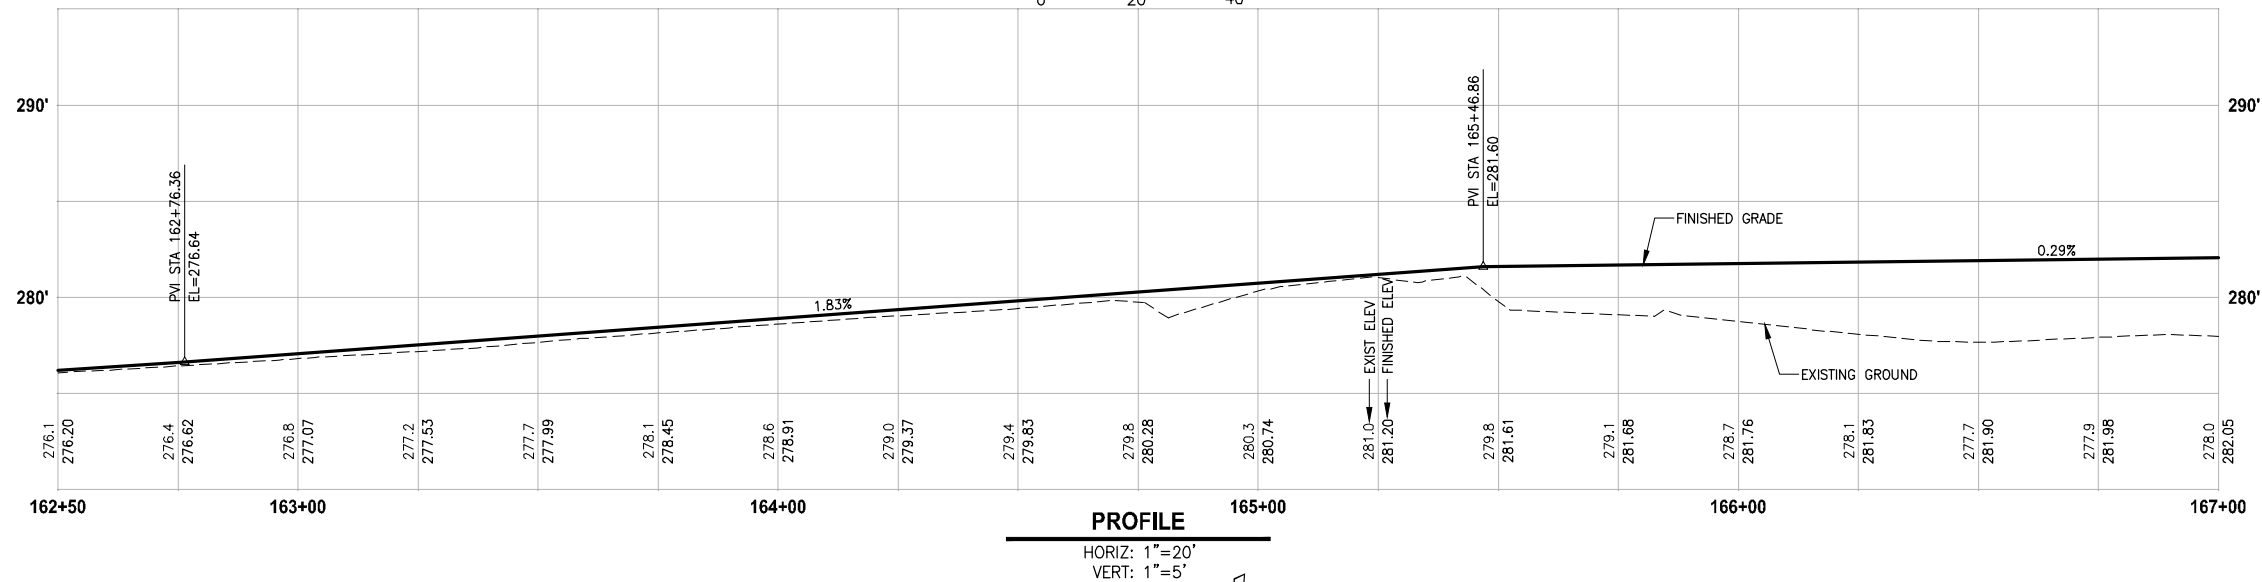

1. INSTALL RETAINING WALL.
2. CEMENT CONCRETE CURB AND GUTTER PER WSDOT STD PLAN F-10.12-03.
3. CEMENT CONCRETE DRIVEWAY ENTRANCE TYPE 3 PER WSDOT STD PLAN F-80.10-03.
4. PERPENDICULAR CURB RAMP PER WSDOT STD PLAN F-40.15-03.
5. MOUNTABLE CEMENT CONCRETE TRAFFIC CURB PER WSDOT STD PLAN F-10.12-03.
6. RAISED TRAFFIC ISLAND.
7. ELEVATED STRUCTURE.
8. BUS LANDING PAD.
9. CROSSWALK PER WSDOT STD PLAN M-15.10-01.
10. ASPHALT RAMP TRANSITION TO EXISTING GROUND.

- 1 CATCH BASIN TYPE 1 PER WSDOT STD PLAN B-5.20-01.
- 2 CATCH BASIN TYPE 2 PER WSDOT STD PLAN B-10.20-01.
- 3 SCHEDULE A STORM SEWER PIPE.
- 4 SCHEDULE A CULVERT PIPE.
- 5 ADJUST MANHOLE/CATCH BASIN.
- 6 ADJUST MANHOLE AND REPLACE WITH SLIP RESISTANT LIDS.
- 7 INFILTRATION TRENCH.
- 8 UNDERDRAIN TRENCH.
- 9 UNDERDRAIN TRENCH CLEANOUT.
- 10 CONCRETE COLLAR FOR CULVERT CONNECTION.

1. POTENTIAL LOCATIONS AND APPROXIMATE SIZES FOR STORMWATER PONDS A AND B FOOTPRINTS ARE SHOWN FOR REVIEW. GRADING AND DETAILED CONVEYANCE PIPES WILL BE DESIGNED IN LATER SUBMITTAL.
2. STORMWATER CONVEYANCE SYSTEMS DEPICTED IN THE DRAFT 30 PERCENT PLANS ARE FOR PRELIMINARY DESIGN PURPOSES. STORMWATER CONVEYANCE SYSTEM DESIGN MAY CHANGE DURING FINAL DESIGN IF CONFLICTS WITH EXISTING UTILITIES.
3. PERMEABLE PAVEMENT (POROUS HMA) IS PROPOSED FOR THE PROPOSED TRAIL SURFACE FOR ALL AREAS WHERE INFILTRATION IS LIKELY TO BE FEASIBLE. FURTHER GEOTECHNICAL INVESTIGATION IS REQUIRED TO CONFIRM WHETHER OR NOT THE UNDERLYING SOILS HAVE SUITABLE INFILTRATION RATES TO SUPPORT POROUS HMA. FOR THE DRAFT 30 PERCENT DESIGN PLANS, AREAS ADJACENT TO WETLANDS A, G AND H ARE PROPOSED TO USE CONVENTIONAL HMA UNTIL FURTHER GEOTECHNICAL INVESTIGATION IS PERFORMED TO CONFIRM IF UNDERLYING SOIL TYPES AND GROUNDWATER ELEVATIONS ARE SUITABLE TO INSTALL PERMEABLE PAVEMENT.

	IMPERVIOUS HMA TRAIL PAVEMENT
	POROUS HMA TRAIL PAVEMENT
	BOARDWALK

PLAN AND PROFILE

AL16

▷	REVISIONS	DATE	BY	DESIGNED J. JUN
				DRAWN B. PURGANAN
				CHECKED Y. HO
				APPROVED J. DVORAK

ONE INCH AT FULL SCALE.
IF NOT, SCALE ACCORDINGLY.

FILE NAME
PS1521151P2CT2T2AL-01

JOB No.
554-1521-151 P2C T2T200C

DATE
MARCH 2017

VERT: 1"=5'

PRELIMINARY

Parametrix
ENGINEERING · PLANNING · ENVIRONMENTAL SCIENCES

719 2ND AVENUE, SUITE 200 | SEATTLE, WA 98104
P 206.394.3700
WWW.PARAMETRIX.COM

PROJECT NAME

**LAKE TO SOUND TRAIL
SEGMENT C**

FROM S 200TH ST TO S NORMANDY ROAD /
DES MOINES MEMORIAL DRIVE INTERSECTION

PLAN AND PROFILE



- 1 INSTALL RETAINING WALL.
- 2 CEMENT CONCRETE CURB AND GUTTER PER WSDOT STD PLAN F-10.12-03.
- 3 CEMENT CONCRETE DRIVEWAY ENTRANCE TYPE 3 PER WSDOT STD PLAN F-80.10-03.
- 4 PERPENDICULAR CURB RAMP PER WSDOT STD PLAN F-40.15-03.
- 5 MOUNTABLE CEMENT CONCRETE TRAFFIC CURB PER WSDOT STD PLAN F-10.12-03.
- 6 RAISED TRAFFIC ISLAND.
- 7 ELEVATED STRUCTURE.
- 8 BUS LANDING PAD.
- 9 CROSSWALK PER WSDOT STD PLAN M-15.10-01.
- 10 ASPHALT RAMP TRANSITION TO EXISTING GROUND.

- 1 CATCH BASIN TYPE 1 PER WSDOT STD PLAN B-5.20-01.
- 2 CATCH BASIN TYPE 2 PER WSDOT STD PLAN B-10.20-01.
- 3 SCHEDULE A STORM SEWER PIPE.
- 4 SCHEDULE A CULVERT PIPE.
- 5 ADJUST MANHOLE/CATCH BASIN.
- 6 ADJUST MANHOLE AND REPLACE WITH SLIP RESISTANT LIDS.
- 7 INFILTRATION TRENCH.
- 8 UNDERDRAIN TRENCH.
- 9 UNDERDRAIN TRENCH CLEANOUT.
- 10 CONCRETE COLLAR FOR CULVERT CONNECTION.

1. POTENTIAL LOCATIONS AND APPROXIMATE SIZES FOR STORMWATER PONDS A AND B FOOTPRINTS ARE SHOWN FOR REVIEW. GRADING AND DETAILED CONVEYANCE PIPES WILL BE DESIGNED IN LATER SUBMITTAL.
2. STORMWATER CONVEYANCE SYSTEMS DEPICTED IN THE DRAFT 30 PERCENT PLANS ARE FOR PRELIMINARY DESIGN PURPOSES. STORMWATER CONVEYANCE SYSTEM DESIGN MAY CHANGE DURING FINAL DESIGN IF CONFLICTS WITH EXISTING UTILITIES.
3. PERMEABLE PAVEMENT (POROUS HMA) IS PROPOSED FOR THE PROPOSED TRAIL SURFACE FOR ALL AREAS WHERE INFILTRATION IS LIKELY TO BE FEASIBLE. FURTHER GEOTECHNICAL INVESTIGATION IS REQUIRED TO CONFIRM WHETHER OR NOT THE UNDERLYING SOILS HAVE SUITABLE INFILTRATION RATES TO SUPPORT POROUS HMA. FOR THE DRAFT 30 PERCENT DESIGN PLANS, AREAS ADJACENT TO WETLANDS A, G AND H ARE PROPOSED TO USE CONVENTIONAL HMA UNTIL FURTHER GEOTECHNICAL INVESTIGATION IS PERFORMED TO CONFIRM IF UNDERLYING SOIL TYPES AND GROUNDWATER ELEVATIONS ARE SUITABLE TO INSTALL PERMEABLE PAVEMENT.

	IMPERVIOUS HMA TRAIL PAVEMENT
	POROUS HMA TRAIL PAVEMENT
	BOARDWALK

PLAN AND PROFILE

AL17

▷	REVISIONS	DATE	BY	DESIGNED J. JUN
				DRAWN B. PURGANAN
				CHECKED Y. HO
				APPROVED J. DVORAK



ONE INCH AT FULL SCALE.
IF NOT, SCALE ACCORDINGLY.

FILE NAME
PS1521151P2CT2T2AL-01
JOB No.
554-1521-151 P2C T2T200C
DATE
MARCH 2017

719 2ND AVENUE, SUITE 200 | SEATTLE, WA 98101
P 206.394.3700
WWW.PARAMETRIX.COM

FROM S 200TH ST TO S NORMANDY ROAD /
DES MOINES MEMORIAL DRIVE INTERSECTION

PATH: U:\PSO\Projects\Clients\1521-KingCo\554-1521-151 L2ST-SegC\995vcs\CADD\Phase 2C\Task 21200C\DWG LAYOUT: AL19 PLOTTED BY: purgabut DATE: Thursday, March 09, 2017 4:58:06 PM

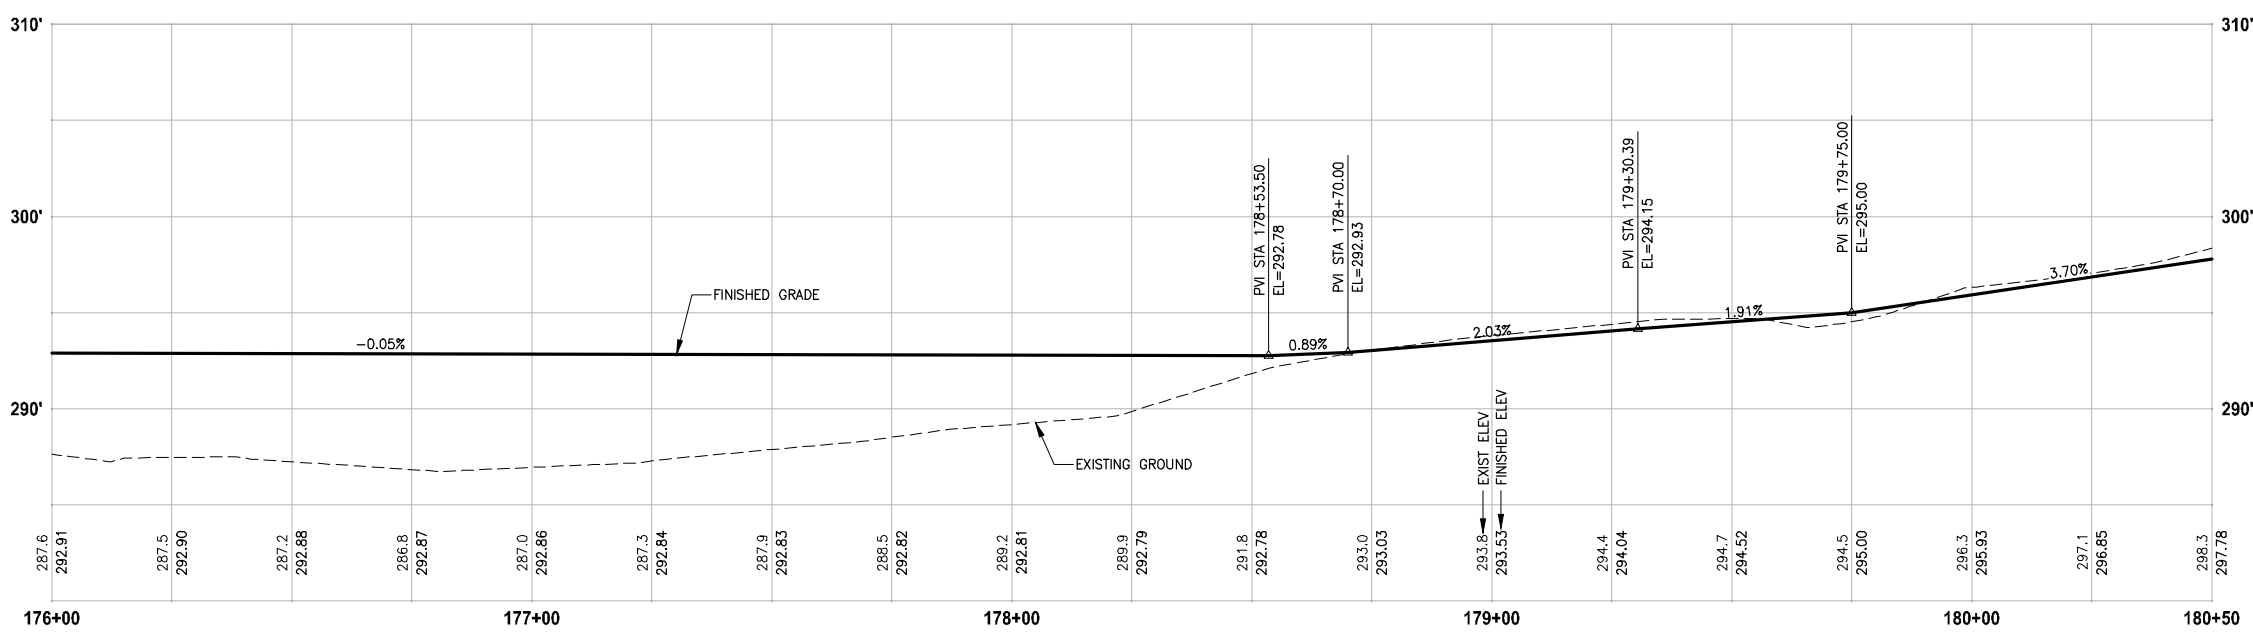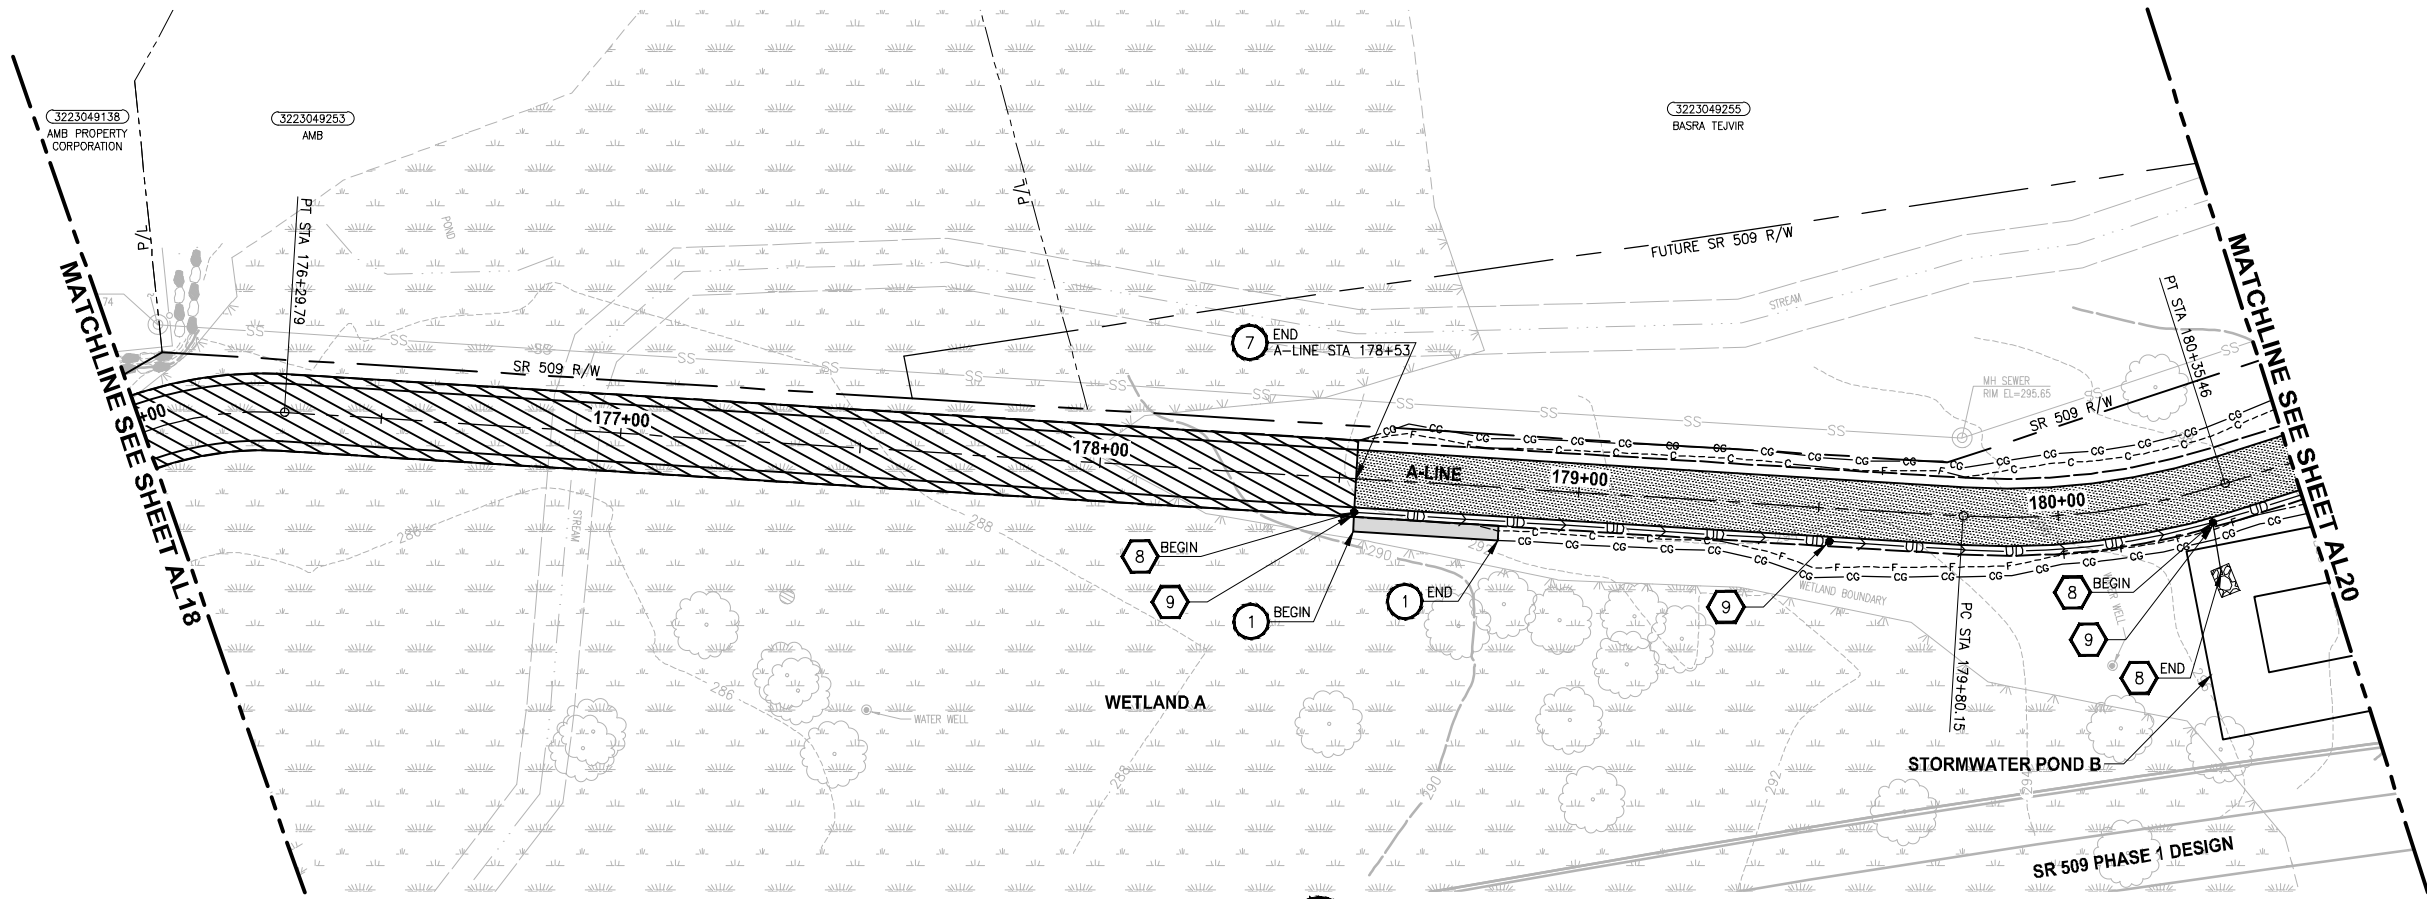

PROFILE

HORIZ: 1"=20'
VERT: 1"=5'

CIVIL CONSTRUCTION NOTES:

1. INSTALL RETAINING WALL.
2. CEMENT CONCRETE CURB AND GUTTER PER WSDOT STD PLAN F-10.12-03.
3. CEMENT CONCRETE DRIVEWAY ENTRANCE TYPE 3 PER WSDOT STD PLAN F-80.10-03.
4. PERPENDICULAR CURB RAMP PER WSDOT STD PLAN F-40.15-03.
5. MOUNTABLE CEMENT CONCRETE TRAFFIC CURB PER WSDOT STD PLAN F-10.12-03.
6. RAISED TRAFFIC ISLAND.
7. ELEVATED STRUCTURE.
8. BUS LANDING PAD.
9. CROSSWALK PER WSDOT STD PLAN M-15.10-01.
10. ASPHALT RAMP TRANSITION TO EXISTING GROUND.

STORMWATER CONSTRUCTION NOTES:

1. CATCH BASIN TYPE 1 PER WSDOT STD PLAN B-5.20-01.
2. CATCH BASIN TYPE 2 PER WSDOT STD PLAN B-10.20-01.
3. SCHEDULE A STORM SEWER PIPE.
4. SCHEDULE A CULVERT PIPE.
5. ADJUST MANHOLE/CATCH BASIN.
6. ADJUST MANHOLE AND REPLACE WITH SLIP RESISTANT LIDS.
7. INFILTRATION TRENCH.
8. UNDERDRAIN TRENCH.
9. UNDERDRAIN TRENCH CLEANOUT.
10. CONCRETE COLLAR FOR CULVERT CONNECTION.

STORMWATER GENERAL NOTES:

1. POTENTIAL LOCATIONS AND APPROXIMATE SIZES FOR STORMWATER PONDS A AND B FOOTPRINTS ARE SHOWN FOR REVIEW. GRADING AND DETAILED CONVEYANCE PIPES WILL BE DESIGNED IN LATER SUBMITTAL.
2. STORMWATER CONVEYANCE SYSTEMS DEPICTED IN THE DRAFT 30 PERCENT PLANS ARE FOR PRELIMINARY DESIGN PURPOSES. STORMWATER CONVEYANCE SYSTEM DESIGN MAY CHANGE DURING FINAL DESIGN IF CONFLICTS WITH EXISTING UTILITIES.
3. PERMEABLE PAVEMENT (POROUS HMA) IS PROPOSED FOR THE PROPOSED TRAIL SURFACE FOR ALL AREAS WHERE INFILTRATION IS LIKELY TO BE FEASIBLE. FURTHER GEOTECHNICAL INVESTIGATION IS REQUIRED TO CONFIRM WHETHER OR NOT THE UNDERLYING SOILS HAVE SUITABLE INFILTRATION RATES TO SUPPORT POROUS HMA. FOR THE DRAFT 30 PERCENT DESIGN PLANS, AREAS ADJACENT TO WETLANDS A, G AND H ARE PROPOSED TO USE CONVENTIONAL HMA UNTIL FURTHER GEOTECHNICAL INVESTIGATION IS PERFORMED TO CONFIRM IF UNDERLYING SOIL TYPES AND GROUNDWATER ELEVATIONS ARE SUITABLE TO INSTALL PERMEABLE PAVEMENT.

LEGEND:

- IMPERVIOUS HMA TRAIL PAVEMENT
- POROUS HMA TRAIL PAVEMENT
- BOARDWALK

30 % REVIEW SUBMITTAL
NOT FOR CONSTRUCTION

REVISIONS	DATE	BY	DESIGNED
			J. JUN
			B. PURGANAN
			Y. HO
			J. DVORAK

ONE INCH AT FULL SCALE.
IF NOT, SCALE ACCORDINGLY

FILE NAME
PS1521151P2CT2T2AL-01

JOB No.
554-1521-151 P2C T2T200C

DATE
MARCH 2017

PRELIMINARY

Parametrix
ENGINEERING · PLANNING · ENVIRONMENTAL SCIENCES

719 2ND AVENUE, SUITE 200 | SEATTLE, WA 98104
P 206.394.3700
WWW.PARAMETRIX.COM

PROJECT NAME
**LAKE TO SOUND TRAIL
SEGMENT C**




FROM S 200TH ST TO S NORMANDY ROAD /
DES MOINES MEMORIAL DRIVE INTERSECTION

PLAN AND PROFILE

SHEET NO.
25 OF 33

AL19

 PATH: U:\PSO\Projects\Clients\1521-KingCo\554-1521-151 L2ST-SegC\995vec\CAADD\Phase 2C\Task 2T200C.DWG PLOTTED BY: purgabit DATE: Thursday, March 09, 2017 4:56:32 PM LAYOUT: AL20

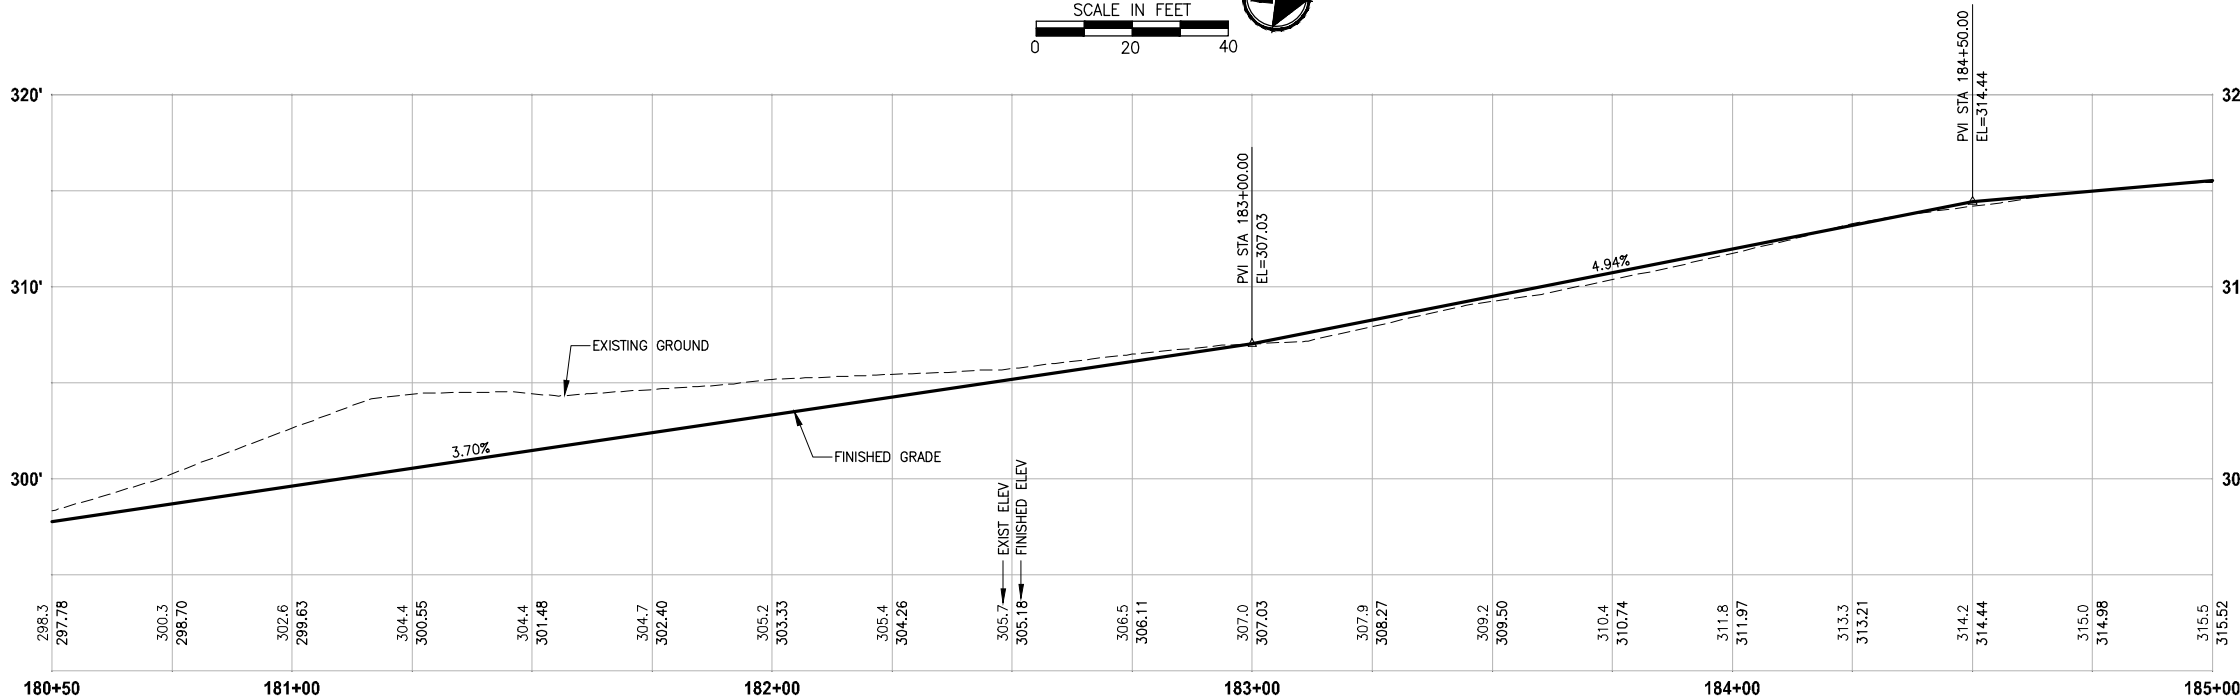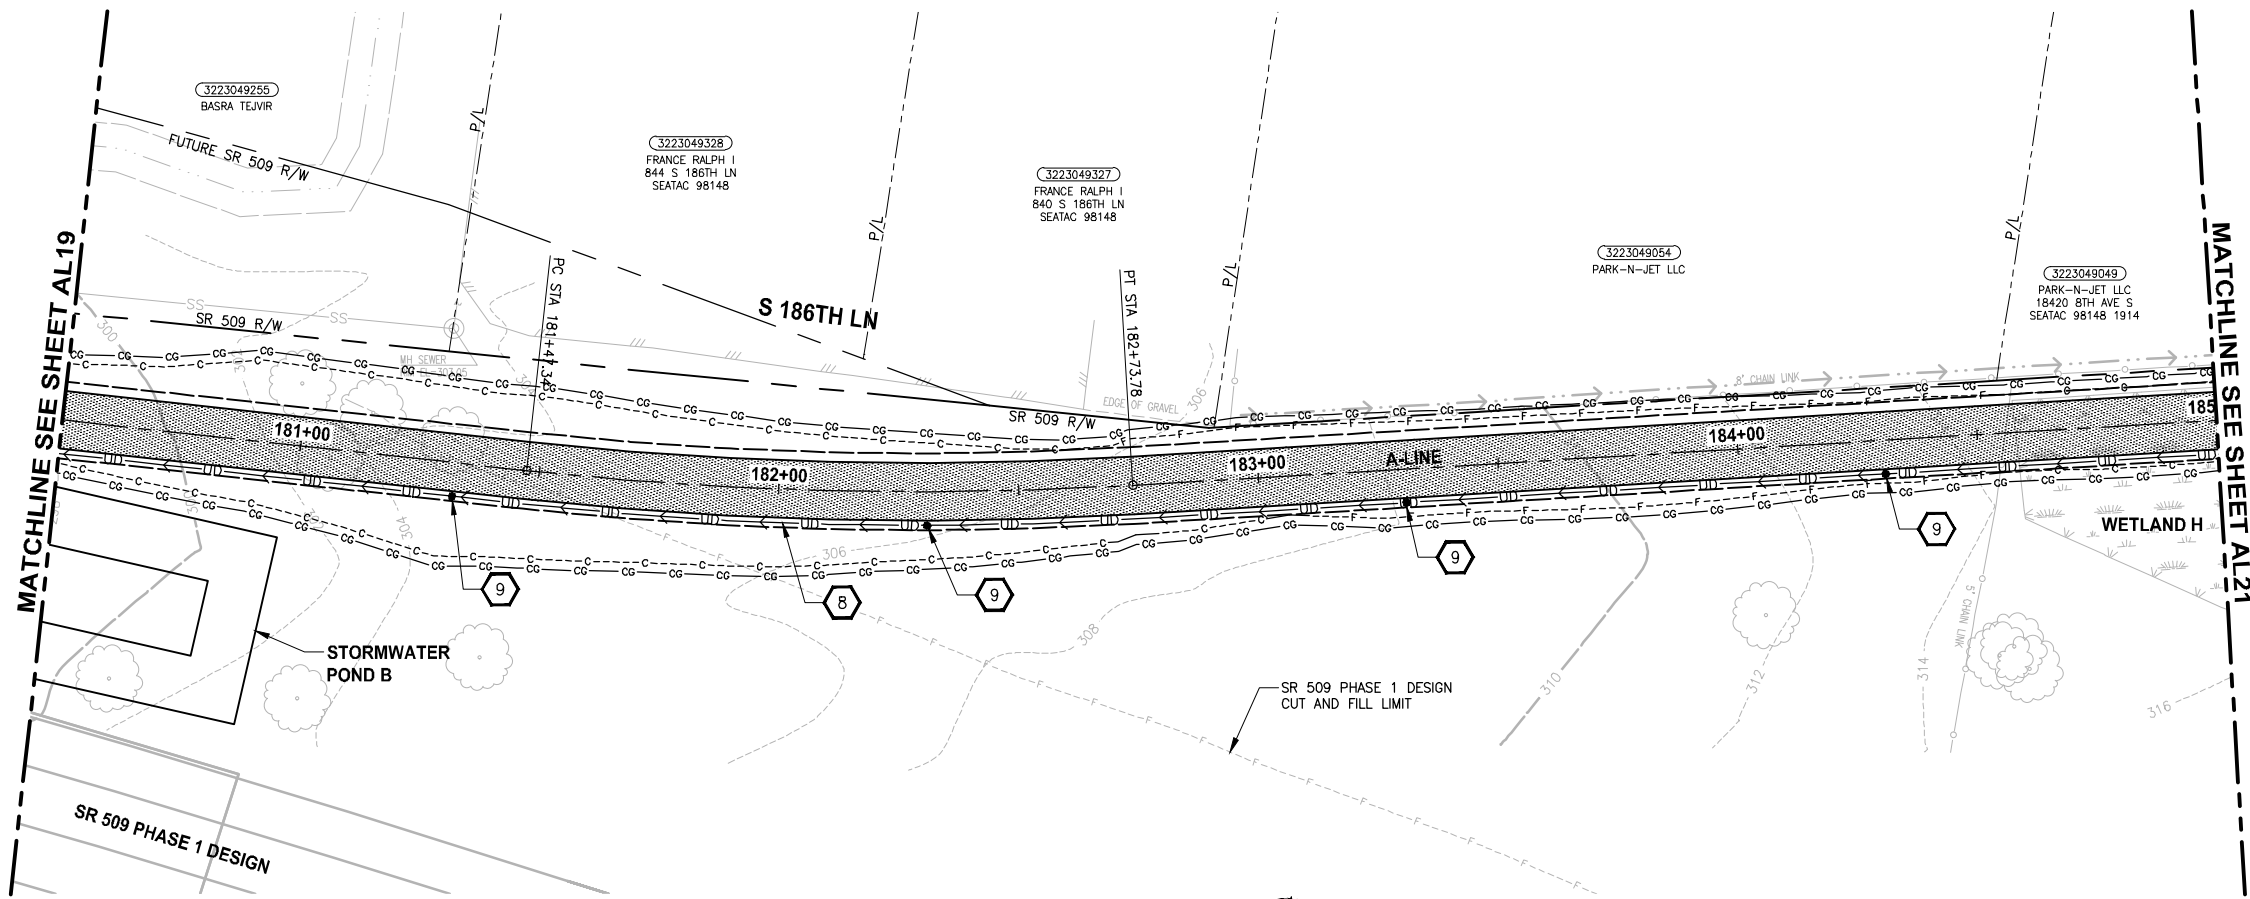

PROFILE

HORIZ: 1"=20'
VERT: 1"=5'

CIVIL CONSTRUCTION NOTES:

1. INSTALL RETAINING WALL.
2. CEMENT CONCRETE CURB AND GUTTER PER WSDOT STD PLAN F-10.12-03.
3. CEMENT CONCRETE DRIVEWAY ENTRANCE TYPE 3 PER WSDOT STD PLAN F-80.10-03.
4. PERPENDICULAR CURB RAMP PER WSDOT STD PLAN F-40.15-03.
5. MOUNTABLE CEMENT CONCRETE TRAFFIC CURB PER WSDOT STD PLAN F-10.12-03.
6. RAISED TRAFFIC ISLAND.
7. ELEVATED STRUCTURE.
8. BUS LANDING PAD.
9. CROSSWALK PER WSDOT STD PLAN M-15.10-01.
10. ASPHALT RAMP TRANSITION TO EXISTING GROUND.

STORMWATER CONSTRUCTION NOTES:

1. CATCH BASIN TYPE 1 PER WSDOT STD PLAN B-5.20-01.
2. CATCH BASIN TYPE 2 PER WSDOT STD PLAN B-10.20-01.
3. SCHEDULE A STORM SEWER PIPE.
4. SCHEDULE A CULVERT PIPE.
5. ADJUST MANHOLE/CATCH BASIN.
6. ADJUST MANHOLE AND REPLACE WITH SLIP RESISTANT LIDS.
7. INFILTRATION TRENCH.
8. UNDERDRAIN TRENCH.
9. UNDERDRAIN TRENCH CLEANOUT.
10. CONCRETE COLLAR FOR CULVERT CONNECTION.

STORMWATER GENERAL NOTES:

1. POTENTIAL LOCATIONS AND APPROXIMATE SIZES FOR STORMWATER PONDS A AND B FOOTPRINTS ARE SHOWN FOR REVIEW. GRADING AND DETAILED CONVEYANCE PIPES WILL BE DESIGNED IN LATER SUBMITTAL.
2. STORMWATER CONVEYANCE SYSTEMS DEPICTED IN THE DRAFT 30 PERCENT PLANS ARE FOR PRELIMINARY DESIGN PURPOSES. STORMWATER CONVEYANCE SYSTEM DESIGN MAY CHANGE DURING FINAL DESIGN IF CONFLICTS WITH EXISTING UTILITIES.
3. PERMEABLE PAVEMENT (POROUS HMA) IS PROPOSED FOR THE PROPOSED TRAIL SURFACE FOR ALL AREAS WHERE INFILTRATION IS LIKELY TO BE FEASIBLE. FURTHER GEOTECHNICAL INVESTIGATION IS REQUIRED TO CONFIRM WHETHER OR NOT THE UNDERLYING SOILS HAVE SUITABLE INFILTRATION RATES TO SUPPORT POROUS HMA. FOR THE DRAFT 30 PERCENT DESIGN PLANS, AREAS ADJACENT TO WETLANDS A, G AND H ARE PROPOSED TO USE CONVENTIONAL HMA UNTIL FURTHER GEOTECHNICAL INVESTIGATION IS PERFORMED TO CONFIRM IF UNDERLYING SOIL TYPES AND GROUNDWATER ELEVATIONS ARE SUITABLE TO INSTALL PERMEABLE PAVEMENT.

LEGEND:

	IMPERVIOUS HMA TRAIL PAVEMENT
	POROUS HMA TRAIL PAVEMENT
	BOARDWALK

30 % REVIEW SUBMITTAL
NOT FOR CONSTRUCTION

REVISIONS	DATE	BY	DESIGNED
			J. JUN
			B. PURGANAN
			Y. HO
			J. DVORAK

ONE INCH AT FULL SCALE.
IF NOT, SCALE ACCORDINGLY
FILE NAME
PS1521151P2CT2T2AL-01
JOB No.
554-1521-151 P2C T2T200C
DATE
MARCH 2017

Parametrix
ENGINEERING · PLANNING · ENVIRONMENTAL SCIENCES

719 2ND AVENUE, SUITE 200 | SEATTLE, WA 98104
P 206.394.3700
WWW.PARAMETRIX.COM

PROJECT NAME

LAKE TO SOUND TRAIL
SEGMENT C




FROM S 200TH ST TO S NORMANDY ROAD /
DES MOINES MEMORIAL DRIVE INTERSECTION

PLAN AND PROFILE

SHEET NO.
26 OF 33

AL20

 PATH: U:\PSO\Projects\AL21-KingCo\554-1521-151 L2ST-SegC\995vcs\CAD\Phase 2C\Task 21200C\DWG LAYOUT: AL21 PLOTTED BY: purgubut DATE: Thursday, March 09, 2017 4:58:57 PM

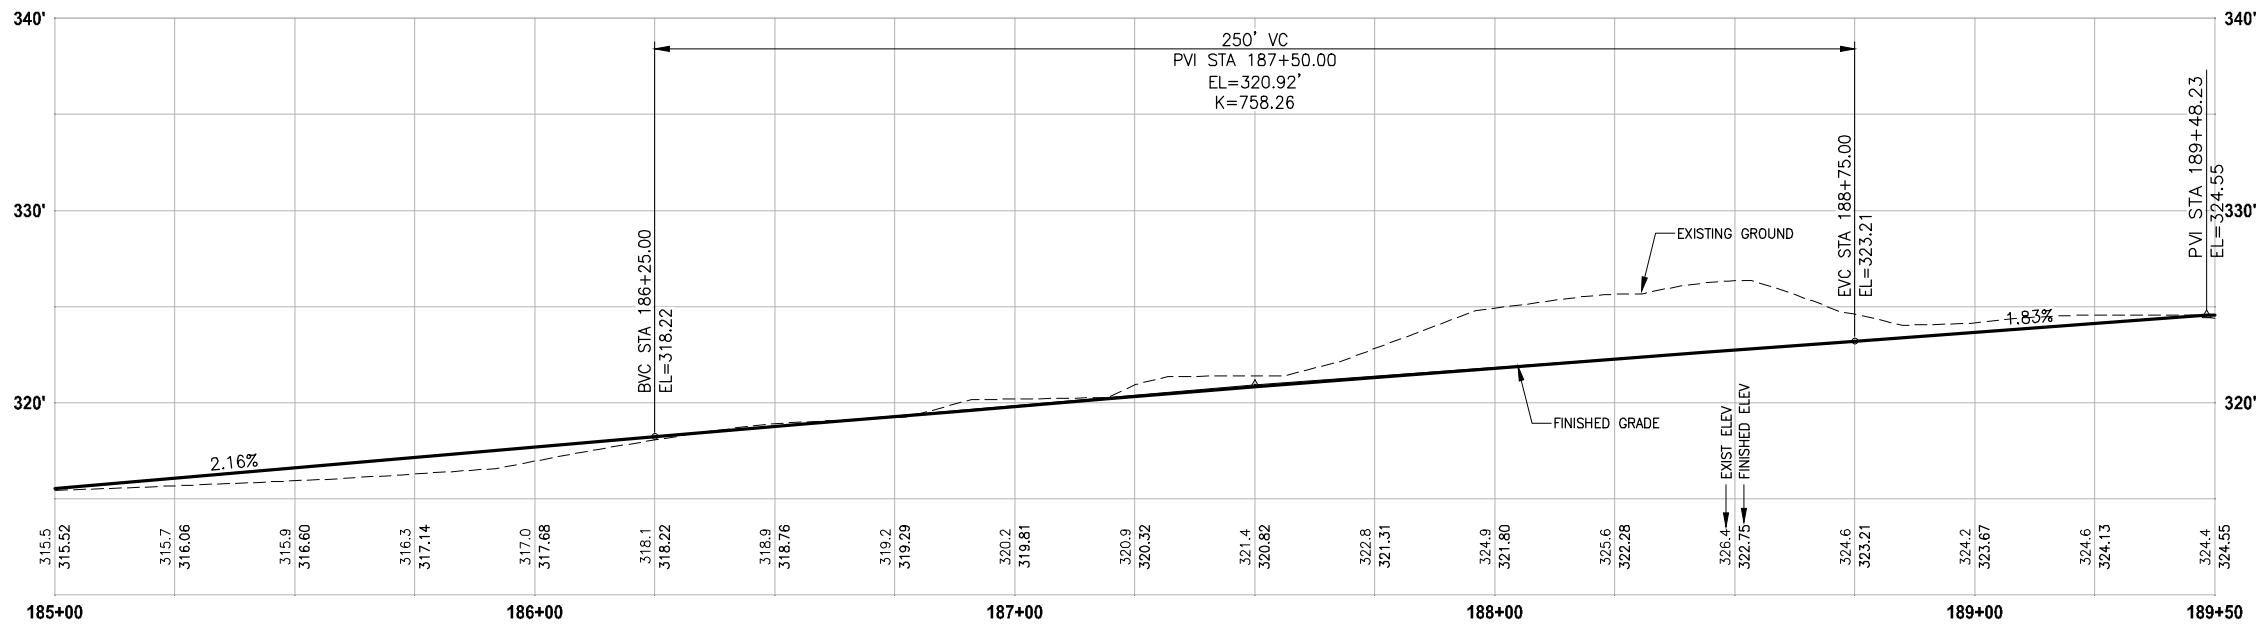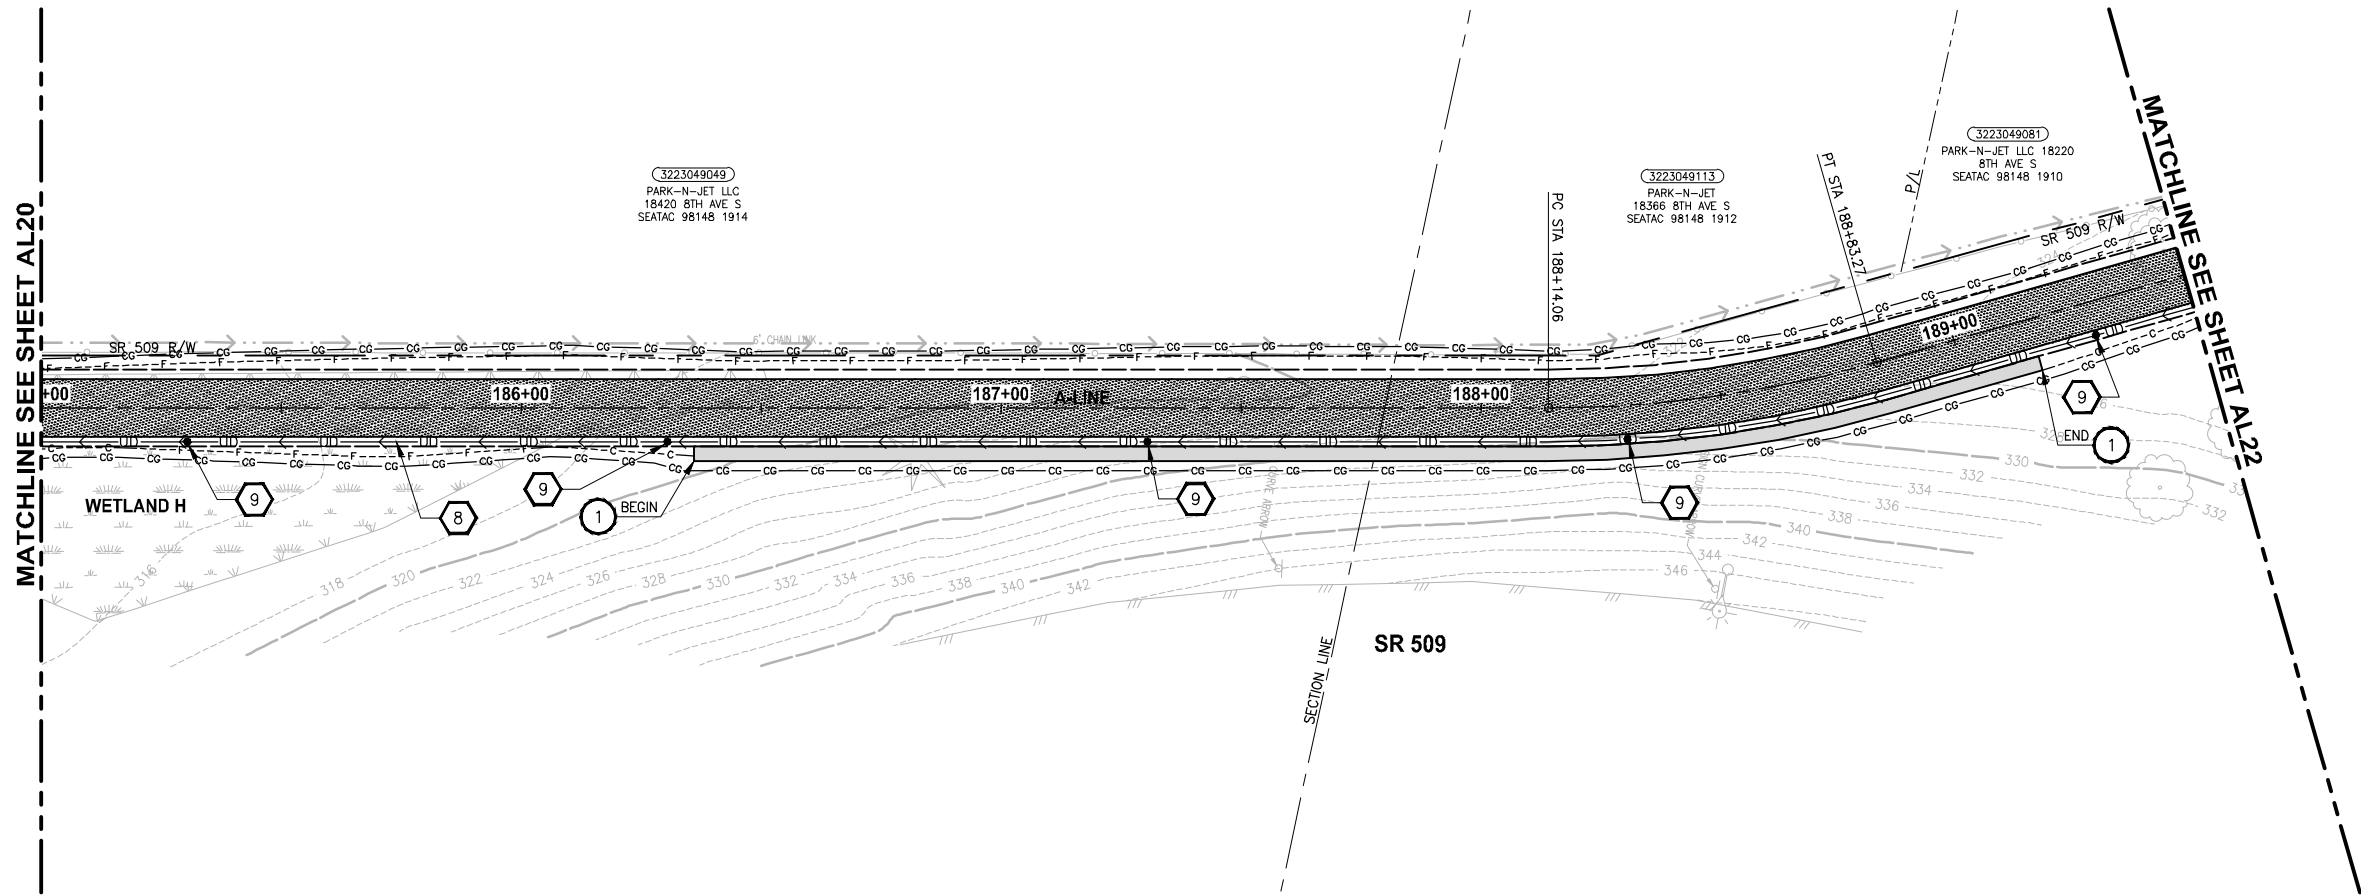

PROFILE

HORIZ: 1"=20'
VERT: 1"=5'

CIVIL CONSTRUCTION NOTES:

1. INSTALL RETAINING WALL.
2. CEMENT CONCRETE CURB AND GUTTER PER WSDOT STD PLAN F-10.12-03.
3. CEMENT CONCRETE DRIVEWAY ENTRANCE TYPE 3 PER WSDOT STD PLAN F-80.10-03.
4. PERPENDICULAR CURB RAMP PER WSDOT STD PLAN F-40.15-03.
5. MOUNTABLE CEMENT CONCRETE TRAFFIC CURB PER WSDOT STD PLAN F-10.12-03.
6. RAISED TRAFFIC ISLAND.
7. ELEVATED STRUCTURE.
8. BUS LANDING PAD.
9. CROSSWALK PER WSDOT STD PLAN M-15.10-01.
10. ASPHALT RAMP TRANSITION TO EXISTING GROUND.

STORMWATER CONSTRUCTION NOTES:

1. CATCH BASIN TYPE 1 PER WSDOT STD PLAN B-5.20-01.
2. CATCH BASIN TYPE 2 PER WSDOT STD PLAN B-10.20-01.
3. SCHEDULE A STORM SEWER PIPE.
4. SCHEDULE A CULVERT PIPE.
5. ADJUST MANHOLE/CATCH BASIN.
6. ADJUST MANHOLE AND REPLACE WITH SLIP RESISTANT LIDS.
7. INFILTRATION TRENCH.
8. UNDERDRAIN TRENCH.
9. UNDERDRAIN TRENCH CLEANOUT.
10. CONCRETE COLLAR FOR CULVERT CONNECTION.

STORMWATER GENERAL NOTES:

1. POTENTIAL LOCATIONS AND APPROXIMATE SIZES FOR STORMWATER PONDS A AND B FOOTPRINTS ARE SHOWN FOR REVIEW. GRADING AND DETAILED CONVEYANCE PIPES WILL BE DESIGNED IN LATER SUBMITTAL.
2. STORMWATER CONVEYANCE SYSTEMS DEPICTED IN THE DRAFT 30 PERCENT PLANS ARE FOR PRELIMINARY DESIGN PURPOSES. STORMWATER CONVEYANCE SYSTEM DESIGN MAY CHANGE DURING FINAL DESIGN IF CONFLICTS WITH EXISTING UTILITIES.
3. PERMEABLE PAVEMENT (POROUS HMA) IS PROPOSED FOR THE PROPOSED TRAIL SURFACE FOR ALL AREAS WHERE INFILTRATION IS LIKELY TO BE FEASIBLE. FURTHER GEOTECHNICAL INVESTIGATION IS REQUIRED TO CONFIRM WHETHER OR NOT THE UNDERLYING SOILS HAVE SUITABLE INFILTRATION RATES TO SUPPORT POROUS HMA. FOR THE DRAFT 30 PERCENT DESIGN PLANS, AREAS ADJACENT TO WETLANDS A, G AND H ARE PROPOSED TO USE CONVENTIONAL HMA UNTIL FURTHER GEOTECHNICAL INVESTIGATION IS PERFORMED TO CONFIRM IF UNDERLYING SOIL TYPES AND GROUNDWATER ELEVATIONS ARE SUITABLE TO INSTALL PERMEABLE PAVEMENT.

LEGEND:

- | | |
|--|-------------------------------|
| | IMPERVIOUS HMA TRAIL PAVEMENT |
| | POROUS HMA TRAIL PAVEMENT |
| | BOARDWALK |

30 % REVIEW SUBMITTAL
NOT FOR CONSTRUCTION

REVISIONS	DATE	BY	DESIGNED
			J. JUN
			B. PURGANAN
			Y. HO
			J. DVORAK

ONE INCH AT FULL SCALE. IF NOT, SCALE ACCORDINGLY
FILE NAME PS1521151P2CT2T2AL-01
JOB No. 554-1521-151 P2C T2T200C
DATE MARCH 2017

Parametrix
ENGINEERING · PLANNING · ENVIRONMENTAL SCIENCES

719 2ND AVENUE, SUITE 200 | SEATTLE, WA 98104
P 206.394.3700
WWW.PARAMETRIX.COM

PROJECT NAME

LAKE TO SOUND TRAIL
SEGMENT C



FROM S 200TH ST TO S NORMANDY ROAD /
DES MOINES MEMORIAL DRIVE INTERSECTION

PLAN AND PROFILE

SHEET NO.
27 OF 33

AL21

PATH: U:\PSO\Projects\Clients\1521-KingCo\554-1521-151 L2ST-SegC\995SecC\CADD\Phase 2C\Task 21200C\DWG LAYOUT: AL22 PLOTTED BY: purgabit DATE: Thursday, March 09, 2017 4:59:19 PM

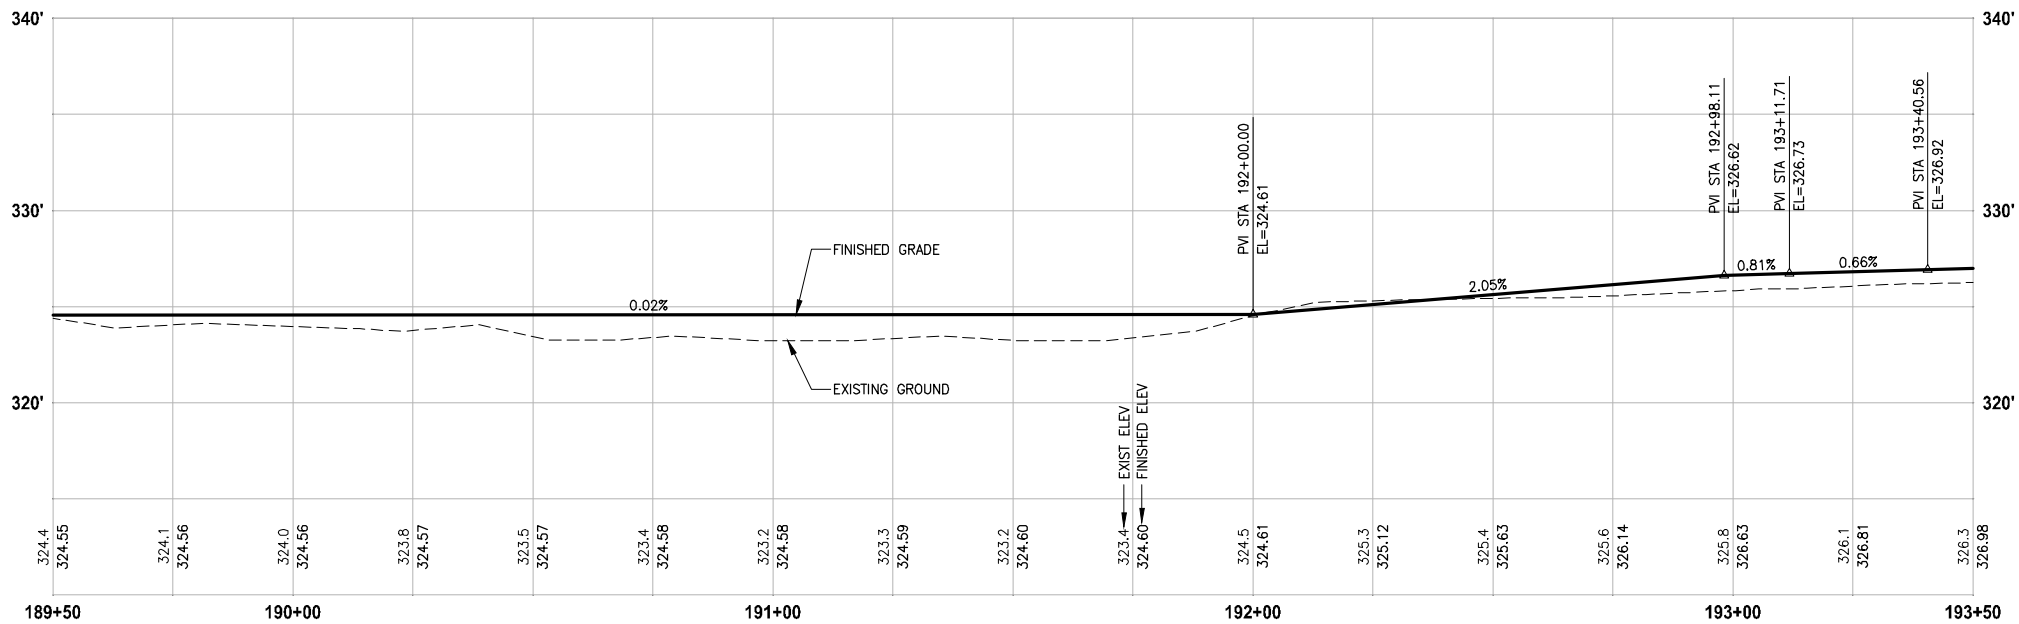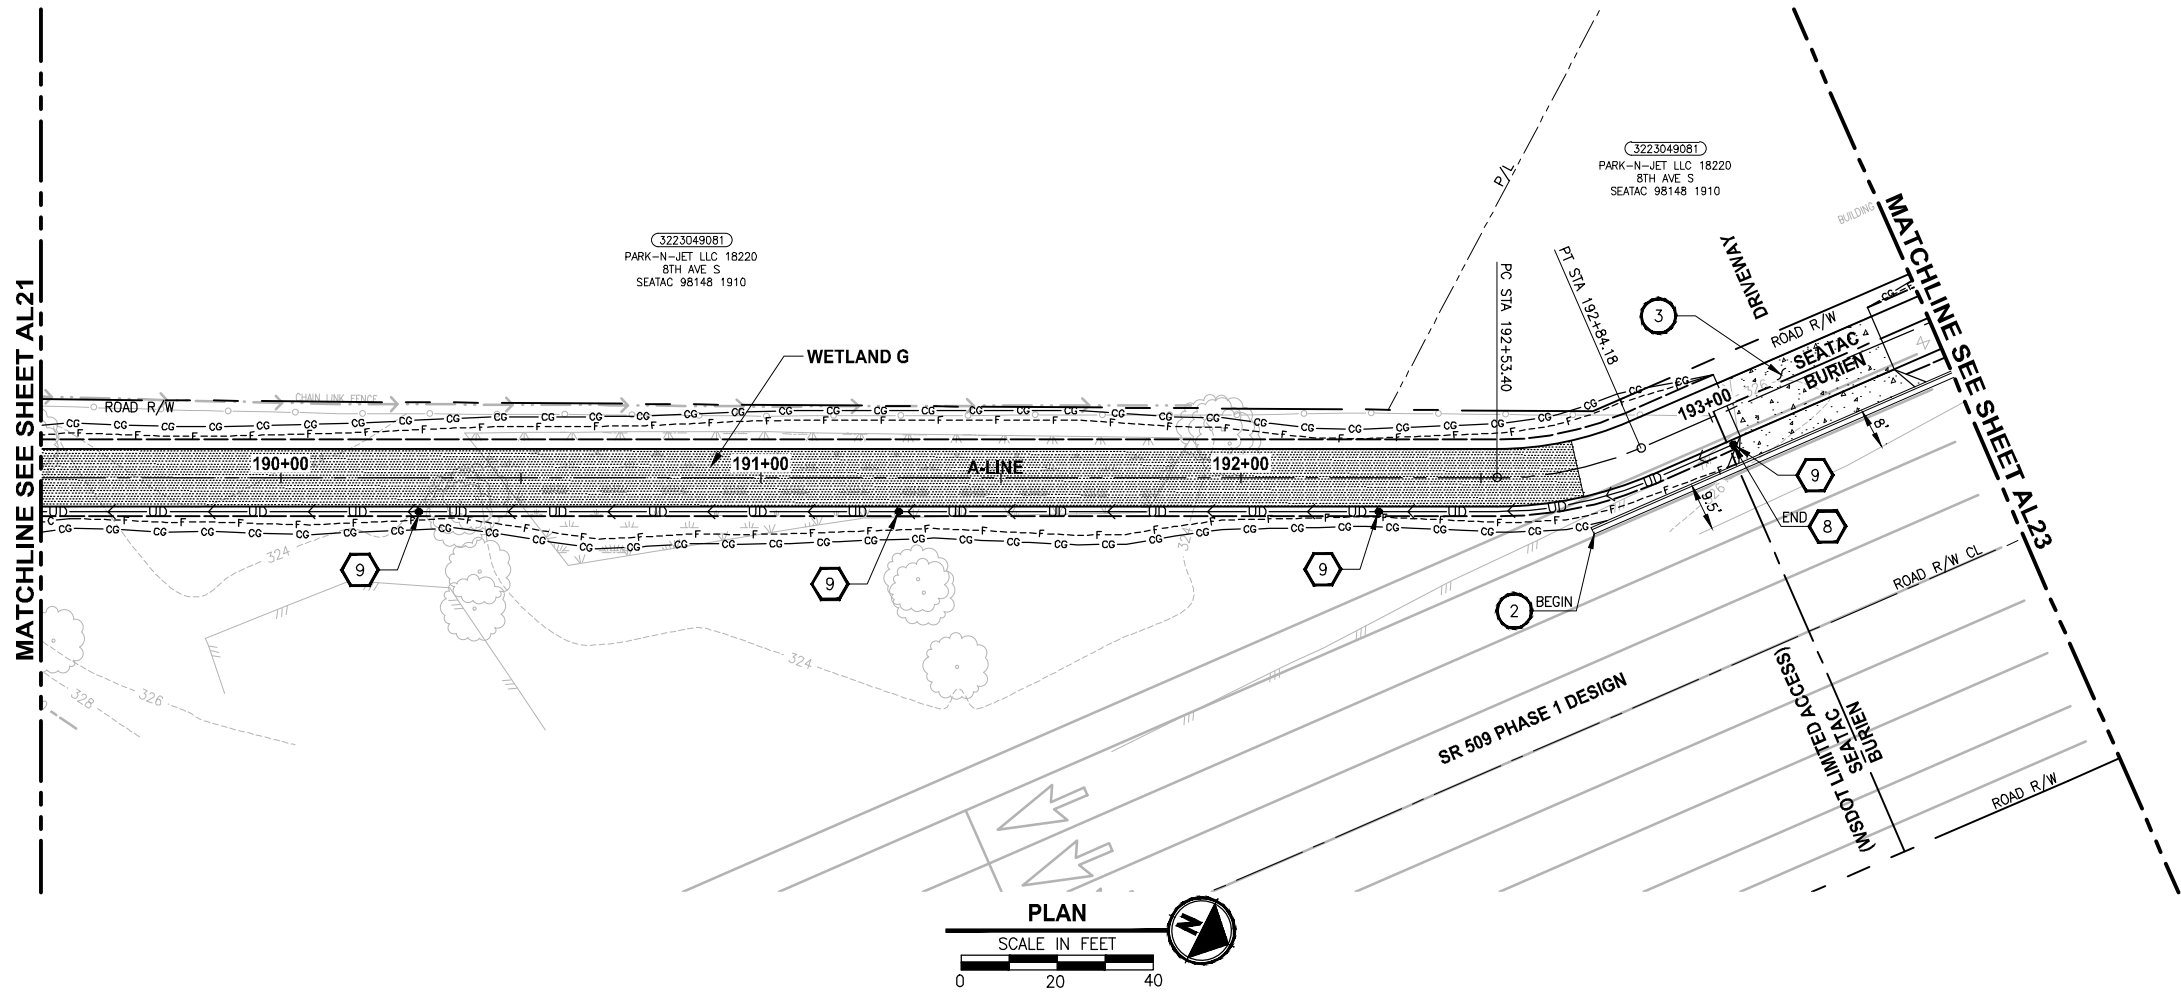

PROFILE

HORIZ: 1"=20'
VERT: 1"=5'

CIVIL CONSTRUCTION NOTES:

1. INSTALL RETAINING WALL.
2. CEMENT CONCRETE CURB AND GUTTER PER WSDOT STD PLAN F-10.12-03.
3. CEMENT CONCRETE DRIVEWAY ENTRANCE TYPE 3 PER WSDOT STD PLAN F-80.10-03.
4. PERPENDICULAR CURB RAMP PER WSDOT STD PLAN F-40.15-03.
5. MOUNTABLE CEMENT CONCRETE TRAFFIC CURB PER WSDOT STD PLAN F-10.12-03.
6. RAISED TRAFFIC ISLAND.
7. ELEVATED STRUCTURE.
8. BUS LANDING PAD.
9. CROSSWALK PER WSDOT STD PLAN M-15.10-01.
10. ASPHALT RAMP TRANSITION TO EXISTING GROUND.

STORMWATER CONSTRUCTION NOTES:

1. CATCH BASIN TYPE 1 PER WSDOT STD PLAN B-5.20-01.
2. CATCH BASIN TYPE 2 PER WSDOT STD PLAN B-10.20-01.
3. SCHEDULE A STORM SEWER PIPE.
4. SCHEDULE A CULVERT PIPE.
5. ADJUST MANHOLE/CATCH BASIN.
6. ADJUST MANHOLE AND REPLACE WITH SLIP RESISTANT LIDS.
7. INFILTRATION TRENCH.
8. UNDERDRAIN TRENCH.
9. UNDERDRAIN TRENCH CLEANOUT.
10. CONCRETE COLLAR FOR CULVERT CONNECTION.

STORMWATER GENERAL NOTES:

1. POTENTIAL LOCATIONS AND APPROXIMATE SIZES FOR STORMWATER PONDS A AND B FOOTPRINTS ARE SHOWN FOR REVIEW. GRADING AND DETAILED CONVEYANCE PIPES WILL BE DESIGNED IN LATER SUBMITTAL.
2. STORMWATER CONVEYANCE SYSTEMS DEPICTED IN THE DRAFT 30 PERCENT PLANS ARE FOR PRELIMINARY DESIGN PURPOSES. STORMWATER CONVEYANCE SYSTEM DESIGN MAY CHANGE DURING FINAL DESIGN IF CONFLICTS WITH EXISTING UTILITIES.
3. PERMEABLE PAVEMENT (POROUS HMA) IS PROPOSED FOR THE PROPOSED TRAIL SURFACE FOR ALL AREAS WHERE INFILTRATION IS LIKELY TO BE FEASIBLE. FURTHER GEOTECHNICAL INVESTIGATION IS REQUIRED TO CONFIRM WHETHER OR NOT THE UNDERLYING SOILS HAVE SUITABLE INFILTRATION RATES TO SUPPORT POROUS HMA. FOR THE DRAFT 30 PERCENT DESIGN PLANS, AREAS ADJACENT TO WETLANDS A, G AND H ARE PROPOSED TO USE CONVENTIONAL HMA UNTIL FURTHER GEOTECHNICAL INVESTIGATION IS PERFORMED TO CONFIRM IF UNDERLYING SOIL TYPES AND GROUNDWATER ELEVATIONS ARE SUITABLE TO INSTALL PERMEABLE PAVEMENT.

LEGEND:

- IMPERVIOUS HMA TRAIL PAVEMENT
- POROUS HMA TRAIL PAVEMENT
- BOARDWALK

30 % REVIEW SUBMITTAL
NOT FOR CONSTRUCTION

PLAN AND PROFILE

SHEET NO.
28 OF 33

AL22

REVISIONS	DATE	BY	DESIGNED
			J. JUN
			DRAWN
			B. PURGANAN
			CHECKED
			Y. HO
			APPROVED
			J. DVORAK

ONE INCH AT FULL SCALE.
IF NOT, SCALE ACCORDINGLY

FILE NAME
PS1521151P2CT2T2AL-01

JOB No.
554-1521-151 P2C T2T200C

DATE
MARCH 2017

Parametrix
ENGINEERING · PLANNING · ENVIRONMENTAL SCIENCES


719 2ND AVENUE, SUITE 200 | SEATTLE, WA 98104
P 206.394.3700
WWW.PARAMETRIX.COM

PROJECT NAME

LAKE TO SOUND TRAIL
SEGMENT C

FROM S 200TH ST TO S NORMANDY ROAD /
DES MOINES MEMORIAL DRIVE INTERSECTION

PATH: U:\PSO\Projects\Clients\1521-KingCo\554-1521-151 L251-SegC\995SecC\CADD\Phase 2C\Task 21200C\DWG LAYOUT: AL23 PLOTTED BY: purgaban DATE: Thursday, March 09, 2017 4:59:44 PM

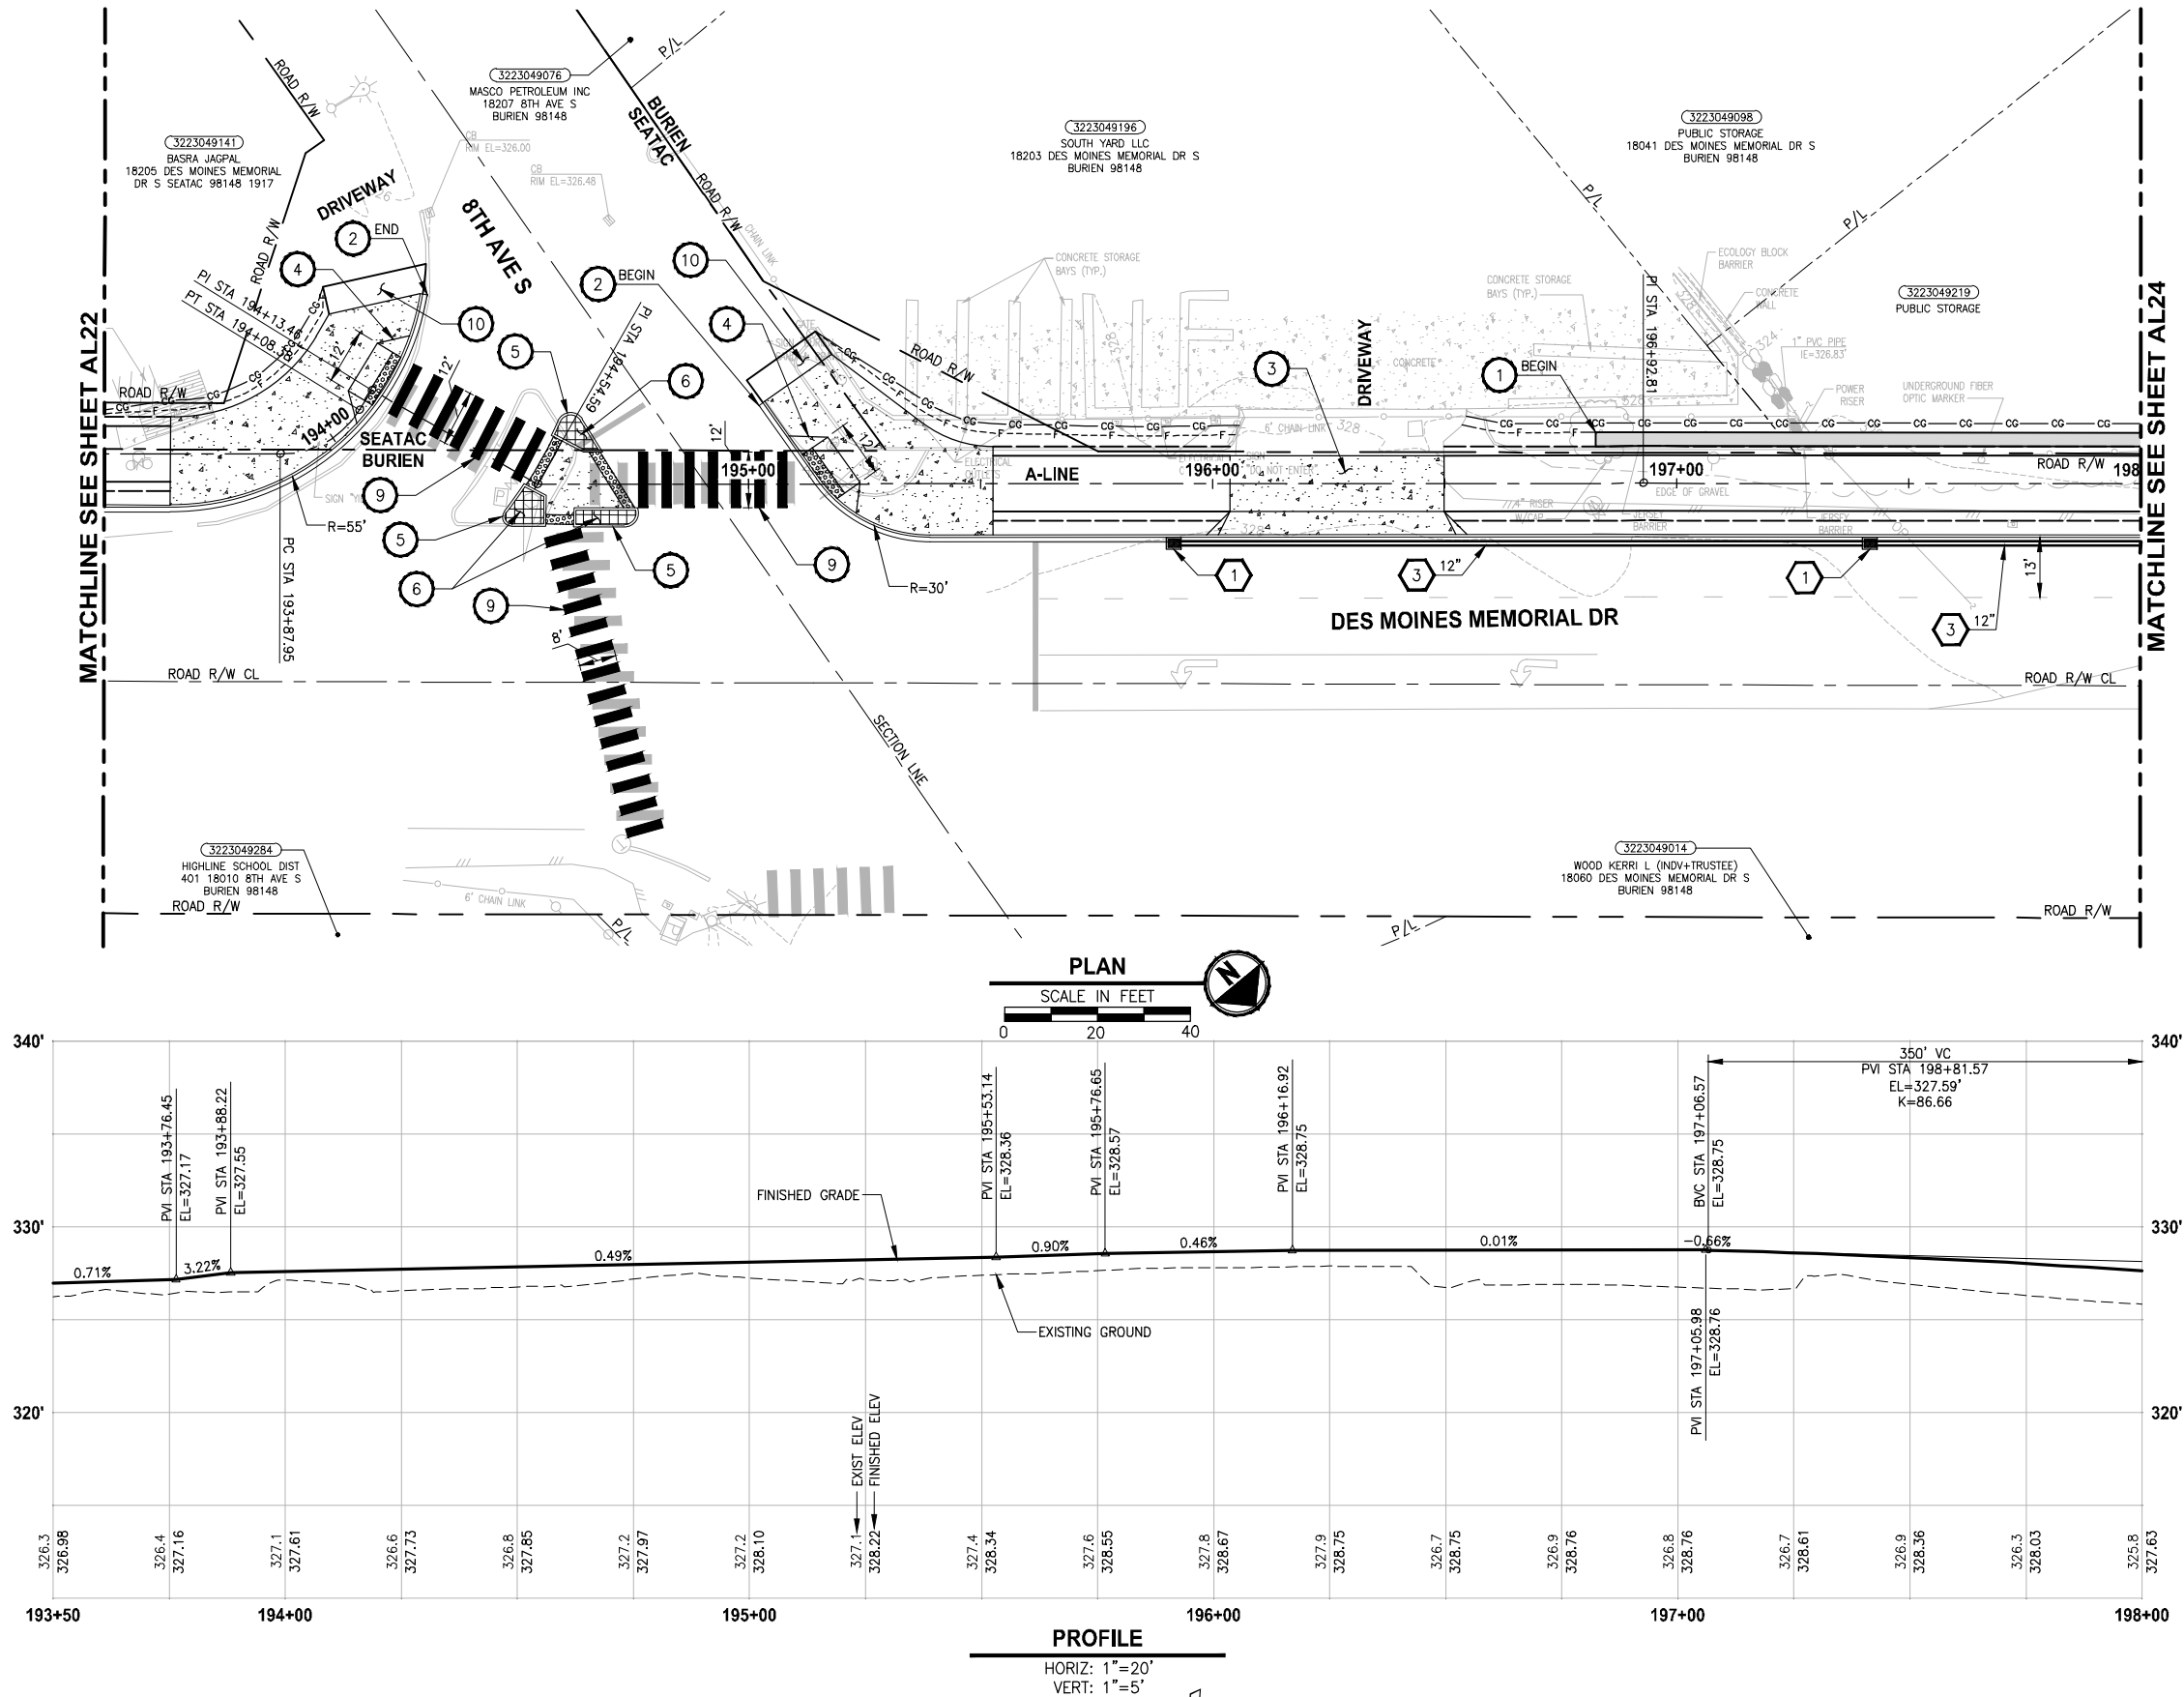

CIVIL CONSTRUCTION NOTES:

1. INSTALL RETAINING WALL.
2. CEMENT CONCRETE CURB AND GUTTER PER WSDOT STD PLAN F-10.12-03.
3. CEMENT CONCRETE DRIVEWAY ENTRANCE TYPE 3 PER WSDOT STD PLAN F-80.10-03.
4. PERPENDICULAR CURB RAMP PER WSDOT STD PLAN F-40.15-03.
5. MOUNTABLE CEMENT CONCRETE TRAFFIC CURB PER WSDOT STD PLAN F-10.12-03.
6. RAISED TRAFFIC ISLAND.
7. ELEVATED STRUCTURE.
8. BUS LANDING PAD.
9. CROSSWALK PER WSDOT STD PLAN M-15.10-01.
10. ASPHALT RAMP TRANSITION TO EXISTING GROUND.

STORMWATER CONSTRUCTION NOTES:

1. CATCH BASIN TYPE 1 PER WSDOT STD PLAN B-5.20-01.
2. CATCH BASIN TYPE 2 PER WSDOT STD PLAN B-10.20-01.
3. SCHEDULE A STORM SEWER PIPE.
4. SCHEDULE A CULVERT PIPE.
5. ADJUST MANHOLE/CATCH BASIN.
6. ADJUST MANHOLE AND REPLACE WITH SLIP RESISTANT LIDS.
7. INFILTRATION TRENCH.
8. UNDERDRAIN TRENCH.
9. UNDERDRAIN TRENCH CLEANOUT.
10. CONCRETE COLLAR FOR CULVERT CONNECTION.

STORMWATER GENERAL NOTES:

1. POTENTIAL LOCATIONS AND APPROXIMATE SIZES FOR STORMWATER PONDS A AND B FOOTPRINTS ARE SHOWN FOR REVIEW. GRADING AND DETAILED CONVEYANCE PIPES WILL BE DESIGNED IN LATER SUBMITTAL.
2. STORMWATER CONVEYANCE SYSTEMS DEPICTED IN THE DRAFT 30 PERCENT PLANS ARE FOR PRELIMINARY DESIGN PURPOSES. STORMWATER CONVEYANCE SYSTEM DESIGN MAY CHANGE DURING FINAL DESIGN IF CONFLICTS WITH EXISTING UTILITIES.
3. PERMEABLE PAVEMENT (POROUS HMA) IS PROPOSED FOR THE PROPOSED TRAIL SURFACE FOR ALL AREAS WHERE INFILTRATION IS LIKELY TO BE FEASIBLE. FURTHER GEOTECHNICAL INVESTIGATION IS REQUIRED TO CONFIRM WHETHER OR NOT THE UNDERLYING SOILS HAVE SUITABLE INFILTRATION RATES TO SUPPORT POROUS HMA. FOR THE DRAFT 30 PERCENT DESIGN PLANS, AREAS ADJACENT TO WETLANDS A, G AND H ARE PROPOSED TO USE CONVENTIONAL HMA UNTIL FURTHER GEOTECHNICAL INVESTIGATION IS PERFORMED TO CONFIRM IF UNDERLYING SOIL TYPES AND GROUNDWATER ELEVATIONS ARE SUITABLE TO INSTALL PERMEABLE PAVEMENT.

LEGEND:

	IMPERVIOUS HMA TRAIL PAVEMENT
	POROUS HMA TRAIL PAVEMENT
	BOARDWALK

30 % REVIEW SUBMITTAL
NOT FOR CONSTRUCTION

PLAN AND PROFILE

SHEET NO.
29 OF 33

AL23

REVISIONS	DATE	BY	DESIGNED
			J. JUN
			DRAWN
			B. PURGANAN
			CHECKED
			Y. HO
			APPROVED
			J. DVORAK

ONE INCH AT FULL SCALE. IF NOT, SCALE ACCORDINGLY
FILE NAME
PS1521151P2CT2T2AL-01
SUB No.
554-1521-151 P2C T2T200C
DATE
MARCH 2017



Parametrix
ENGINEERING · PLANNING · ENVIRONMENTAL SCIENCES

719 2ND AVENUE, SUITE 200 | SEATTLE, WA 98104
P 206.394.3700
WWW.PARAMETRIX.COM

PROJECT NAME

LAKE TO SOUND TRAIL
SEGMENT C

FROM S 200TH ST TO S NORMANDY ROAD /
DES MOINES MEMORIAL DRIVE INTERSECTION

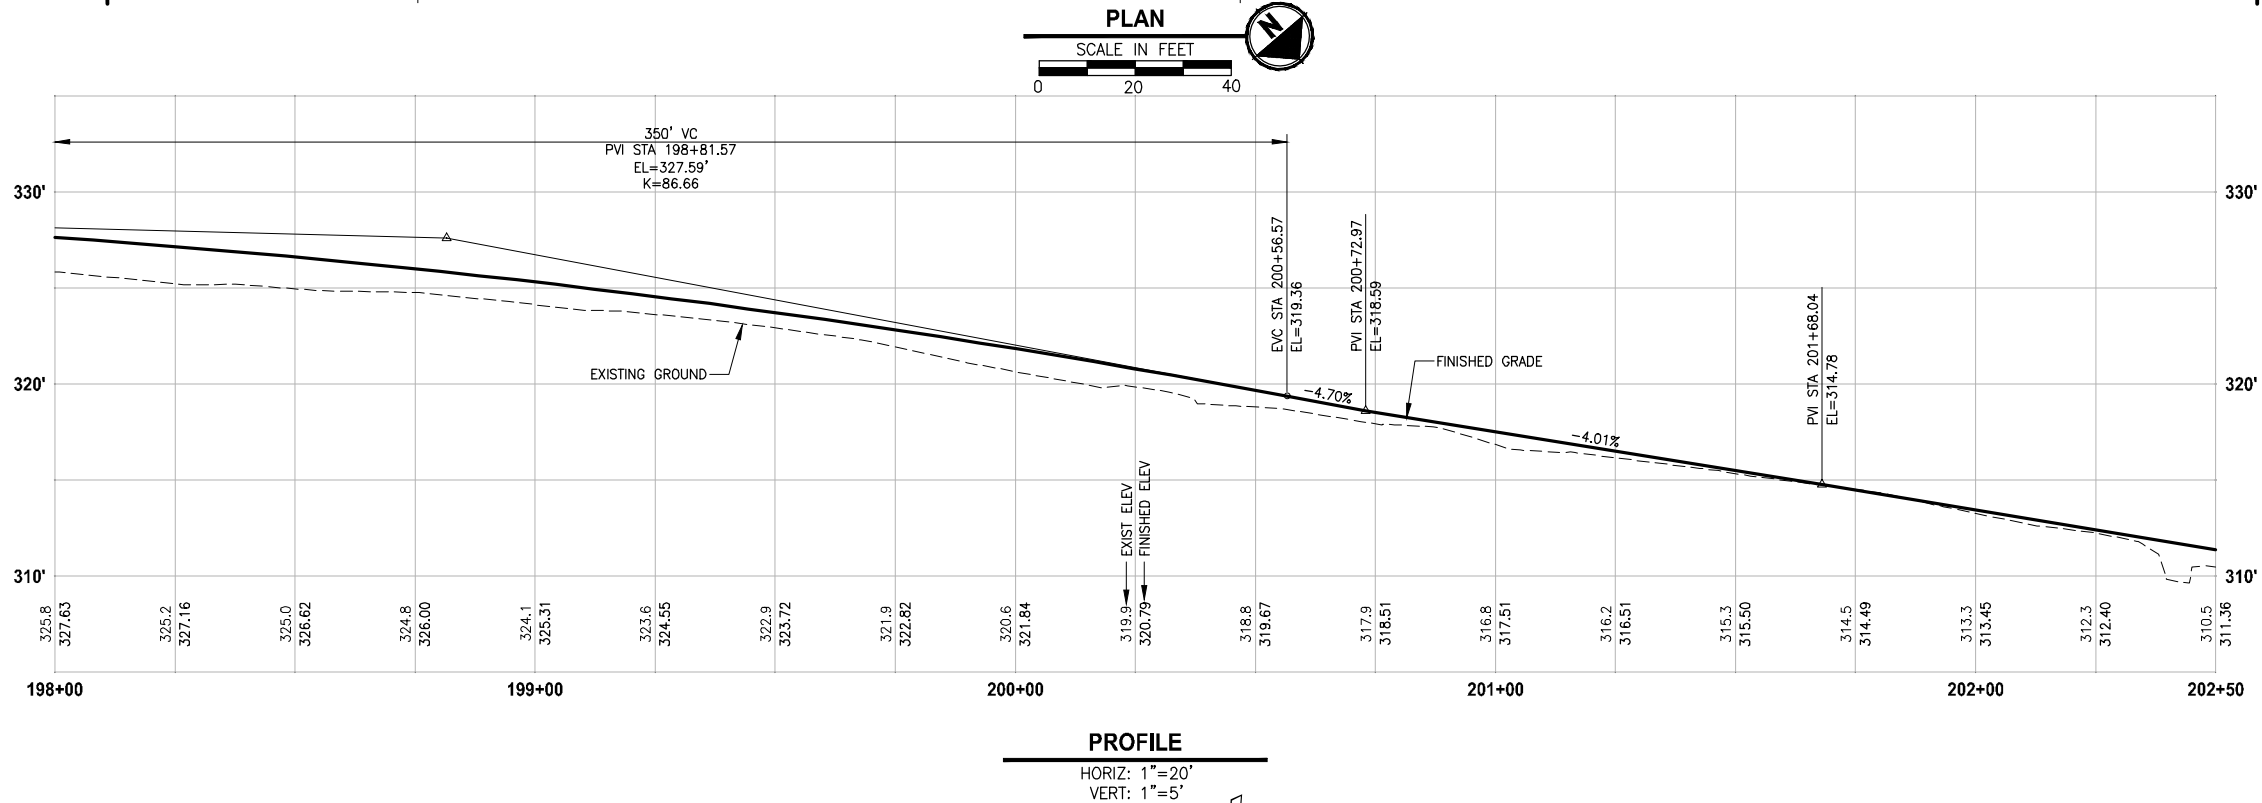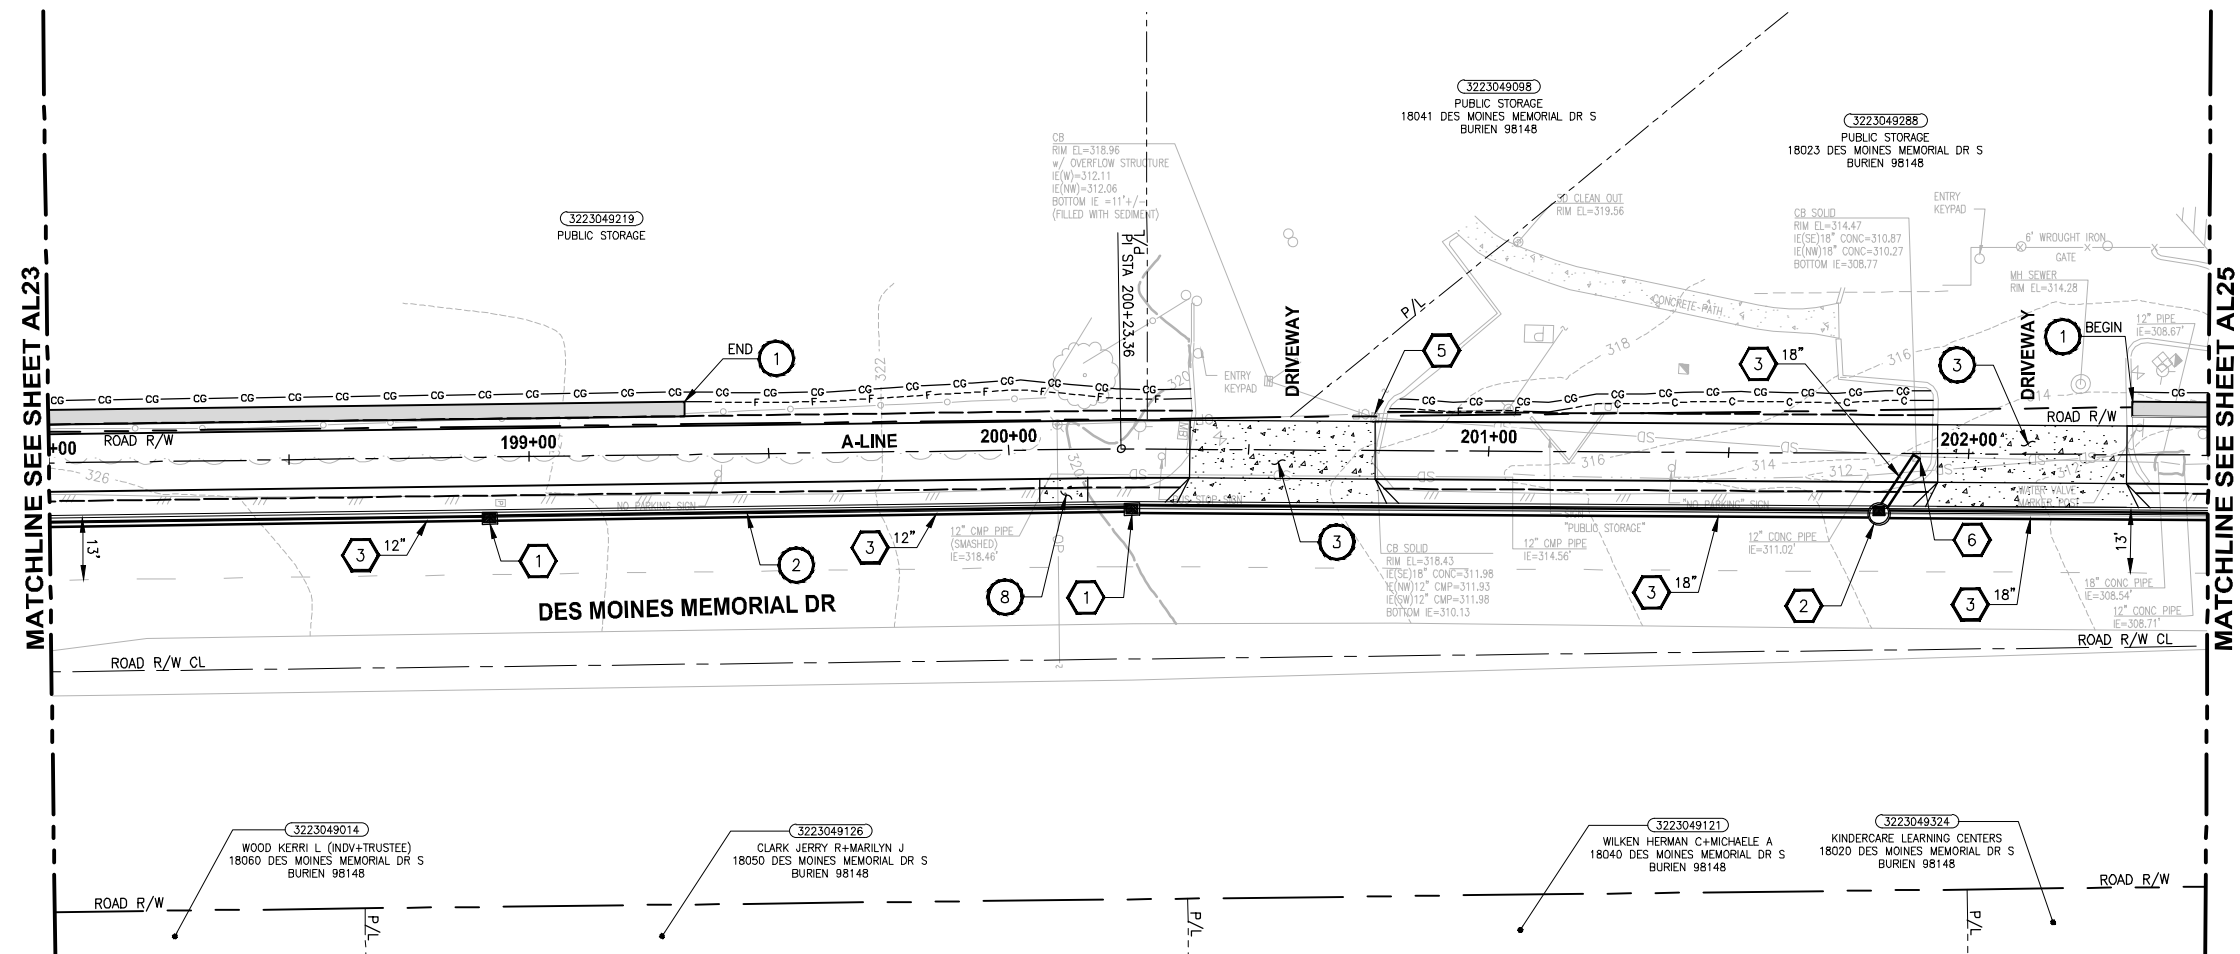

CIVIL CONSTRUCTION NOTES:

- 1 INSTALL RETAINING WALL.
- 2 CEMENT CONCRETE CURB AND GUTTER PER WSDOT STD PLAN F-10.12-03.
- 3 CEMENT CONCRETE DRIVEWAY ENTRANCE TYPE 3 PER WSDOT STD PLAN F-80.10-03.
- 4 PERPENDICULAR CURB RAMP PER WSDOT STD PLAN F-40.15-03.
- 5 MOUNTABLE CEMENT CONCRETE TRAFFIC CURB PER WSDOT STD PLAN F-10.12-03.
- 6 RAISED TRAFFIC ISLAND.
- 7 ELEVATED STRUCTURE.
- 8 BUS LANDING PAD.
- 9 CROSSWALK PER WSDOT STD PLAN M-15.10-01.
- 10 ASPHALT RAMP TRANSITION TO EXISTING GROUND.

STORMWATER CONSTRUCTION NOTES:

- 1 CATCH BASIN TYPE 1 PER WSDOT STD PLAN B-5.20-01.
- 2 CATCH BASIN TYPE 2 PER WSDOT STD PLAN B-10.20-01.
- 3 SCHEDULE A STORM SEWER PIPE.
- 4 SCHEDULE A CULVERT PIPE.
- 5 ADJUST MANHOLE/CATCH BASIN.
- 6 ADJUST MANHOLE AND REPLACE WITH SLIP RESISTANT LIDS.
- 7 INFILTRATION TRENCH.
- 8 UNDERDRAIN TRENCH.
- 9 UNDERDRAIN TRENCH CLEANOUT.
- 10 CONCRETE COLLAR FOR CULVERT CONNECTION.

STORMWATER GENERAL NOTES:

1. POTENTIAL LOCATIONS AND APPROXIMATE SIZES FOR STORMWATER PONDS A AND B FOOTPRINTS ARE SHOWN FOR REVIEW. GRADING AND DETAILED CONVEYANCE PIPES WILL BE DESIGNED IN LATER SUBMITTAL.
2. STORMWATER CONVEYANCE SYSTEMS DEPICTED IN THE DRAFT 30 PERCENT PLANS ARE FOR PRELIMINARY DESIGN PURPOSES. STORMWATER CONVEYANCE SYSTEM DESIGN MAY CHANGE DURING FINAL DESIGN IF CONFLICTS WITH EXISTING UTILITIES.
3. PERMEABLE PAVEMENT (POROUS HMA) IS PROPOSED FOR THE PROPOSED TRAIL SURFACE FOR ALL AREAS WHERE INFILTRATION IS LIKELY TO BE FEASIBLE. FURTHER GEOTECHNICAL INVESTIGATION IS REQUIRED TO CONFIRM WHETHER OR NOT THE UNDERLYING SOILS HAVE SUITABLE INFILTRATION RATES TO SUPPORT POROUS HMA. FOR THE DRAFT 30 PERCENT DESIGN AREAS ADJACENT TO WETLANDS A, C AND H ARE PROPOSED TO USE CONVENTIONAL HMA UNTIL FURTHER GEOTECHNICAL INVESTIGATION IS PERFORMED TO CONFIRM IF UNDERLYING SOIL TYPES AND GROUNDWATER ELEVATIONS ARE SUITABLE TO INSTALL PERMEABLE PAVEMENT.

LEGEND:

Diagram illustrating the three types of pavement layers:

- IMPERVIOUS HMA TRAIL PAVEMENT
- POROUS HMA TRAIL PAVEMENT
- BOARDWALK




30 % REVIEW SUBMITTAL
NOT FOR CONSTRUCTION

PLAN AND PROFILE

SHEET NO.
OF 33

AL24

 PATH: U:\PSO\Projects\Clients\1521-KingCo\554-1521-151 L2ST-SegC\995vec\CAADD\Phase 2C\Task 2T200C.DWG PLOTTED BY: purgaban DATE: Thursday, March 09, 2017 5:00:37 PM LAYOUT: AL25

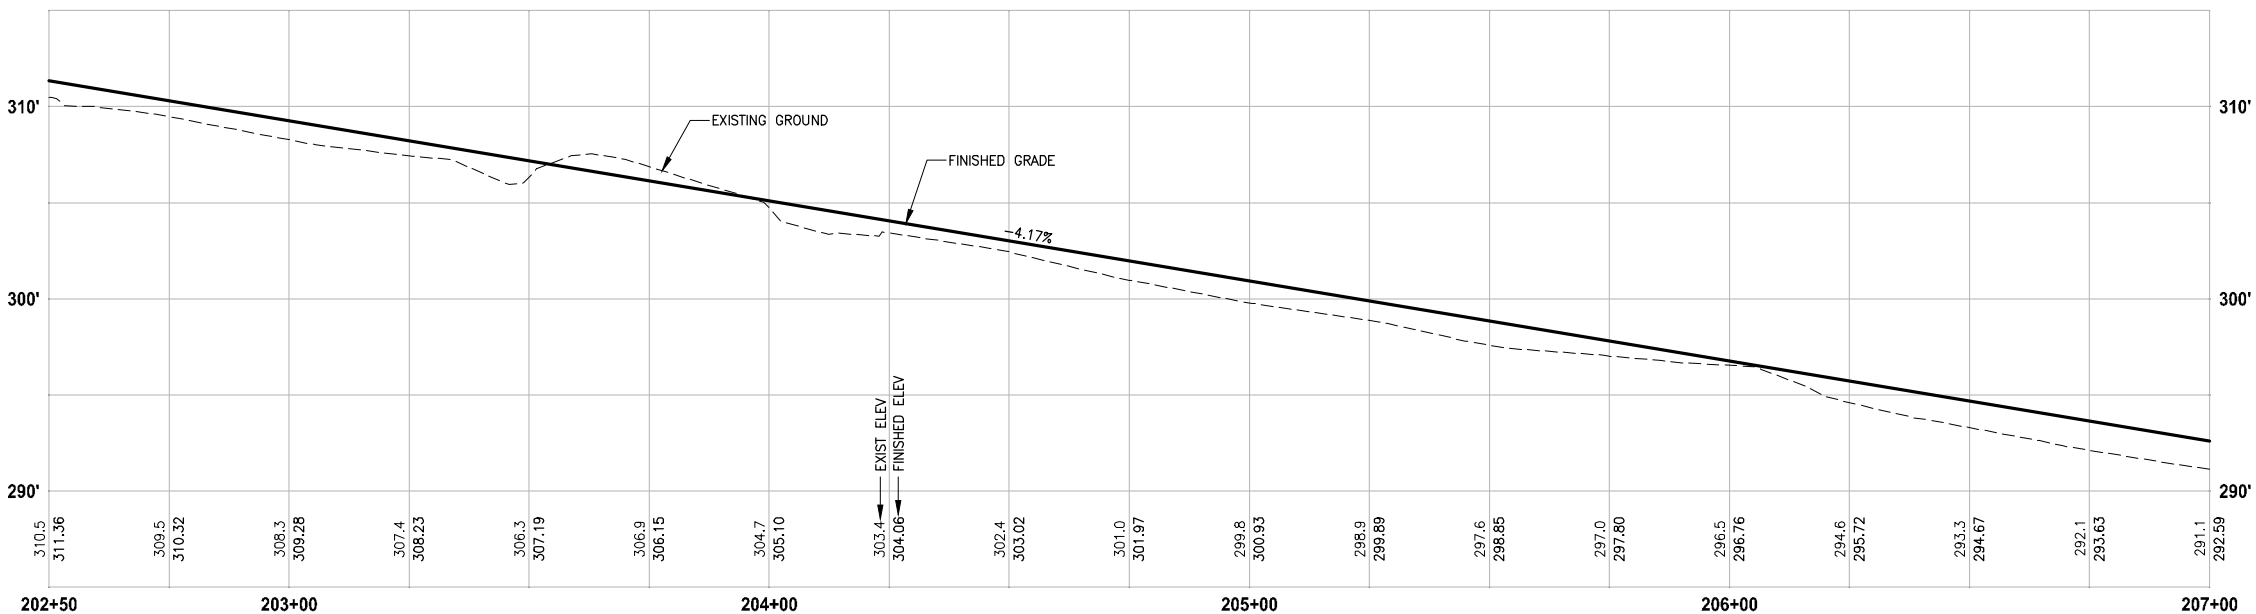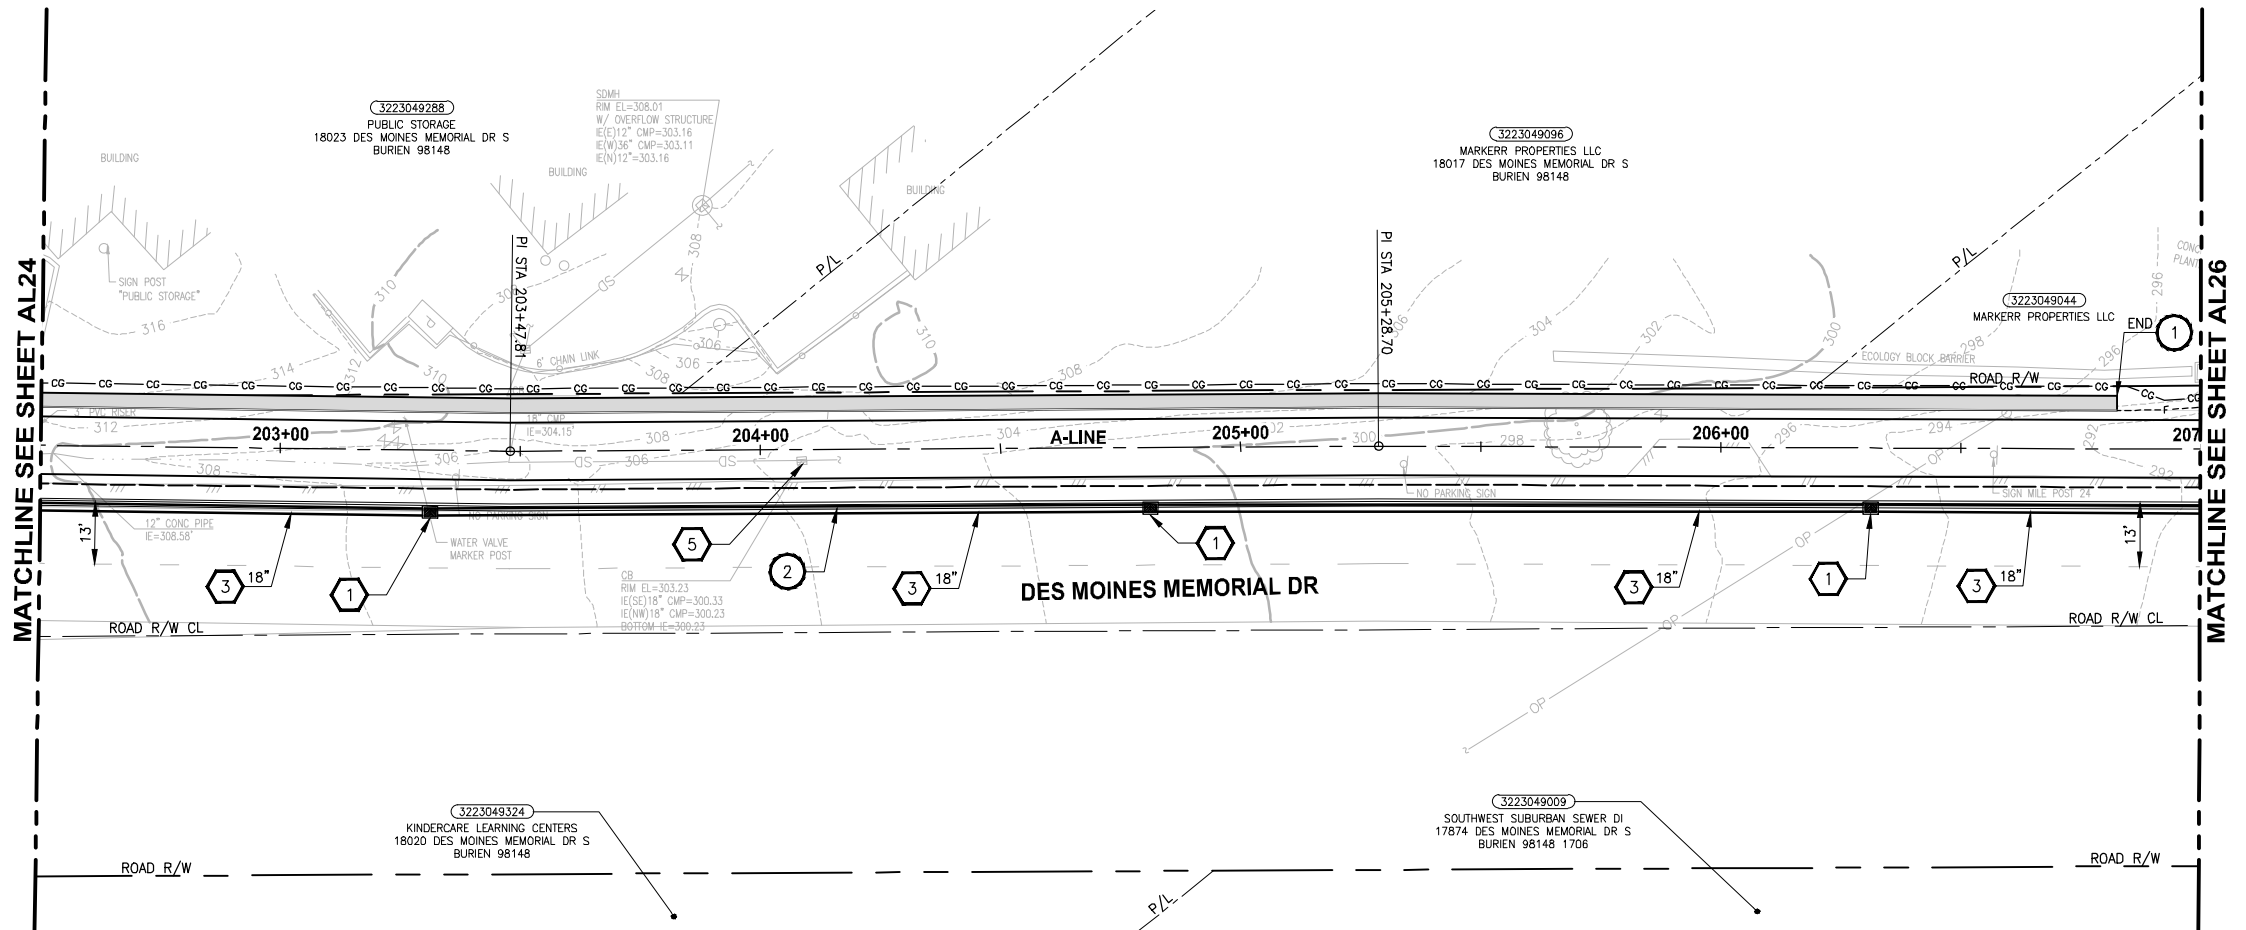

PROFILE

HORIZ: 1"=20'
VERT: 1"=5'

CIVIL CONSTRUCTION NOTES:

1. INSTALL RETAINING WALL.
2. CEMENT CONCRETE CURB AND GUTTER PER WSDOT STD PLAN F-10.12-03.
3. CEMENT CONCRETE DRIVEWAY ENTRANCE TYPE 3 PER WSDOT STD PLAN F-80.10-03.
4. PERPENDICULAR CURB RAMP PER WSDOT STD PLAN F-40.15-03.
5. MOUNTABLE CEMENT CONCRETE TRAFFIC CURB PER WSDOT STD PLAN F-10.12-03.
6. RAISED TRAFFIC ISLAND.
7. ELEVATED STRUCTURE.
8. BUS LANDING PAD.
9. CROSSWALK PER WSDOT STD PLAN M-15.10-01.
10. ASPHALT RAMP TRANSITION TO EXISTING GROUND.

STORMWATER CONSTRUCTION NOTES:

1. CATCH BASIN TYPE 1 PER WSDOT STD PLAN B-5.20-01.
2. CATCH BASIN TYPE 2 PER WSDOT STD PLAN B-10.20-01.
3. SCHEDULE A STORM SEWER PIPE.
4. SCHEDULE A CULVERT PIPE.
5. ADJUST MANHOLE/CATCH BASIN.
6. ADJUST MANHOLE AND REPLACE WITH SLIP RESISTANT LIDS.
7. INFILTRATION TRENCH.
8. UNDERDRAIN TRENCH.
9. UNDERDRAIN TRENCH CLEANOUT.
10. CONCRETE COLLAR FOR CULVERT CONNECTION.

STORMWATER GENERAL NOTES:

1. POTENTIAL LOCATIONS AND APPROXIMATE SIZES FOR STORMWATER PONDS A AND B FOOTPRINTS ARE SHOWN FOR REVIEW. GRADING AND DETAILED CONVEYANCE PIPES WILL BE DESIGNED IN LATER SUBMITTAL.
2. STORMWATER CONVEYANCE SYSTEMS DEPICTED IN THE DRAFT 30 PERCENT PLANS ARE FOR PRELIMINARY DESIGN PURPOSES. STORMWATER CONVEYANCE SYSTEM DESIGN MAY CHANGE DURING FINAL DESIGN IF CONFLICTS WITH EXISTING UTILITIES.
3. PERMEABLE PAVEMENT (POROUS HMA) IS PROPOSED FOR THE PROPOSED TRAIL SURFACE FOR ALL AREAS WHERE INFILTRATION IS LIKELY TO BE FEASIBLE. FURTHER GEOTECHNICAL INVESTIGATION IS REQUIRED TO CONFIRM WHETHER OR NOT THE UNDERLYING SOILS HAVE SUITABLE INFILTRATION RATES TO SUPPORT POROUS HMA. FOR THE DRAFT 30 PERCENT DESIGN PLANS, AREAS ADJACENT TO WETLANDS A, G AND H ARE PROPOSED TO USE CONVENTIONAL HMA UNTIL FURTHER GEOTECHNICAL INVESTIGATION IS PERFORMED TO CONFIRM IF UNDERLYING SOIL TYPES AND GROUNDWATER ELEVATIONS ARE SUITABLE TO INSTALL PERMEABLE PAVEMENT.

LEGEND:

- | | |
|--|-------------------------------|
| | IMPERVIOUS HMA TRAIL PAVEMENT |
| | POROUS HMA TRAIL PAVEMENT |
| | BOARDWALK |

30 % REVIEW SUBMITTAL
NOT FOR CONSTRUCTION

REVISIONS	DATE	BY	DESIGNED
			J. JUN
			B. PURGANAN
			Y. HO
			J. DVORAK

ONE INCH AT FULL SCALE. IF NOT, SCALE ACCORDINGLY
FILE NAME PS1521151P2CT2T2AL-01
JOB No. 554-1521-151 P2C T2T200C
DATE MARCH 2017

PRELIMINARY

Parametrix
ENGINEERING · PLANNING · ENVIRONMENTAL SCIENCES

719 2ND AVENUE, SUITE 200 | SEATTLE, WA 98104
P 206.394.3700
WWW.PARAMETRIX.COM

PROJECT NAME

**LAKE TO SOUND TRAIL
SEGMENT C**




FROM S 200TH ST TO S NORMANDY ROAD /
DES MOINES MEMORIAL DRIVE INTERSECTION

PLAN AND PROFILE

SHEET NO.
31 OF 33

AL25

 PATH: U:\PSO\Projects\Clients\1521-KingCo\1521-151 L25T-SegC\995SecC\CADD\Phase 2C\Task 2T200C\DWG LAYOUT: AL26 PLOTTED BY: purgabub DATE: Thursday, March 09, 2017 5:00:57 PM

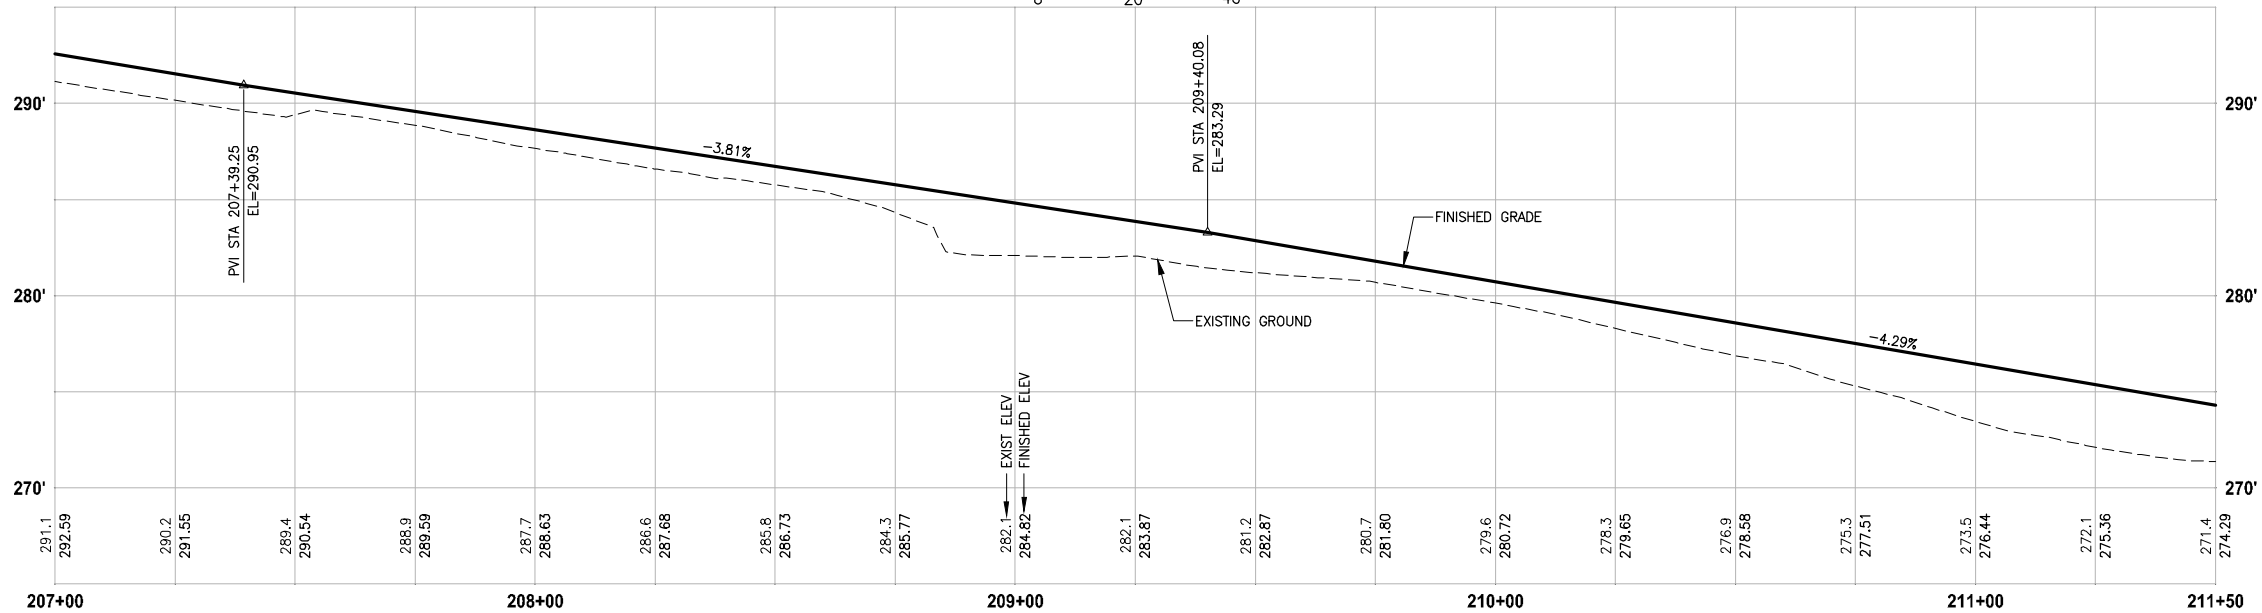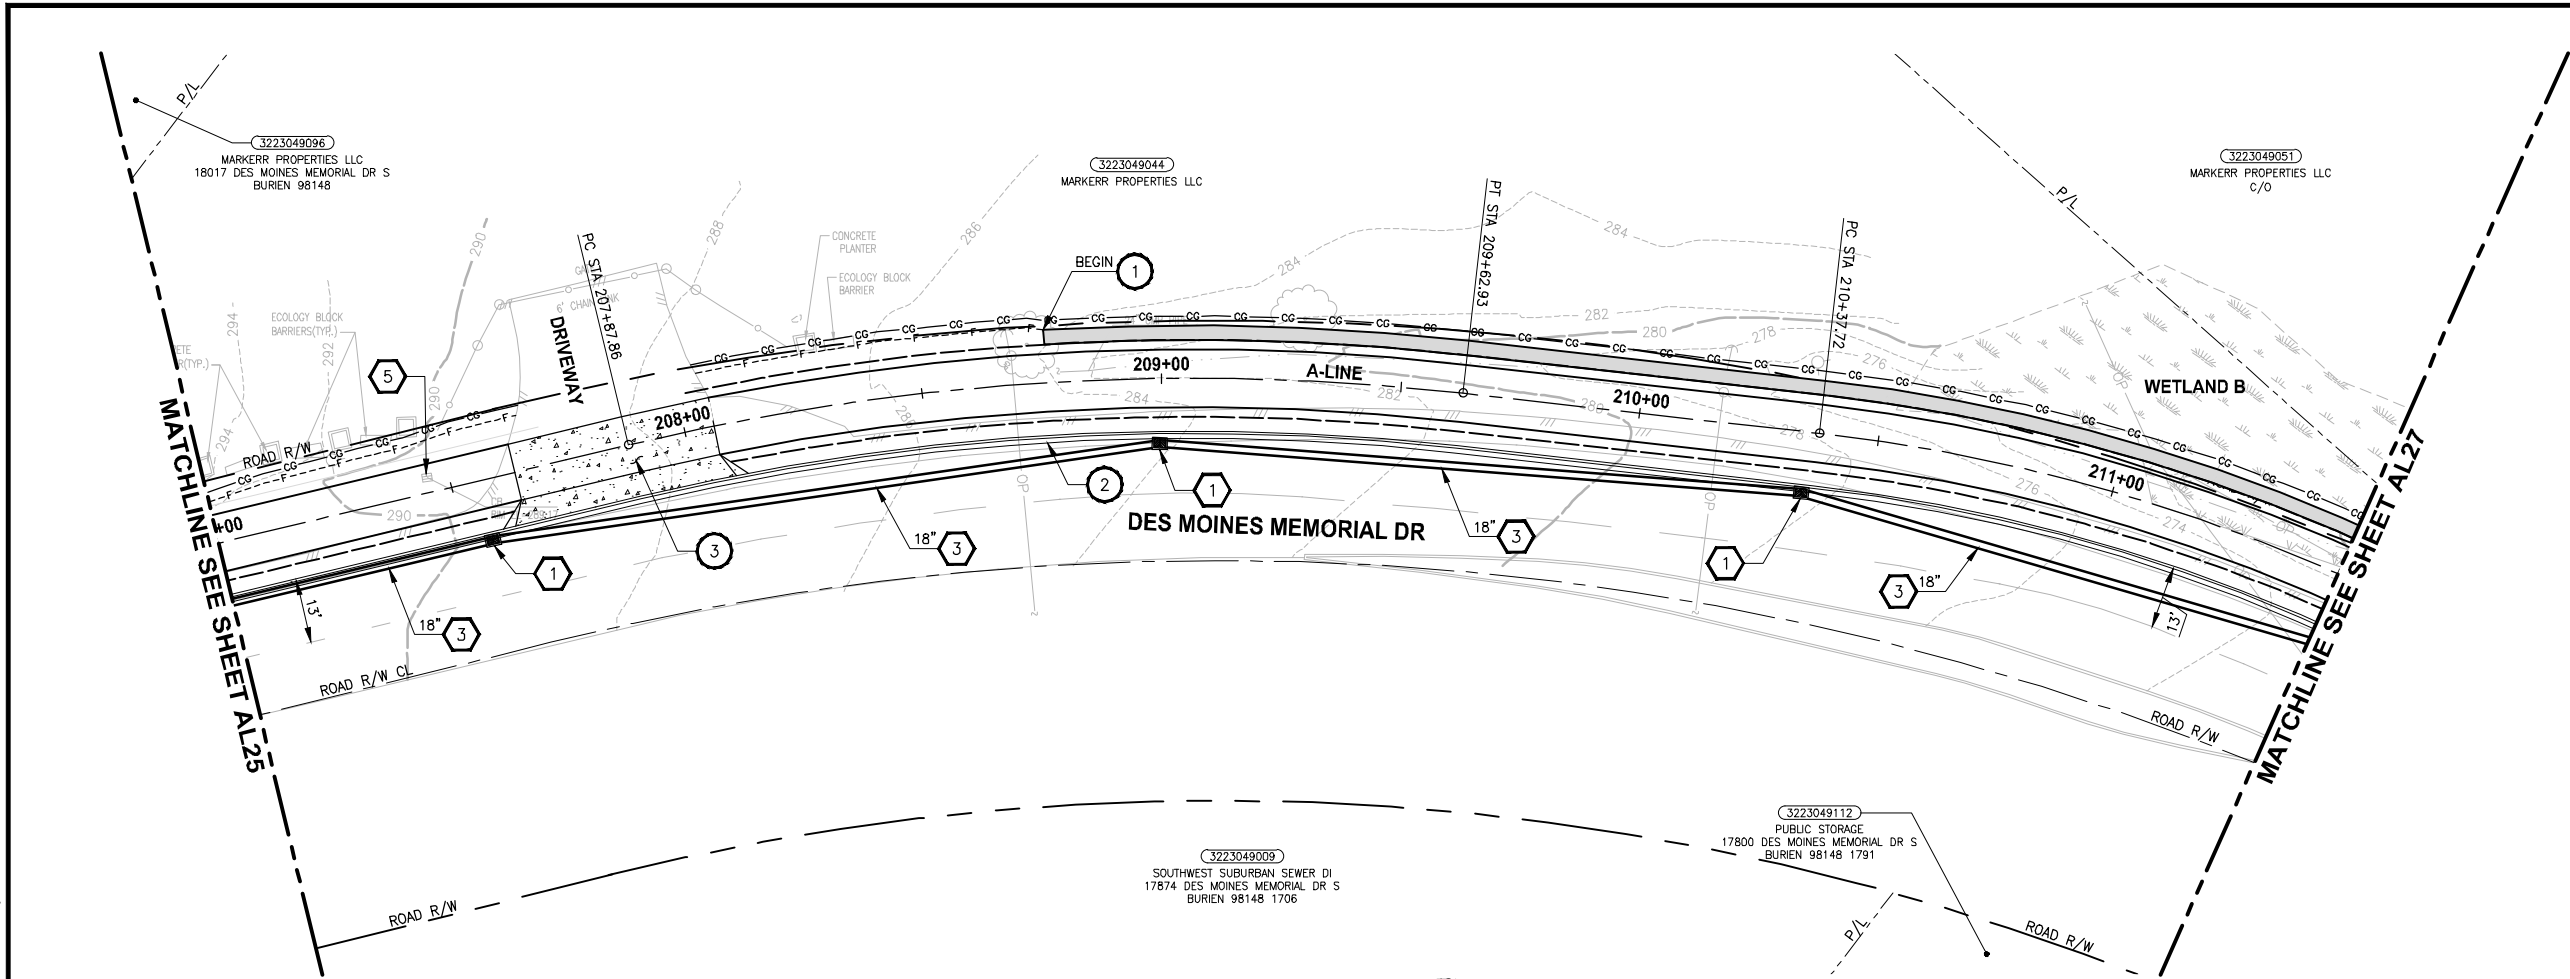

PROFILE

HORIZ: 1"=20'
VERT: 1"=5'

CIVIL CONSTRUCTION NOTES:

1. INSTALL RETAINING WALL.
2. CEMENT CONCRETE CURB AND GUTTER PER WSDOT STD PLAN F-10.12-03.
3. CEMENT CONCRETE DRIVEWAY ENTRANCE TYPE 3 PER WSDOT STD PLAN F-80.10-03.
4. PERPENDICULAR CURB RAMP PER WSDOT STD PLAN F-40.15-03.
5. MOUNTABLE CEMENT CONCRETE TRAFFIC CURB PER WSDOT STD PLAN F-10.12-03.
6. RAISED TRAFFIC ISLAND.
7. ELEVATED STRUCTURE.
8. BUS LANDING PAD.
9. CROSSWALK PER WSDOT STD PLAN M-15.10-01.
10. ASPHALT RAMP TRANSITION TO EXISTING GROUND.

STORMWATER CONSTRUCTION NOTES:

1. CATCH BASIN TYPE 1 PER WSDOT STD PLAN B-5.20-01.
2. CATCH BASIN TYPE 2 PER WSDOT STD PLAN B-10.20-01.
3. SCHEDULE A STORM SEWER PIPE.
4. SCHEDULE A CULVERT PIPE.
5. ADJUST MANHOLE/CATCH BASIN.
6. ADJUST MANHOLE AND REPLACE WITH SLIP RESISTANT LIDS.
7. INFILTRATION TRENCH.
8. UNDERDRAIN TRENCH.
9. UNDERDRAIN TRENCH CLEANOUT.
10. CONCRETE COLLAR FOR CULVERT CONNECTION.

STORMWATER GENERAL NOTES:

1. POTENTIAL LOCATIONS AND APPROXIMATE SIZES FOR STORMWATER PONDS A AND B FOOTPRINTS ARE SHOWN FOR REVIEW. GRADING AND DETAILED CONVEYANCE PIPES WILL BE DESIGNED IN LATER SUBMITTAL.
2. STORMWATER CONVEYANCE SYSTEMS DEPICTED IN THE DRAFT 30 PERCENT PLANS ARE FOR PRELIMINARY DESIGN PURPOSES. STORMWATER CONVEYANCE SYSTEM DESIGN MAY CHANGE DURING FINAL DESIGN IF CONFLICTS WITH EXISTING UTILITIES.
3. PERMEABLE PAVEMENT (POROUS HMA) IS PROPOSED FOR THE PROPOSED TRAIL SURFACE FOR ALL AREAS WHERE INFILTRATION IS LIKELY TO BE FEASIBLE. FURTHER GEOTECHNICAL INVESTIGATION IS REQUIRED TO CONFIRM WHETHER OR NOT THE UNDERLYING SOILS HAVE SUITABLE INFILTRATION RATES TO SUPPORT POROUS HMA. FOR THE DRAFT 30 PERCENT DESIGN PLANS, AREAS ADJACENT TO WETLANDS A, G AND H ARE PROPOSED TO USE CONVENTIONAL HMA UNTIL FURTHER GEOTECHNICAL INVESTIGATION IS PERFORMED TO CONFIRM IF UNDERLYING SOIL TYPES AND GROUNDWATER ELEVATIONS ARE SUITABLE TO INSTALL PERMEABLE PAVEMENT.

LEGEND:

- | | |
|--|-------------------------------|
| | IMPERVIOUS HMA TRAIL PAVEMENT |
| | POROUS HMA TRAIL PAVEMENT |
| | BOARDWALK |

30 % REVIEW SUBMITTAL
NOT FOR CONSTRUCTION

REVISIONS	DATE	BY	DESIGNED
			J. JUN
			B. PURGANAN
			Y. HO
			J. DVORAK

ONE INCH AT FULL SCALE. IF NOT, SCALE ACCORDINGLY
FILE NAME PS1521151P2CT2T2AL-01
JOB No. 584-1521-151 P2C T2T200C
DATE MARCH 2017

PRELIMINARY

Parametrix
ENGINEERING · PLANNING · ENVIRONMENTAL SCIENCES

719 2ND AVENUE, SUITE 200 | SEATTLE, WA 98104
P 206.394.3700
WWW.PARAMETRIX.COM

PROJECT NAME

LAKE TO SOUND TRAIL
SEGMENT C



FROM S 200TH ST TO S NORMANDY ROAD /
DES MOINES MEMORIAL DRIVE INTERSECTION

PLAN AND PROFILE

SHEET NO.
32 OF 33

AL26

PATH: U:\PSO\Projects\Clients\1521-KingCo\554-1521-151 L25T-SegC\995Sec\CA00\Phase 2C\Task 2T200C\DWG PLOTTED BY: purgabit DATE: Friday, March 10, 2017 12:13:50 PM LAYOUT: AL27

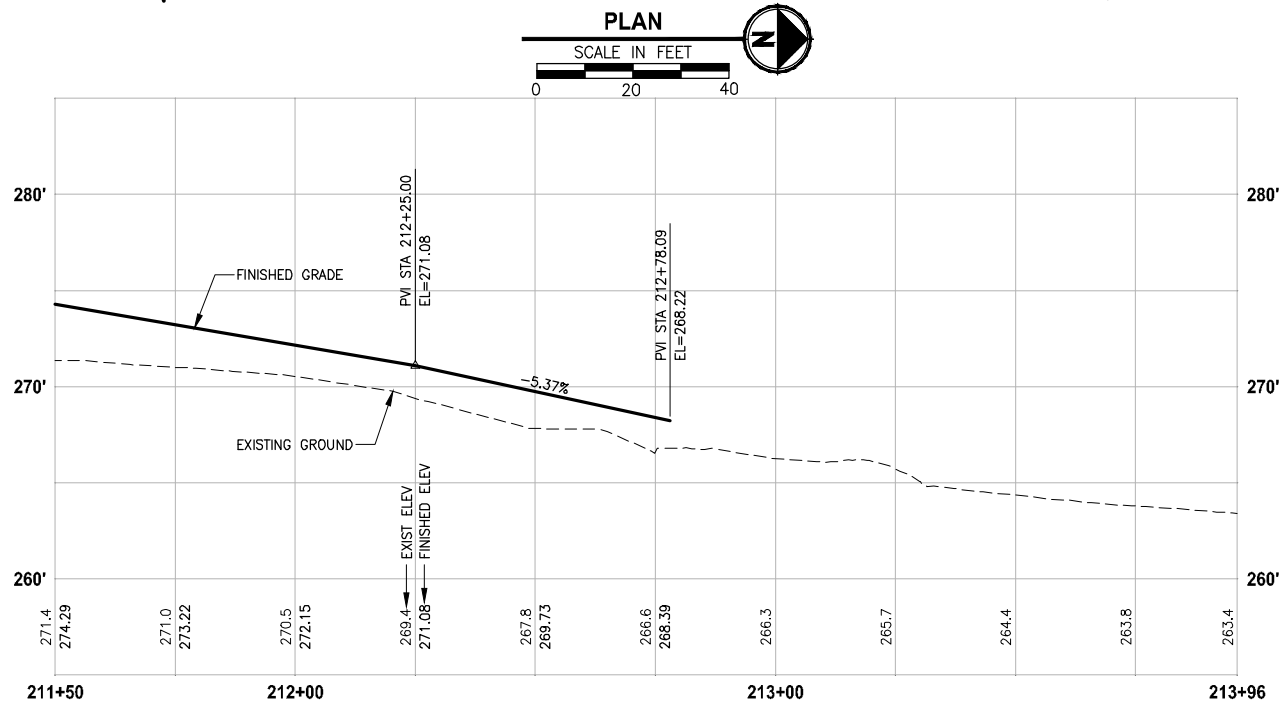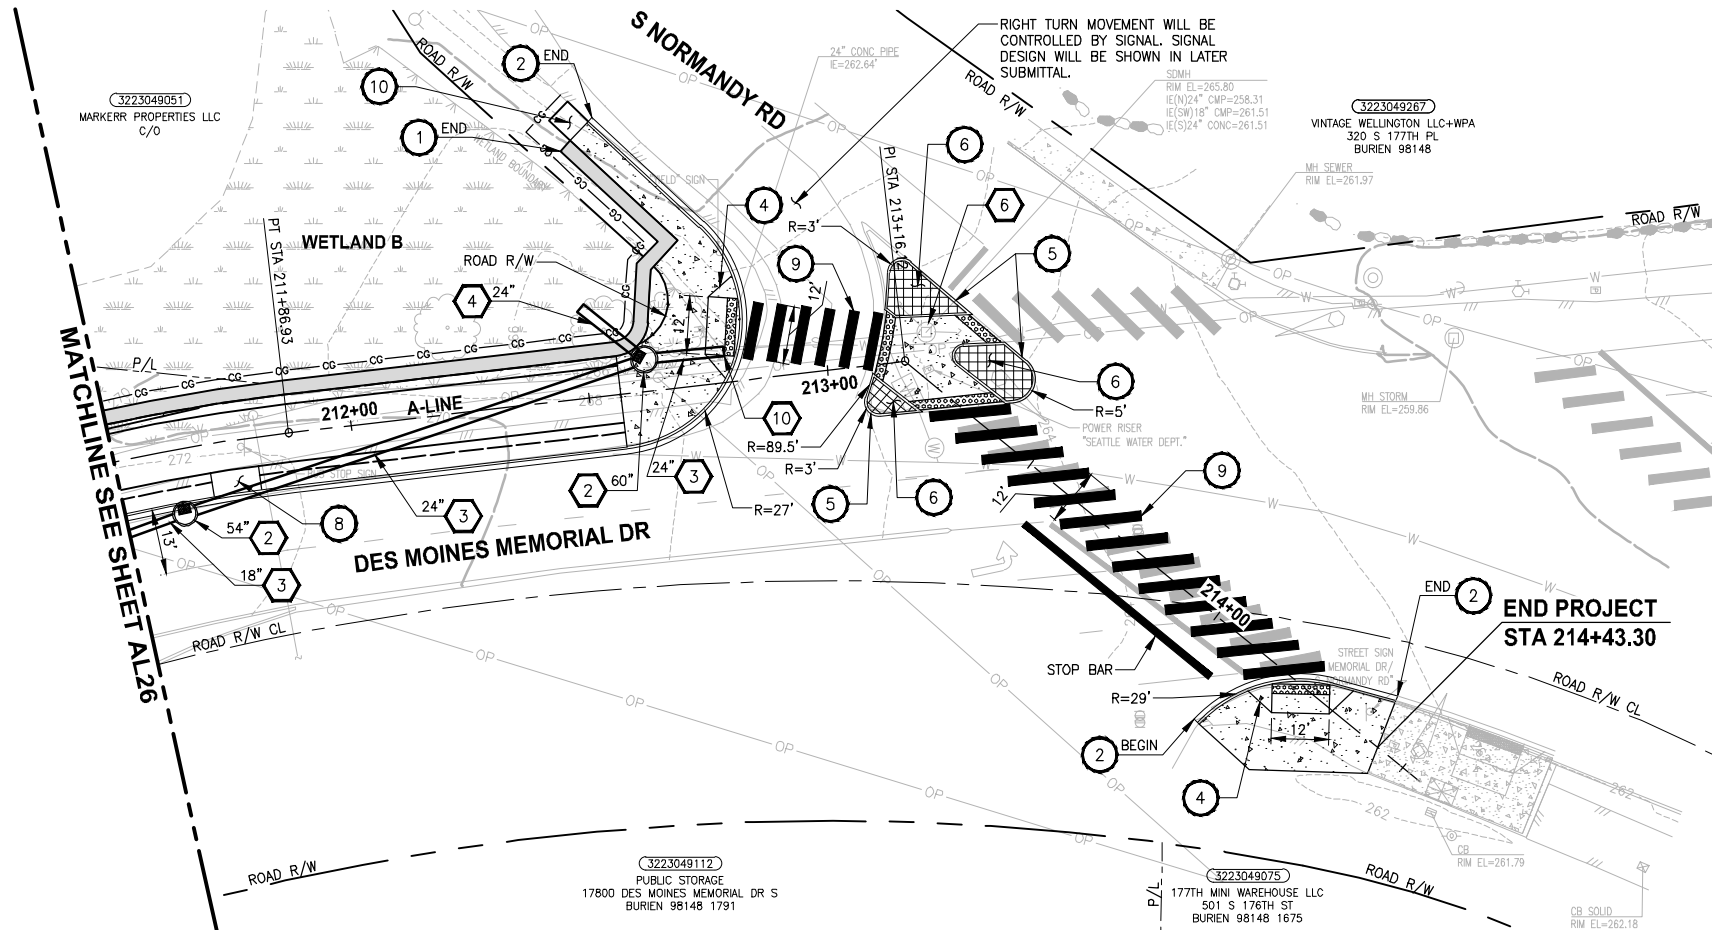

PROFILE

HORIZ: 1"=20'
VERT: 1"=5'

CIVIL CONSTRUCTION NOTES:

1. INSTALL RETAINING WALL.
2. CEMENT CONCRETE CURB AND GUTTER PER WSDOT STD PLAN F-10.12-03.
3. CEMENT CONCRETE DRIVEWAY ENTRANCE TYPE 3 PER WSDOT STD PLAN F-80.10-03.
4. PERPENDICULAR CURB RAMP PER WSDOT STD PLAN F-40.15-03.
5. MOUNTABLE CEMENT CONCRETE TRAFFIC CURB PER WSDOT STD PLAN F-10.12-03.
6. RAISED TRAFFIC ISLAND.
7. ELEVATED STRUCTURE.
8. BUS LANDING PAD.
9. CROSSWALK PER WSDOT STD PLAN M-15.10-01.
10. ASPHALT RAMP TRANSITION TO EXISTING GROUND.

STORMWATER CONSTRUCTION NOTES:

1. CATCH BASIN TYPE 1 PER WSDOT STD PLAN B-5.20-01.
2. CATCH BASIN TYPE 2 PER WSDOT STD PLAN B-10.20-01.
3. SCHEDULE A STORM SEWER PIPE.
4. SCHEDULE A CULVERT PIPE.
5. ADJUST MANHOLE/CATCH BASIN.
6. ADJUST MANHOLE AND REPLACE WITH SLIP RESISTANT LIDS.
7. INFILTRATION TRENCH.
8. UNDERDRAIN TRENCH.
9. UNDERDRAIN TRENCH CLEANOUT.
10. CONCRETE COLLAR FOR CULVERT CONNECTION.

STORMWATER GENERAL NOTES:

1. POTENTIAL LOCATIONS AND APPROXIMATE SIZES FOR STORMWATER PONDS A AND B FOOTPRINTS ARE SHOWN FOR REVIEW. GRADING AND DETAILED CONVEYANCE PIPES WILL BE DESIGNED IN LATER SUBMITTAL.
2. STORMWATER CONVEYANCE SYSTEMS DEPICTED IN THE DRAFT 30 PERCENT PLANS ARE FOR PRELIMINARY DESIGN PURPOSES. STORMWATER CONVEYANCE SYSTEM DESIGN MAY CHANGE DURING FINAL DESIGN IF CONFLICTS WITH EXISTING UTILITIES.
3. PERMEABLE PAVEMENT (POROUS HMA) IS PROPOSED FOR THE PROPOSED TRAIL SURFACE FOR ALL AREAS WHERE INFILTRATION IS LIKELY TO BE FEASIBLE. FURTHER GEOTECHNICAL INVESTIGATION IS REQUIRED TO CONFIRM WHETHER OR NOT THE UNDERLYING SOILS HAVE SUITABLE INFILTRATION RATES TO SUPPORT POROUS HMA. FOR THE DRAFT 30 PERCENT DESIGN PLANS, AREAS ADJACENT TO WETLANDS A, G AND H ARE PROPOSED TO USE CONVENTIONAL HMA UNTIL FURTHER GEOTECHNICAL INVESTIGATION IS PERFORMED TO CONFIRM IF UNDERLYING SOIL TYPES AND GROUNDWATER ELEVATIONS ARE SUITABLE TO INSTALL PERMEABLE PAVEMENT.

LEGEND:

- | | |
|--|-------------------------------|
| | IMPERVIOUS HMA TRAIL PAVEMENT |
| | POROUS HMA TRAIL PAVEMENT |
| | BOARDWALK |

30 % REVIEW SUBMITTAL
NOT FOR CONSTRUCTION

REVISIONS	DATE	BY	DESIGNED
			J. JUN
			DRAWN
			B. PURGANAN
			CHECKED
			Y. HO
			APPROVED
			J. DVORAK

ONE INCH AT FULL SCALE. IF NOT, SCALE ACCORDINGLY
FILE NAME
PS1521151P2CT2T2AL-01
JOB No.
554-1521-151 P2C T2T200C
DATE
MARCH 2017

Parametrix
ENGINEERING · PLANNING · ENVIRONMENTAL SCIENCES

719 2ND AVENUE, SUITE 200 | SEATTLE, WA 98104
P 206.394.3700
WWW.PARAMETRIX.COM

PROJECT NAME
**LAKE TO SOUND TRAIL
SEGMENT C**
FROM S 200TH ST TO S NORMANDY ROAD /
DES MOINES MEMORIAL DRIVE INTERSECTION

PLAN AND PROFILE

SHEET NO.
33 OF 33

AL27